




D. Dixon, Jr., AIA
252-247-2127
@coastalarchitecture.net

**16 Bridges St. Ext.,
Suite C
Morehead City, NC
28557**

w.CoastalArchitecture.net

NC074 KIA OF NEW BERN
NEW BERN, NORTH CAROLINA

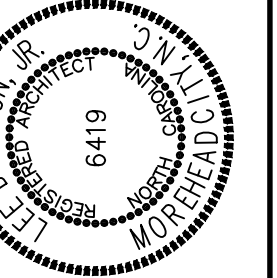

OF PLAN

6034

ED: 20 NOV 18

BY:	BLS, LSA
BY:	LSA


DISCUSSION

HEET NO.


A-1.2
OF



1. PLASTIC LAMINATE EXTERIOR
2. INTERIOR - MELAMINE
3. CONCEALED HINGES THROUGHOUT
4. 6" SATIN NICKEL PULLS
5. ALL SHELVING ADJUSTABLE, W/ COUNTERSUNK STANDARDS.

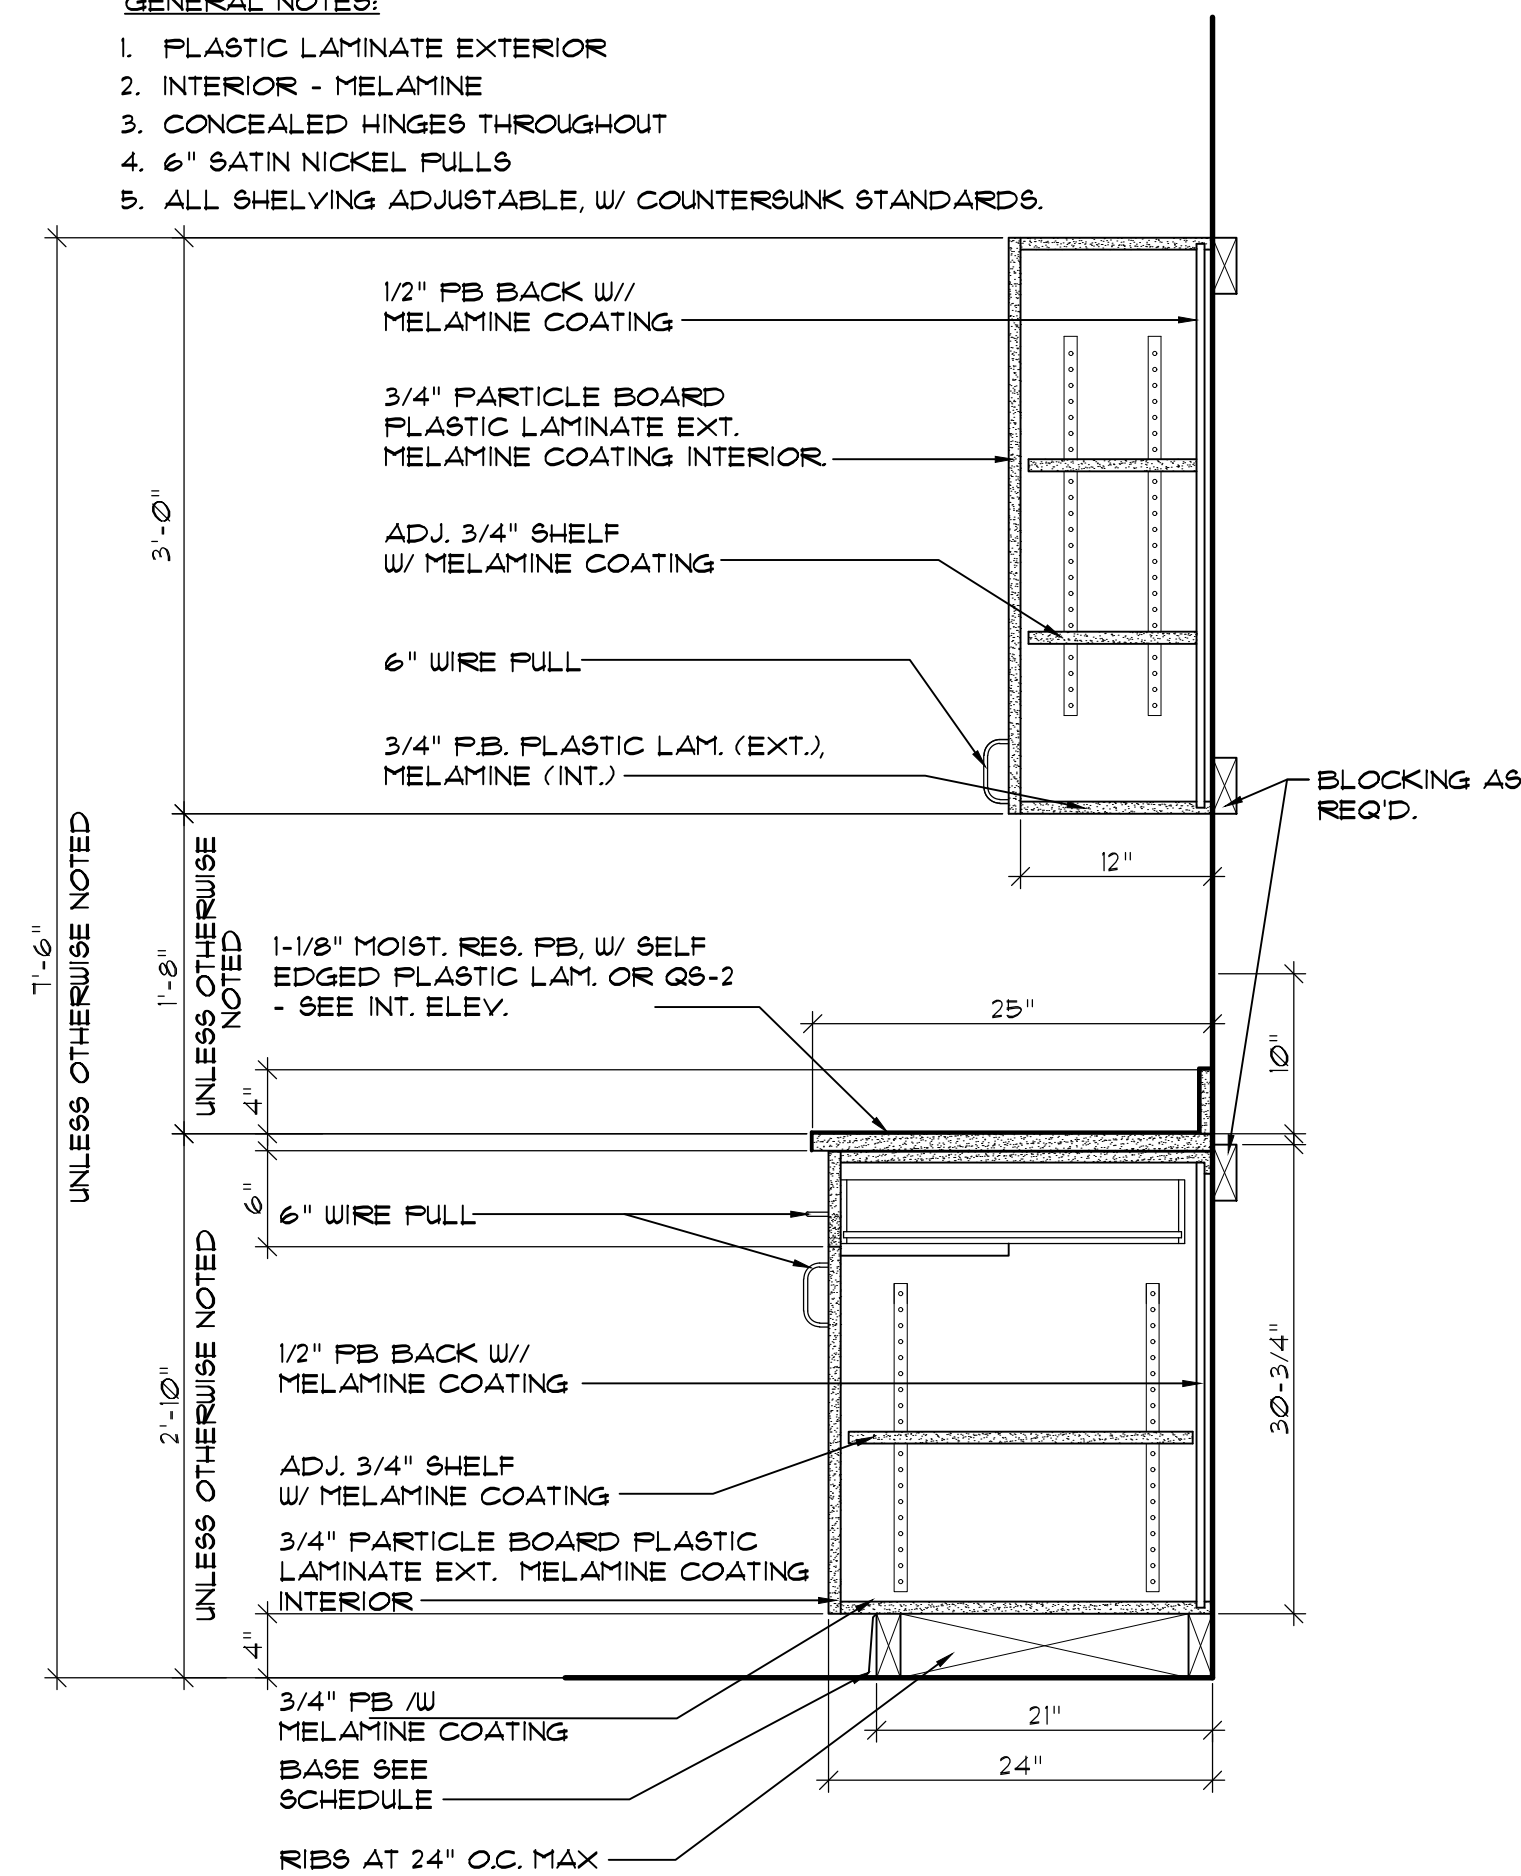


1 TYP. CABINET DETAIL
A-1.3 SCALE: 1"=1'-0"

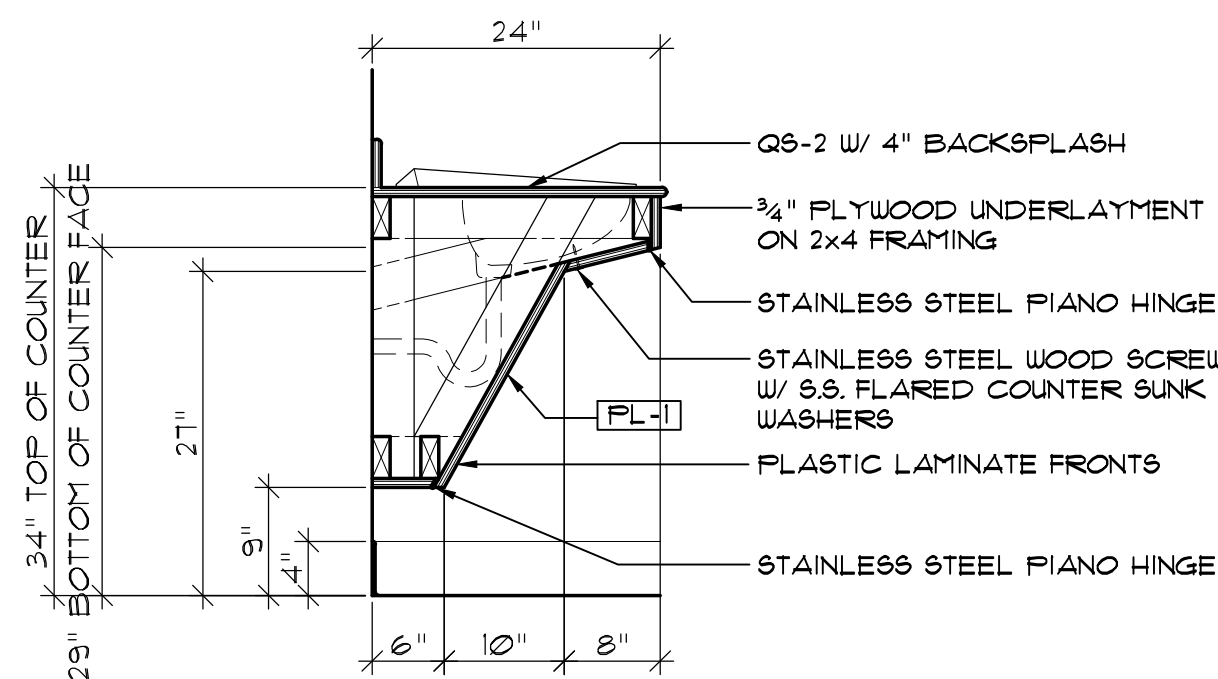


2
A-1.3

H.C. VANITY DETAIL


SCALE: 3/4" = 1'-0"

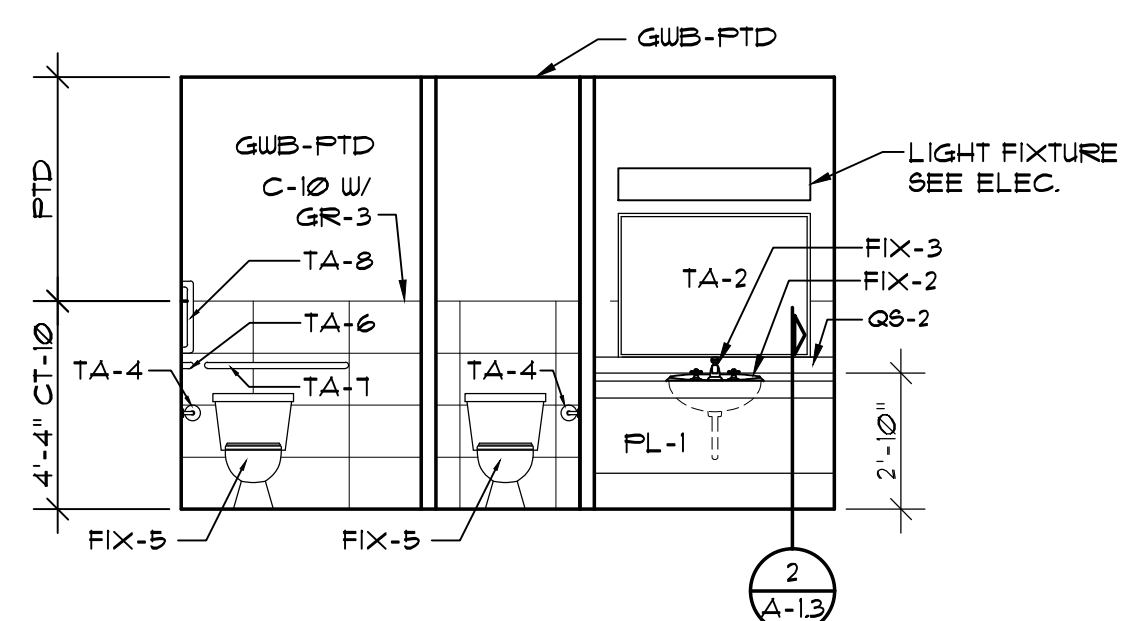

WOMEN 117
INTERIOR ELEVATION
3
A-13
SCALE: 1/4" = 1'-0"

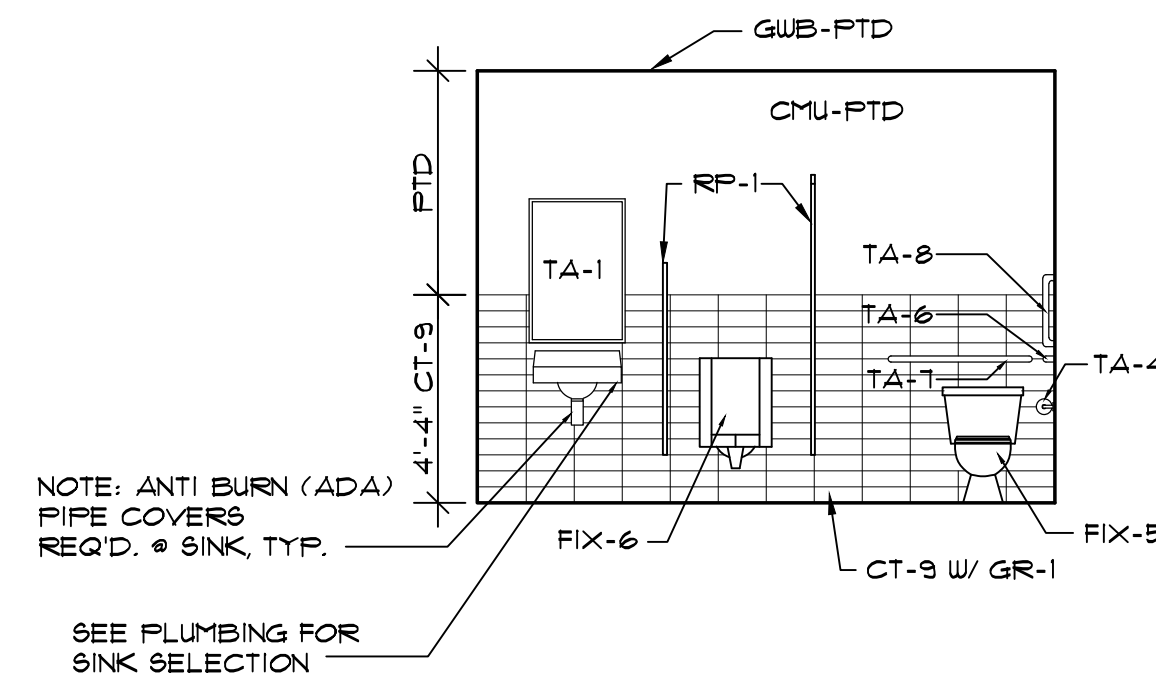


TECH RESTROOM 129
INTERIOR ELEVATION
5
A-13
SCALE: 1/4" = 1'-0"

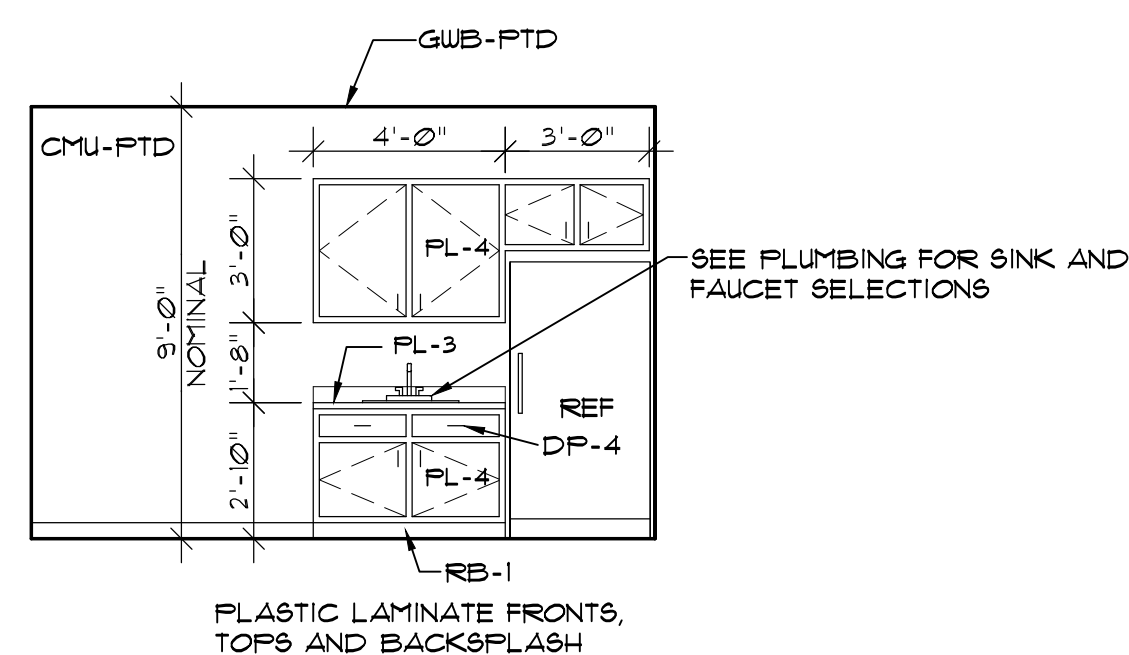

TECH BREAK 130
 INTERIOR ELEVATION
 SCALE: 1/4" = 1'-0"

NOTE:
SEE SCHEDULE SHEETS A3.7 & A3.8
FOR ADDITIONAL INFORMATION

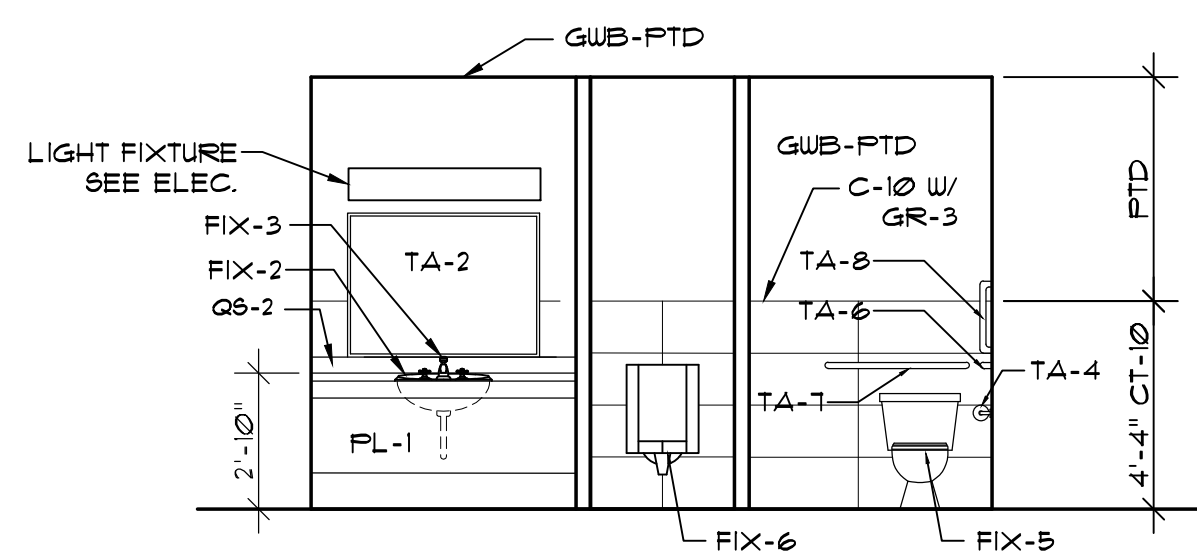

MEN 115
INTERIOR ELEVATION
SCALE: 1/4" = 1'-0"

TOILET ACCESSORY SCHEDULE				
Mark	Item		Mtg. Ht.	Remarks
TA-1	FRAMELESS MIRROR 2'W X 3'H (B-165 2436)		3'-4"	HEIGHT TO BOTTOM, CENTER ON SINK
TA-2	FRAMELESS MIRROR 4'W X 3'H (CUSTOM)		3'-4"	HEIGHT TO BOTTOM, CENTER ON SINK
TA-3	NOT USED			
TA-4	TOILET PAPER HOLDER	B-4288	1'-10"	HEIGHT TO CENTER OF BOTTOM ROLL
TA-5	BABY CHANGING STATION KOALA KARE	KB110-55RE	4'-0" MAX.	HEIGHT TO TOP
TA-6	GRAB BAR 42" CONCEALED MOUNTING W/ SNAP FLANGE		3'-0" MAX.	HEIGHT TO CENTER
TA-7	GRAB BAR 36" CONCEALED MOUNTING W/ SNAP FLANGE		3'-0" MAX.	HEIGHT TO CENTER
TA-8	GRAB BAR 18" CONCEALED MOUNTING W/ SNAP FLANGE (VERTICAL)		3'-3"	HEIGHT TO BOTTOM, CENTER OF BAR @ 40" FROM REAR WALL
TA-9	HANDICAP SOAP DISPENSER	B-5050	3'-6"	HEIGHT TO DISPENSER
TA-10	(FIX-4) HAND DRYER DYSON AB-14			MOUNTING HEIGHT PER MANUF. RECOMMENDATIONS
FIX-2	UNDERCOUNTER LAVATORY BY TOTO, LT191 (G) SANAGLOSS GLAZING COLOR: 101 COTTON			
FIX-3	GOOSENECK ECOPOWER FAUCET BY TOTO TEL195-D10ETEL195 - C20ET1CP COLOR/FINISH: 1CP POLISHED CHROME			
PL-1	PLASTIC LAMINATE- WILSONART SOLIDS- DESIGNER WHITE (D354-01) HIGH GLOSS FINISH			


NOTES:

- MODEL NUMBERS ARE BOBRICK ION, BRADLEY & FRANKLIN ARE APPROVED EQUALS. SUBMIT CUT SHEETS FOR APPROVAL.
- SUBMIT SHOP DRAWINGS FOR ALL TOILET PARTITION CONFIGURATIONS
- ALL HANDRAILS SHALL BE BLOCKED TO SUPPORT A 250 LB. LOAD MINIMUM


A. CT-2 IN RESTROOMS SHALL BE A MATTE FINISH.
ALL OTHER AREAS ARE TO BE POLISHED FINISH.

B. CT-12 RED ACCENT WALL IN RESTROOMS.
CT-12 IS TO BE INSTALLED IN RESTROOM WALL W
RESTROOM DOOR IS LOCATED.


SEE SHEETS A3.6, A3.7 AND A3.8 FOR MORE FINISH INFORMATION

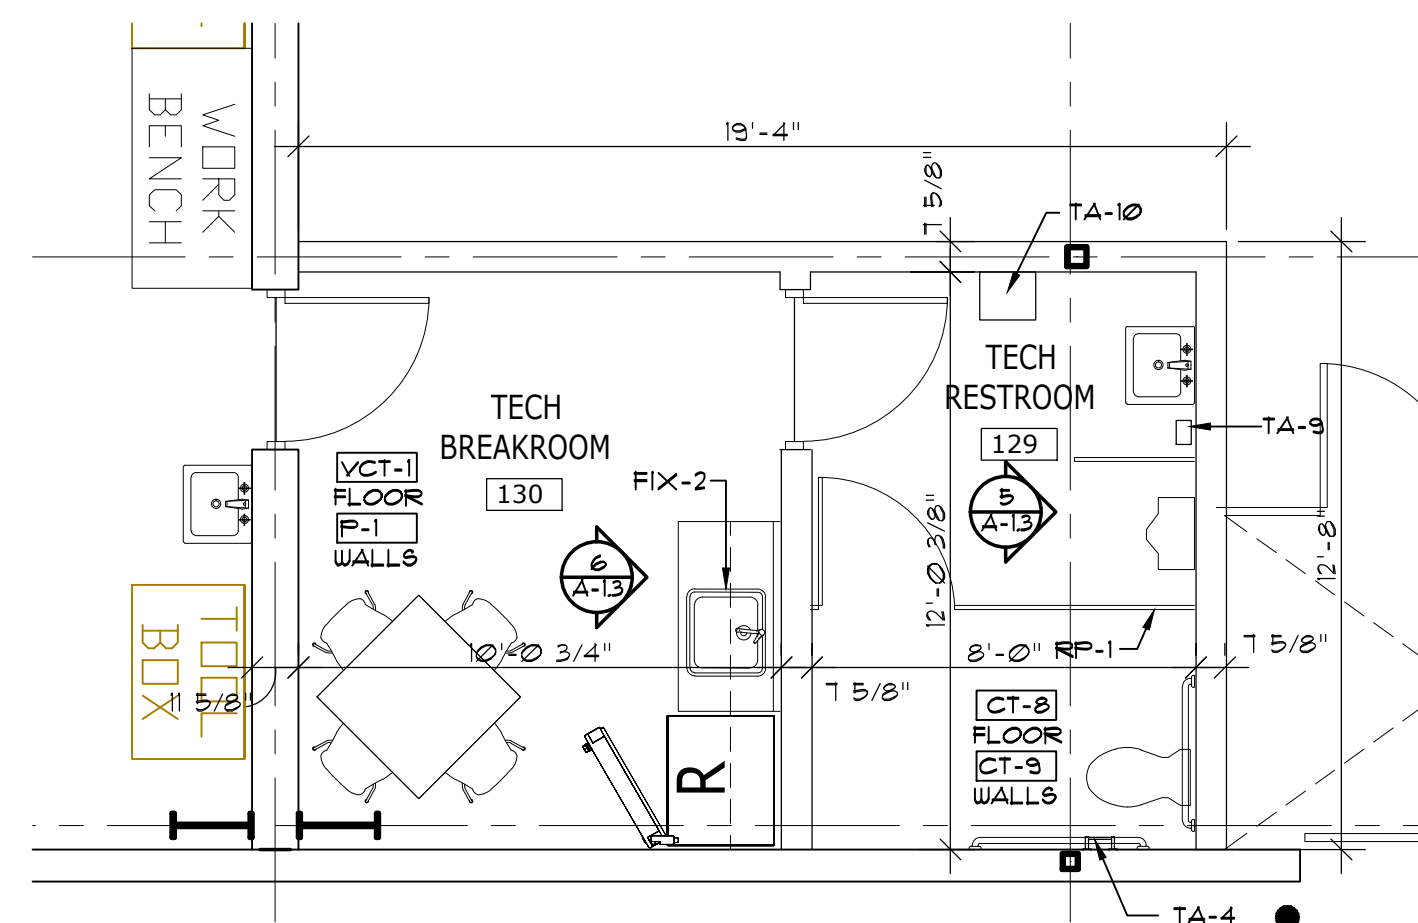

TECH BREAKROOM
TECH TOILET PLAN DETAIL
SCALE: 1/4" = 1'-0"

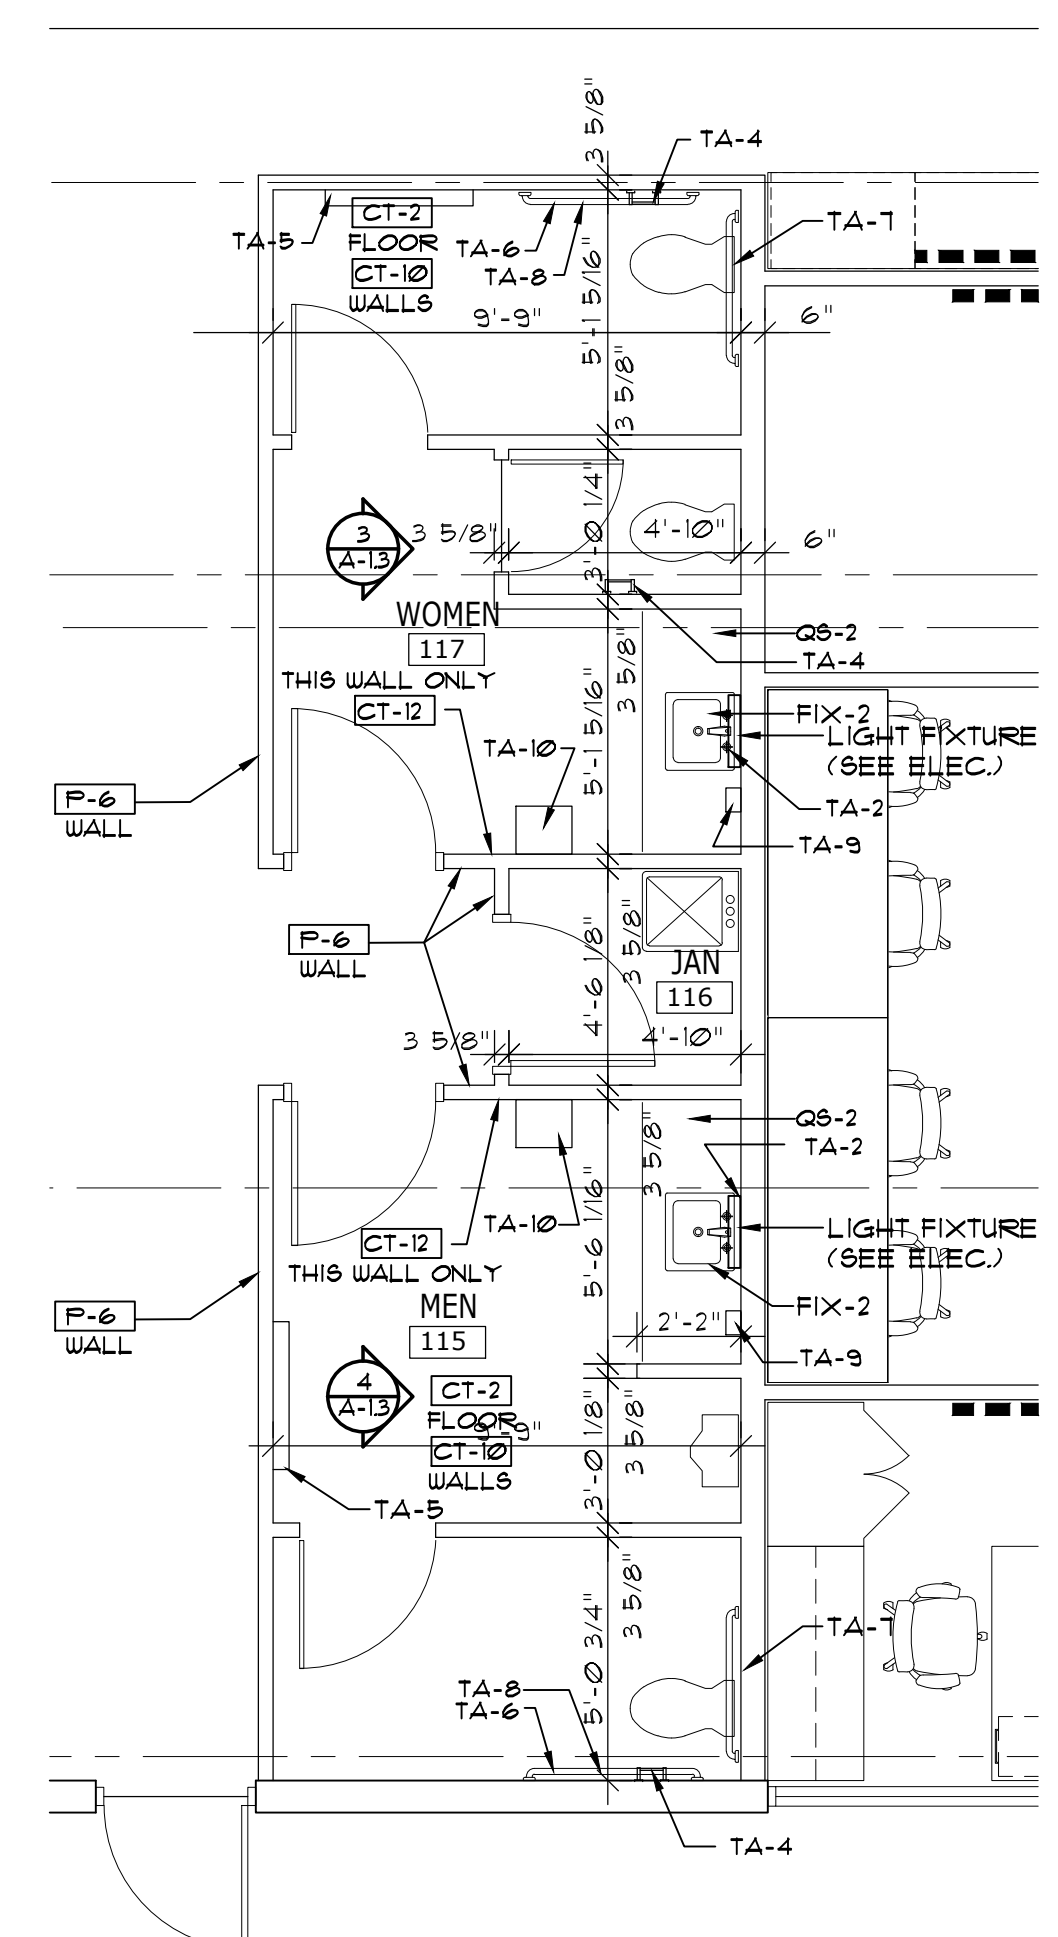

MEN 115 & WOMEN 117
TOILET PLAN DETAIL
SCALE: 1/4" = 1'-0"

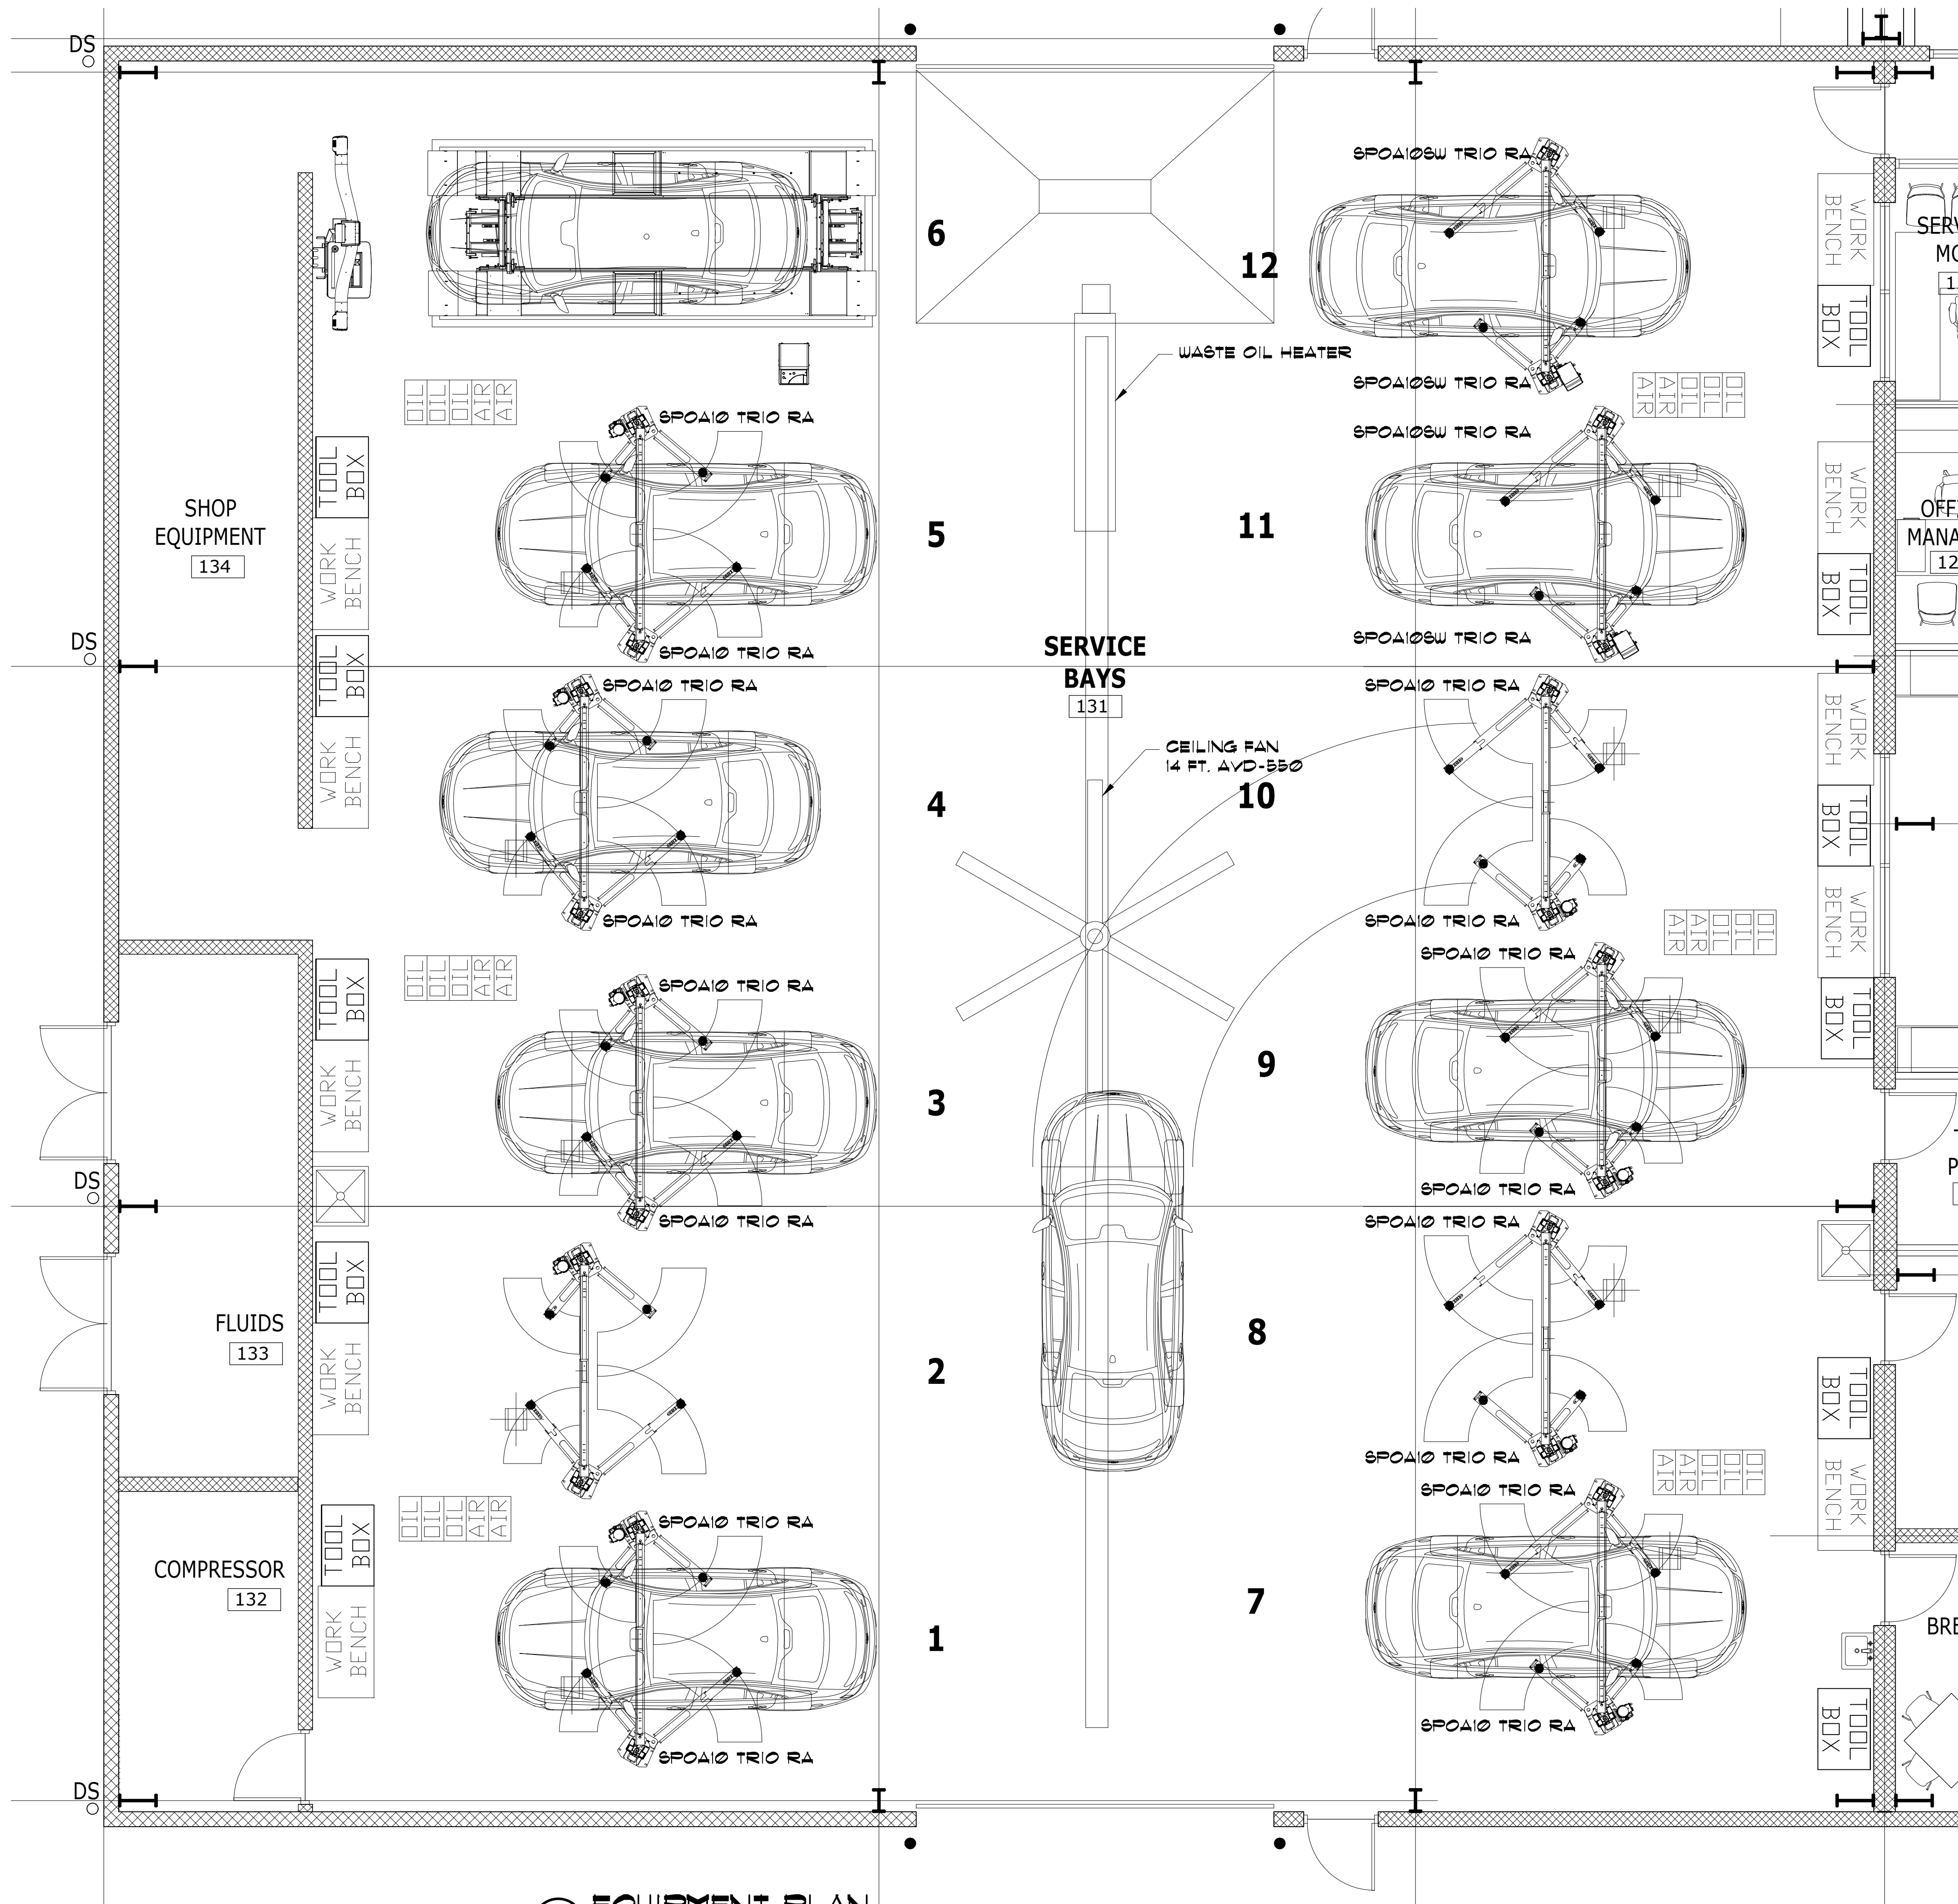


- CONSIDERATIONS:
- INSTALLATION MUST COMPLY WITH LOCAL CODES AND STANDARDS.
 - REFER TO MANUAL FOR CLEARANCE REQUIREMENTS.
 - EQUIPMENT PLACEMENT APPROXIMATED.
 - SPECIFY APPROPRIATE TOTAL DROP LENGTH (3-10 FT.) TO ACHIEVE DESIRED BLADE HEIGHT.
 - SPECIFY RAPID MOUNT INDUSTRIAL FAN MOUNTING HARDWARE TO AVOID GUY WIRE REQUIREMENT.
 - OFFSET KIT AVAILABLE FOR ROOF-PENETRATION LOCATION ADJUSTMENT.
 - PLEASE INSURE TOOL BOXES AND ADDITIONAL/APPLICABLE EQUIPMENT IS RED, UNLESS REGULATED BY OSHA STANDARDS.

ITEM	DESCRIPTION
WASTE OIL HEATER	350H MOUNTED FROM CEILING
CEILING FAN	AVD-550 14 FT. MOUNTED FROM CEILING
LIFT	SPOA10 TRIO RA 2 POST LIFT W/3 STANGE TRIO ARMS
LIFT	SPOA10SW TRIO RA 2 POST LIFT W/3 STANGE TRIO ARMS

ALL TOOL BOXES AND EQUIPMENT TO BE RED UNLESS REGULATED BY OSHA.

NOTE: EQUIPMENT PROVIDED BY OWNER

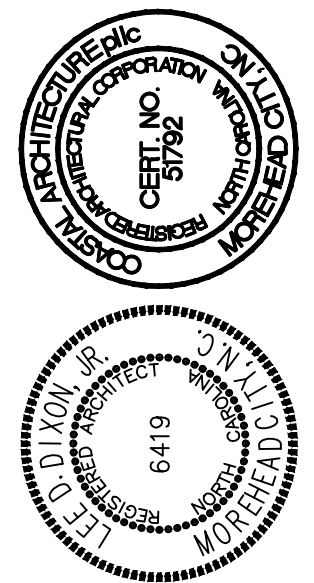


EQUIPMENT PLAN

16034

ISSUED: 20 NOV 18
DWG BY: BLS, LSA
CKD BY: LDD

REVISIONS



SHEET NO.
A-15
OF

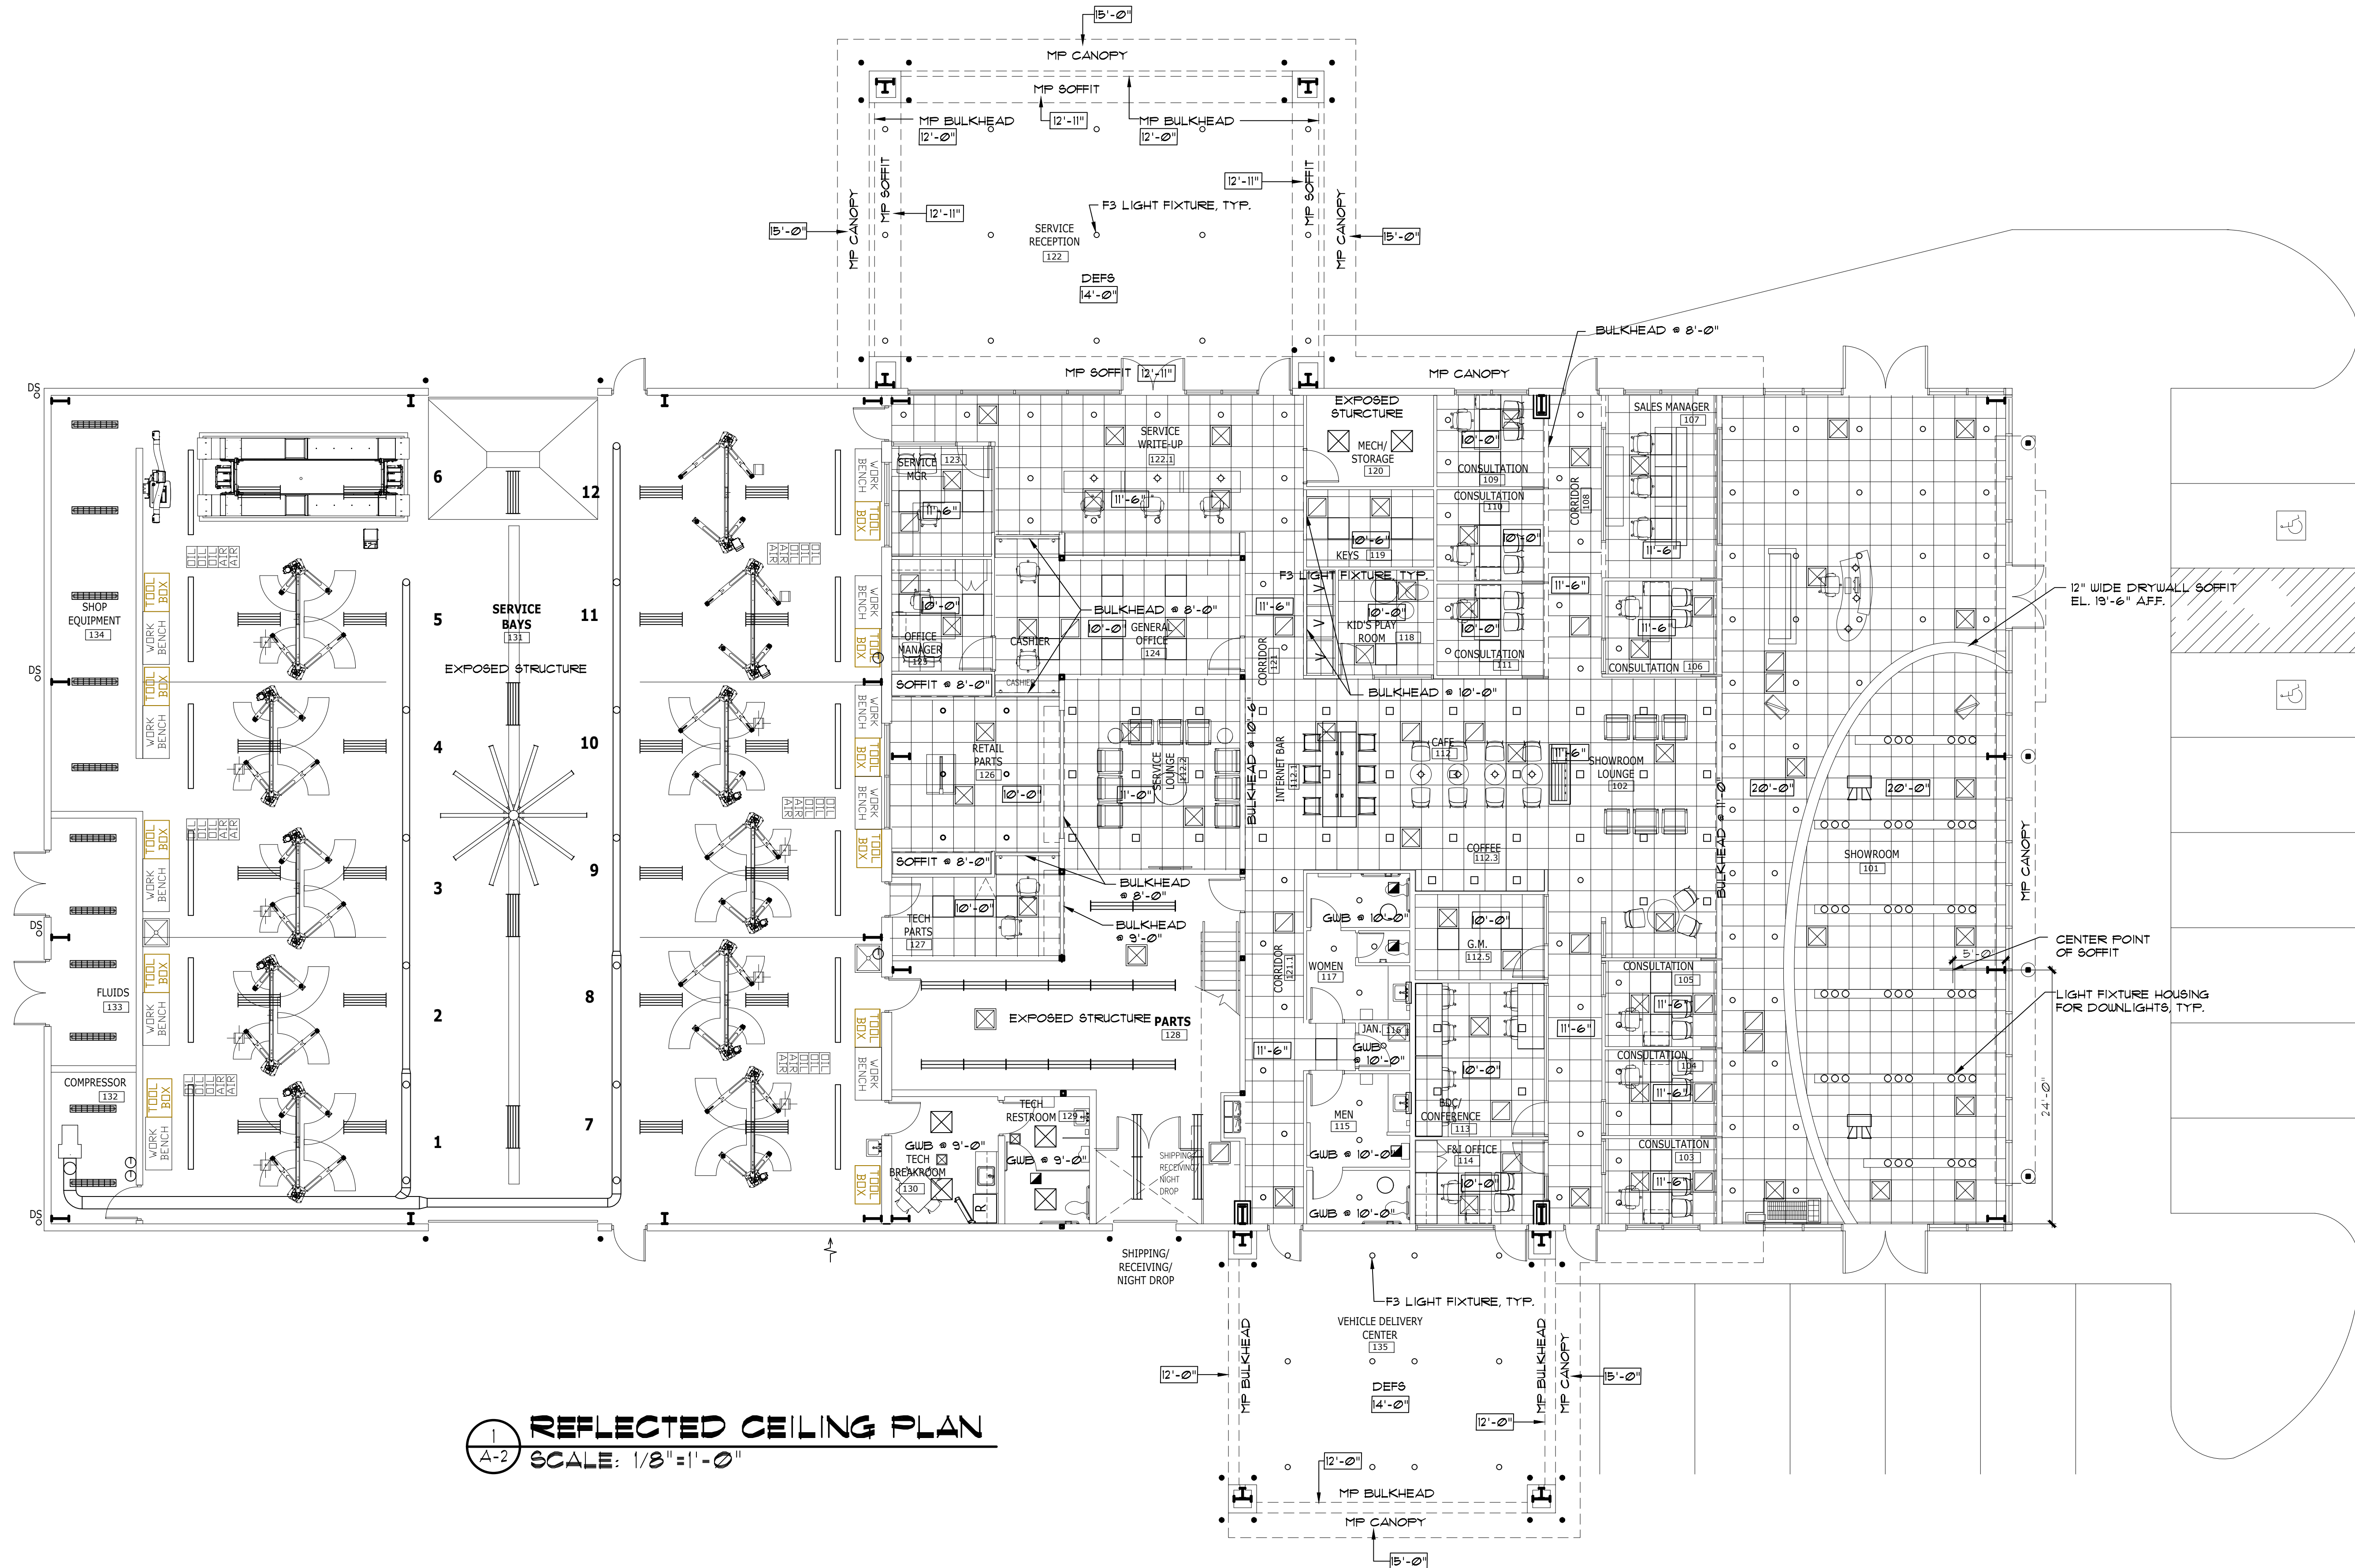


DOOR SCHEDULE							
DOOR NO	SIZE	DOOR		FRAME		REMARKS	
		MAT.	TYPE	MAT.	TYPE		
101A	(2)3'-0" X 7'-0"	ALUM.	A	ALUM.	W-1	SEE CODE D1, DP-2	SEE A3.1 FOR ELEVATION
101B	(2)4'-0" X 8'-0"	ALUM.	B	ALUM.	W-3	SEE CODE D1	SEE A3.1 FOR ELEVATION
101C	(2)4'-0" X 8'-0"	ALUM.	B	ALUM.	W-2	SEE CODE D1	SEE A3.1 FOR ELEVATION
108A	3'-0" X 7'-0"	ALUM.	A	ALUM.	W-9	SEE CODE D4	SEE A3.1 FOR ELEVATION
108B	3'-0" X 7'-0"	ALUM.	A	ALUM.	W-9	SEE CODE D4	SEE A3.1 FOR ELEVATION
112.5A	3'-0" X 7'-0"	ALUM.	A	ALUM.	W-21		SEE A3.2 FOR ELEVATION
113A	3'-0" X 7'-0"	ALUM.	A	ALUM.	W-14		SEE A3.2 FOR ELEVATION
114A	3'-0" X 7'-0"	ALUM.	A	ALUM.	W-8		SEE A3.1 FOR ELEVATION
114B	3'-0" X 7'-0"	ALUM.	A	ALUM.	W-13		SEE A3.2 FOR ELEVATION
115A	3'-0" X 7'-0"	HPDL	F	H.M.	1	CLOSER SEE CODE D1	
115B	3'-0" X 7'-0"	HPDL	F	H.M.	1	CLOSER SEE CODE D1	
116A	3'-0" X 7'-0"	HPDL	F	H.M.	1	SEE CODE D1	
117A	3'-0" X 7'-0"	HPDL	F	H.M.	1	CLOSER SEE CODE D1	
117B	3'-0" X 7'-0"	HPDL	F	H.M.	1	CLOSER SEE CODE D1	
118A	3'-0" X 7'-0"	ALUM.	A	ALUM.	W-15		SEE A3.2 FOR ELEVATION
120	3'-0" X 7'-0"	HPDL	F	H.M.	1	SEE CODE D1	
121.1A	3'-0" X 7'-0"	FG.	J	FG.	5	SEE CODE D6	
122.1A	3'-0" X 7'-0"	ALUM.	A	ALUM.	W-6	SEE CODE D4	SEE A3.1 FOR ELEVATION
122.1B	6'-0" X 8'-0"	ALUM.	L	ALUM.	W-6	SEE CODE D1	SEE A3.1 FOR ELEVATION
123A	3'-0" X 7'-0"	ALUM.	A	ALUM.	W-17		SEE A3.2 FOR ELEVATION
124A	3'-0" X 7'-0"	HPDL	F	H.M.	1	SEE CODE D1	
125A	3'-0" X 7'-0"	HPDL	F	H.M.	1	SEE CODE D1	
127A	3'-0" X 7'-0"	H.M.	H	H.M.	4	CLOSER 3 HR RATED	
128A	6'-0" X 10'-0"	-	E	-		ROLLING DOOR SEE CODE D3	
128B	3'-0" X 7'-0"	H.M.	H	H.M.	4	CLOSER 3 HR RATED	
128C	3'-0" X 7'-0"	H.M.	H	H.M.	4	CLOSER 2 HR RATED	
128D	7'-8" X 9'-0" VERIFY	-	K	-	-	FIRE SHUTTER- 90 MIN. RATED	
129A	3'-0" X 7'-0"	HPDL	F	H.M.	2	CLOSER SEE CODE D1	
130A	3'-0" X 7'-0"	H.M.	H	H.M.	4	CLOSER 3 HR RATED	
131A	16'-0" X 10'-0"	-	D	-		SEE CODE D5	
131B	16'-0" X 10'-0"	-	D	-		SEE CODE D5	
131C	3'-0" X 7'-0"	FG.	J	FG.	5	CLOSER SEE CODE D6	
131D	3'-0" X 7'-0"	FG.	J	FG.	5	CLOSER SEE CODE D6	
131E	3'-0" X 7'-0"	H.M.	H	H.M.	4	CLOSER 3 HR RATED	
132A	3'-0" X 7'-0"	H.M.	G	H.M.	2		
133A	(2)3'-0" X 7'-0"	FG.	C	FG.	3	CLOSER	
133B	(2)3'-0" X 7'-0"	FG.	C	FG.	3	CLOSER	

CODE	MATERIAL	MANUFACTURER	DESCRIPTION			LOCATION	ADDITIONAL INFORMATION
			PRODUCT	COLOR	DIMENSION		
D-1	MAN DOOR/ VEHICLE DOOR	PITCO ARCHITECTURAL METALS, INC. OR EQUAL	STANDARD NARROW STILE CENTER HUNG DOOR	#63 BLACK FINISH GLASS & ALUMINUM	PAIR 3070-MAIN ENTRY; PAIR 4070-VEHICLE ACCESS (8' OPENING)	SHOWROOM	CONTACT: PITCO ARCHITECTURAL METALS (800) 992-7488
D-2	NOT USED						
D-3	ROLLING OVERHEAD PARTS RECEIVING DOOR 591 SERIES	OVERHEAD DOOR COMPANY		NO GLAZING PAINT: SEE EP-1 ON A-3.13 BENJAMIN MOORE, EXTERIOR RM CHARCOAL SLATE		PARTS RECEIVING	
D-4	MAN DOOR	PITCO ARCHITECTURAL METALS, INC. OR EQUAL	STANDARD NARROW STILE CENTER HUNG DOOR	#63 BLACK FINISH GLASS & ALUMINUM	3070	SHOWROOM	CONTACT: PITCO ARCHITECTURAL METALS (800) 992-7488
D-5	ROLLING OVERHEAD DOOR 591 SERIES	OVERHEAD DOOR COMPANY		PROVIDE SINGLE BAND OF GLASS PAINT TO MATCH	SEE DRAWING FOR SIZE	SERVICE BAYS	
D-6	SOLID MAN DOOR	SEE SPECIFICATION 08100		PAINT: BENJAMIN MOORE, EXTERIOR RM CHARCOAL SLATE - SEE EP-1 ON A-3.13			
DP-2	DOOR PULL ASSEMBLY	TRIMCO HARDWARE	KIA CAST DOOR PULL	BRUSHED ALUMINUM	PAIR 3070-MAIN ENTRY	PRIMARY ENTRY DOORS	DP-2 CUSTOM KIA LOGO DOOR HANGLES AT MAIN ENTRY DOORS PLEASE CONTACT TRIMCO IF ELECT TO PURCHASE HANDLES JASON BENNETT - O (323)-262-4191 / C (949)-702-3526 jbennett@trimcohardware.com www.trimcohardware.com

CODE	MATERIAL	MANUFACTURER	DESCRIPTION			LOCATION	ADDITIONAL INFORMATION
			PRODUCT	COLOR	DIMENSION		
D-7	INTERIOR DOOR	VT INDUSTRIES ARCHITECTURAL WOOD DOORS OR APPROVED EQUAL	404 VT DOOR TYPE, PC-HPDL- 5 HIGH PRESSURE DECORATIVE LAMINATE BONDED PARTICLE BOARD CORE 5-PLY CONSTRUCTION, NON-RATED OR 20 MIN. FINISH: PLASTIC LAMINATE, D354-60 DESIGNER WHITE, MATTE FINISH			GENERAL SHOWROOM	***NOTE: RATING AS REQUIRED NOTE: DOOR FRAME FINISH TO BE CLEAR ANODIZED

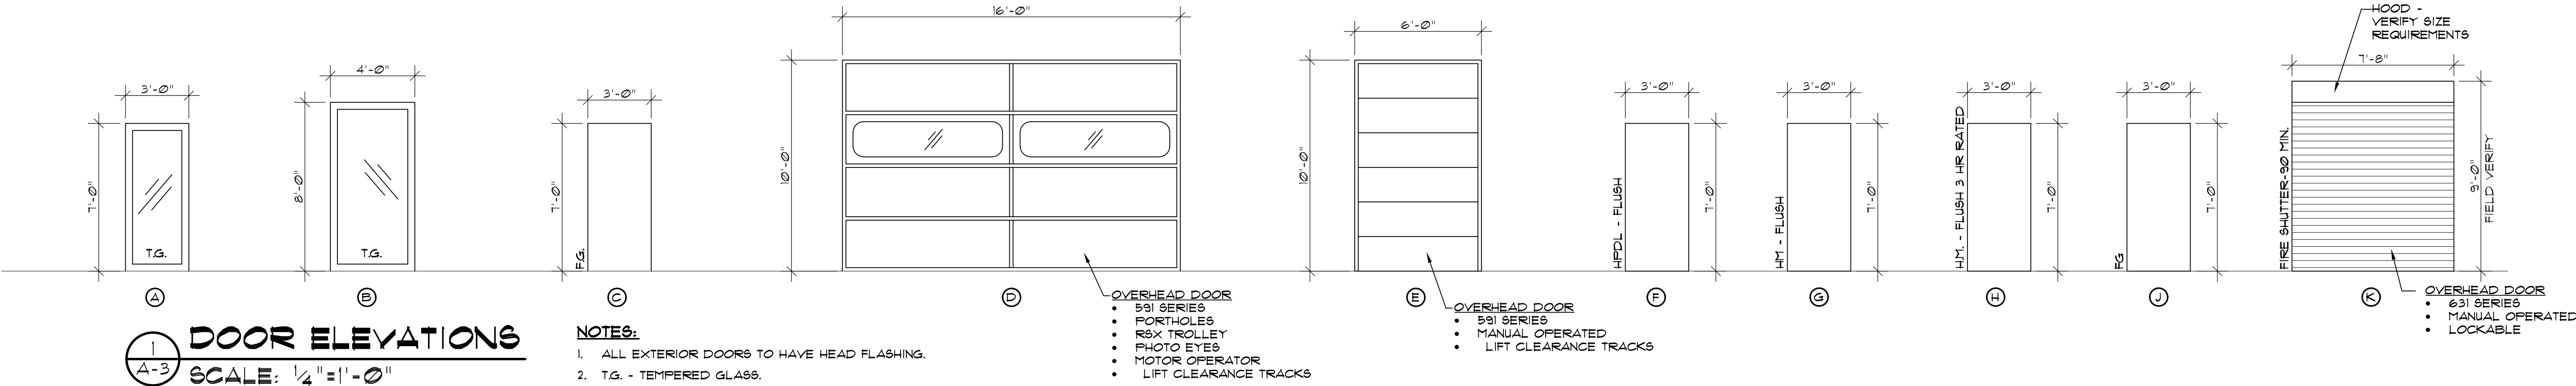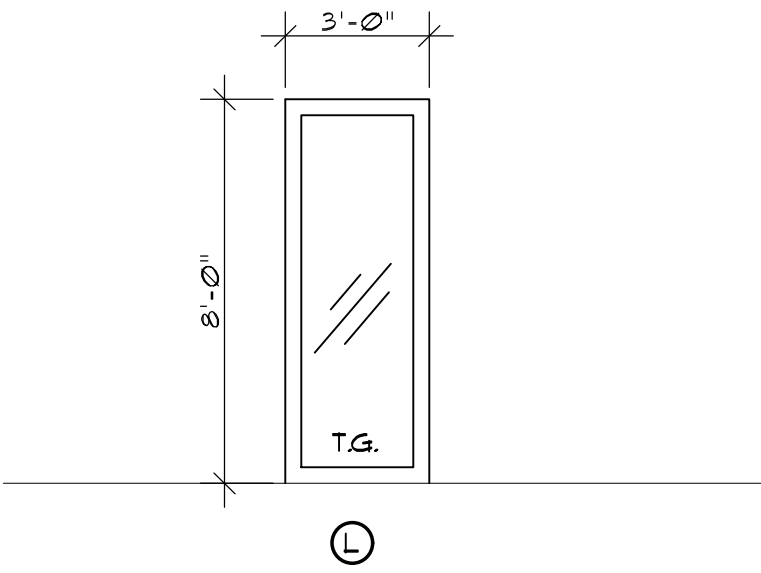

1 DOOR ELEVATIONS
SCALE: 1/4" = 1'-0"

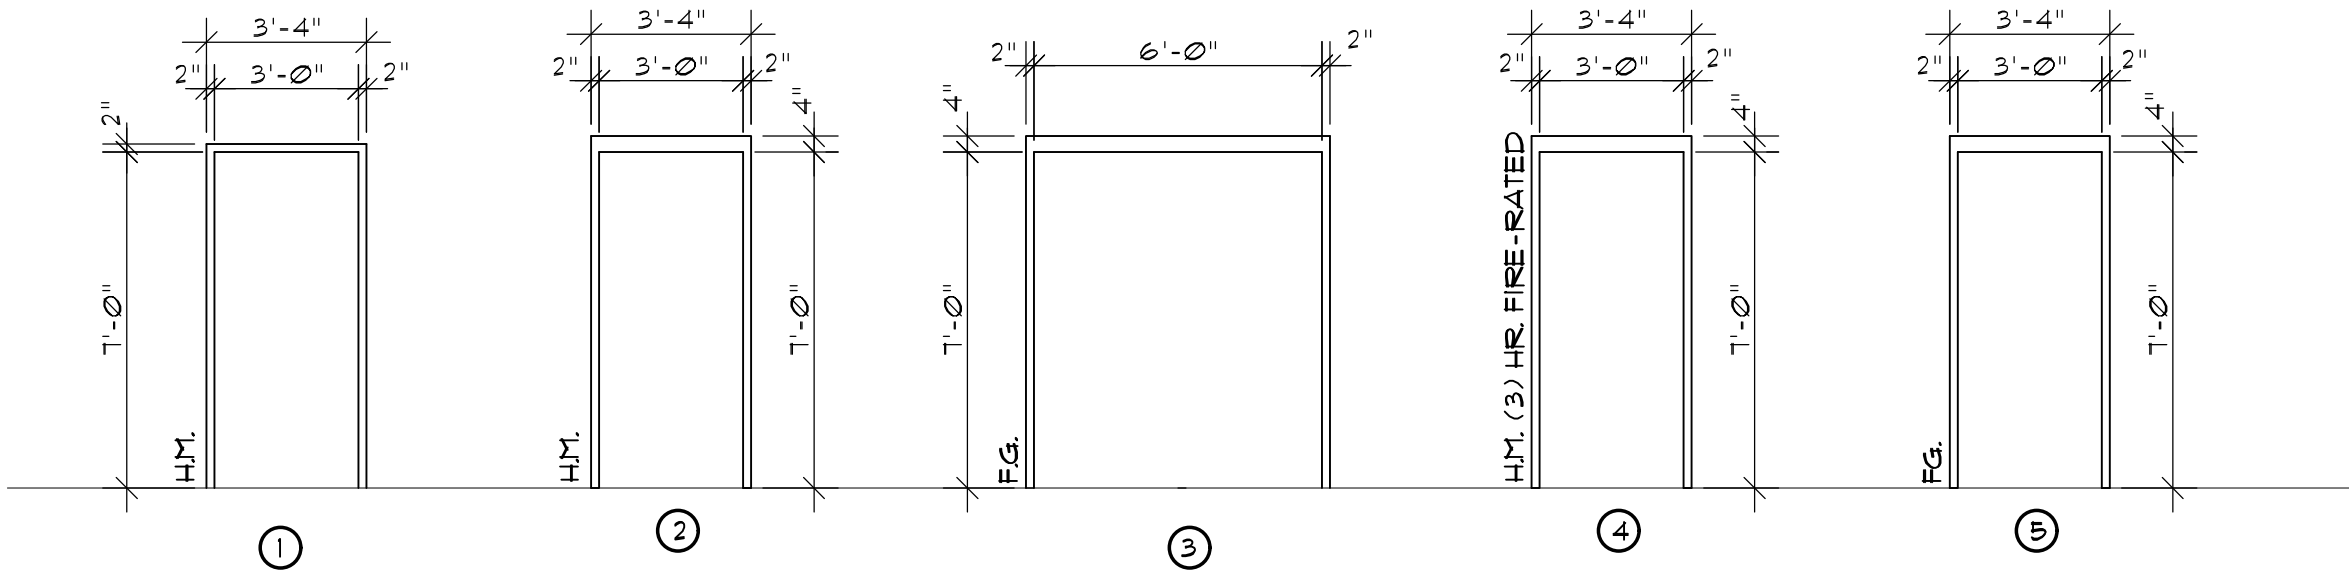

2 FRAME ELEVATIONS
SCALE: 1/4" = 1'-0"


Coastal
Architecture
• Architectural Design
• Planning
• Interiors

AIA
Member of the American Institute of Architects

Lee D. Dixon, Jr., AIA
252-247-2127
lee@coastalarchitecture.net

4206 Bridges St. Ext., Suite C
Morehead City, NC 28557
www.CoastalArchitecture.net

NC074 KIA OF NEW BERN
NEW BERN, NORTH CAROLINA

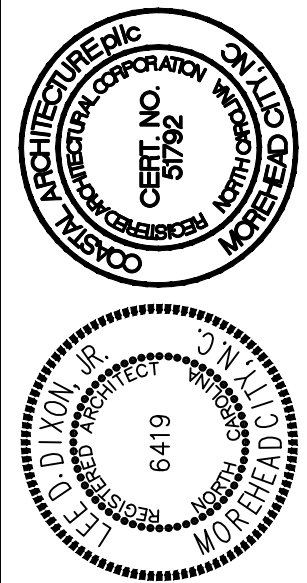

DOOR AND FRAME ELEVATIONS

16034

ISSUED: 20 NOV 18

DWG BY: BLS, LSA

CKD BY: LDD

REVISIONS

SHEET NO.

A-3

OF

GENERAL NOTES

A. ALL GRAPHICS AND WALL PANELS MAY REQUIRE BLOCKING OR OTHER POSITIVE FORM OF ANCHORAGE. COORDINATE WITH THE GRAPHICS VENDOR EWI PRIOR TO CLOSING ANY WALL CAVITIES.

LEGEND

#	NOTE DESIGNATOR - REFER TO DRAWING NOTE ON FURNITURE PLAN
F-#	FURNITURE ITEM - REFER TO FURNITURE PLAN FOR LOCATION AND SHEET A-3.14 FOR SPECIFICATIONS
FN-#	FURNITURE ITEM - REFER TO FURNITURE PLAN FOR LOCATION AND SHEETS A-3.9 THRU A-3.12 FOR SPECIFICATIONS
?-#	FINISH DESIGNATOR - REFER TO INTERIOR FINISH SPECIFICATIONS ON SHEETS A-3.6 THRU A-3.8
EG-X G-X	GRAPHICS DESIGNATOR - GRAPHICS BY OTHERS, EXTERIOR SIGNAGE TO BE PROVIDED EXCLUSIVELY BY PATTISON SIGN GROUP. CONTACT ED MACKLE (865-693-1105 EXT. 132) TO COORDINATE GALLERY BRANDING ELEMENT SCOPE AND DETAILS- SEE A-3.14
-----	GRAPHICS SYMBOL AND APPROX LOCATION. GRAPHICS BY EWI CONTACT: Eileen Dyer 414.277.6327 EDyer@ewiworldwide.com

SUBMIT COMPLETE FURNITURE PACKAGE, MILLWORK SHOP DRAWINGS & SUBMITTAL TO INTERBRAND FOR REVIEW PRIOR TO PURCHASING.

PROGRAM'S PREFERRED NATIONAL LIGHTING DISTRIBUTOR FOR THE IMAGE FACILITIES PROGRAM. PLEASE CONTACT FARREN HALCOVICH AT CL1-760-831-9815 - farren@commercial-lighting.net

DRAWING NOTES

- OFFICE FURNISHING LAYOUT BY OWNER. ITEMS CAN BE SELECTED FROM SPECIFIED FURNITURE SYSTEM. REFER TO FURNITURE SCHEDULE ON SHEET A-3.9 THRU A-3.12.
- STORAGE UNITS LAYOUT AND QUANTITY BY OWNER.
- LINE OF SOFFIT ABOVE.
- LINE OF CANOPY ABOVE.
- REFER TO FURNITURE LAYOUT PLAN ON SHEET A-3.4 DESK SIZES MAY VARY.
- ROLL - UP SECURITY GRILLE.
- FIRE RATED WALL - FIRE SHUTTERS OR FIRE RATED WINDOW WALL MAY BE REQUIRED.
- SERVICE BAY LIFT AND ALIGNMENT RACK LAYOUTS BY OWNER. ALL LIFTS TO BE FACTORY RED.
- SECURITY FENCE/ GATE.
- LINE OF MEZZANINE.
- VENDING MACHINE BY OWNER.
- NEW F1 LIGHT FIXTURES. SEE SHEET A-3.15 FOR ADDITIONAL INFORMATION.
- PARTS OVERHEAD DOOR.
- MEZZANINE PARTS STORAGE OR THE USE OF HIGH DENSITY SHALL BE REQUIRED TO COMPLY WITH DEALERS MINIMUM REQUIREMENTS.
- VEHICLE LOCATION - MAINTAIN LOCATION.
- COUNTERTOP; SEE 5/A-8 FOR DETAILS.
- FLOOR FINISH TRANSITION. SEE SHEET A-3.8
- MOP SINK.
- DEFINES SERVICE STALL AREA.
- INSTALL (3) F12 PENDANT LIGHTS ABOVE RECEPTION DESK.
- RETAIL DISPLAY SOFFIT BY G.C. PTD P7
- SEE A-1.3 FOR FINISHES.
- ADD FILM GF-1 TO LOWER 2/3RDS OF SALES CONSULT REAR WINDOWS, TYP.
- SUGGESTED STRUCTURAL COLUMN LAYOUT. ALL LAYOUTS TO BE CERTIFIED BY A LICENSED PROFESSIONAL.
- 8'-HIGH MASONRY BLOCK WALL.
- W-11 & W-11A ARE TO RECEIVE VISUAL SAFETY FILM.

Coastal
Architecture
P.A.

• Architectural
Design
• Planning
• Interiors





Member of the American
Institute of Architects

Lee D. Dixon, Jr., AIA
252-247-2121
lee@coastalarchitecture.net

4206 Bridges St. Ext.,
Suite C
Morehead City, NC
28557

www.CoastalArchitecture.net

NC074 KIA OF NEW BERN
NEW BERN, NORTH CAROLINA

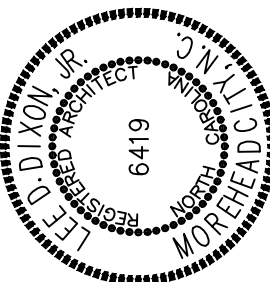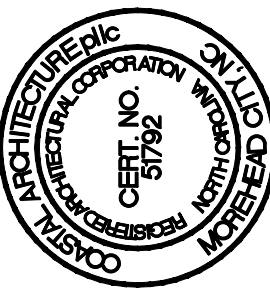

FURNITURE - FINISH
PLAN

16034

ISSUED: 20 NOV 18

DWG BY: BLS, LSA


CKD BY: LDD

REVISIONS

SHEET NO.



A-3.3

OF

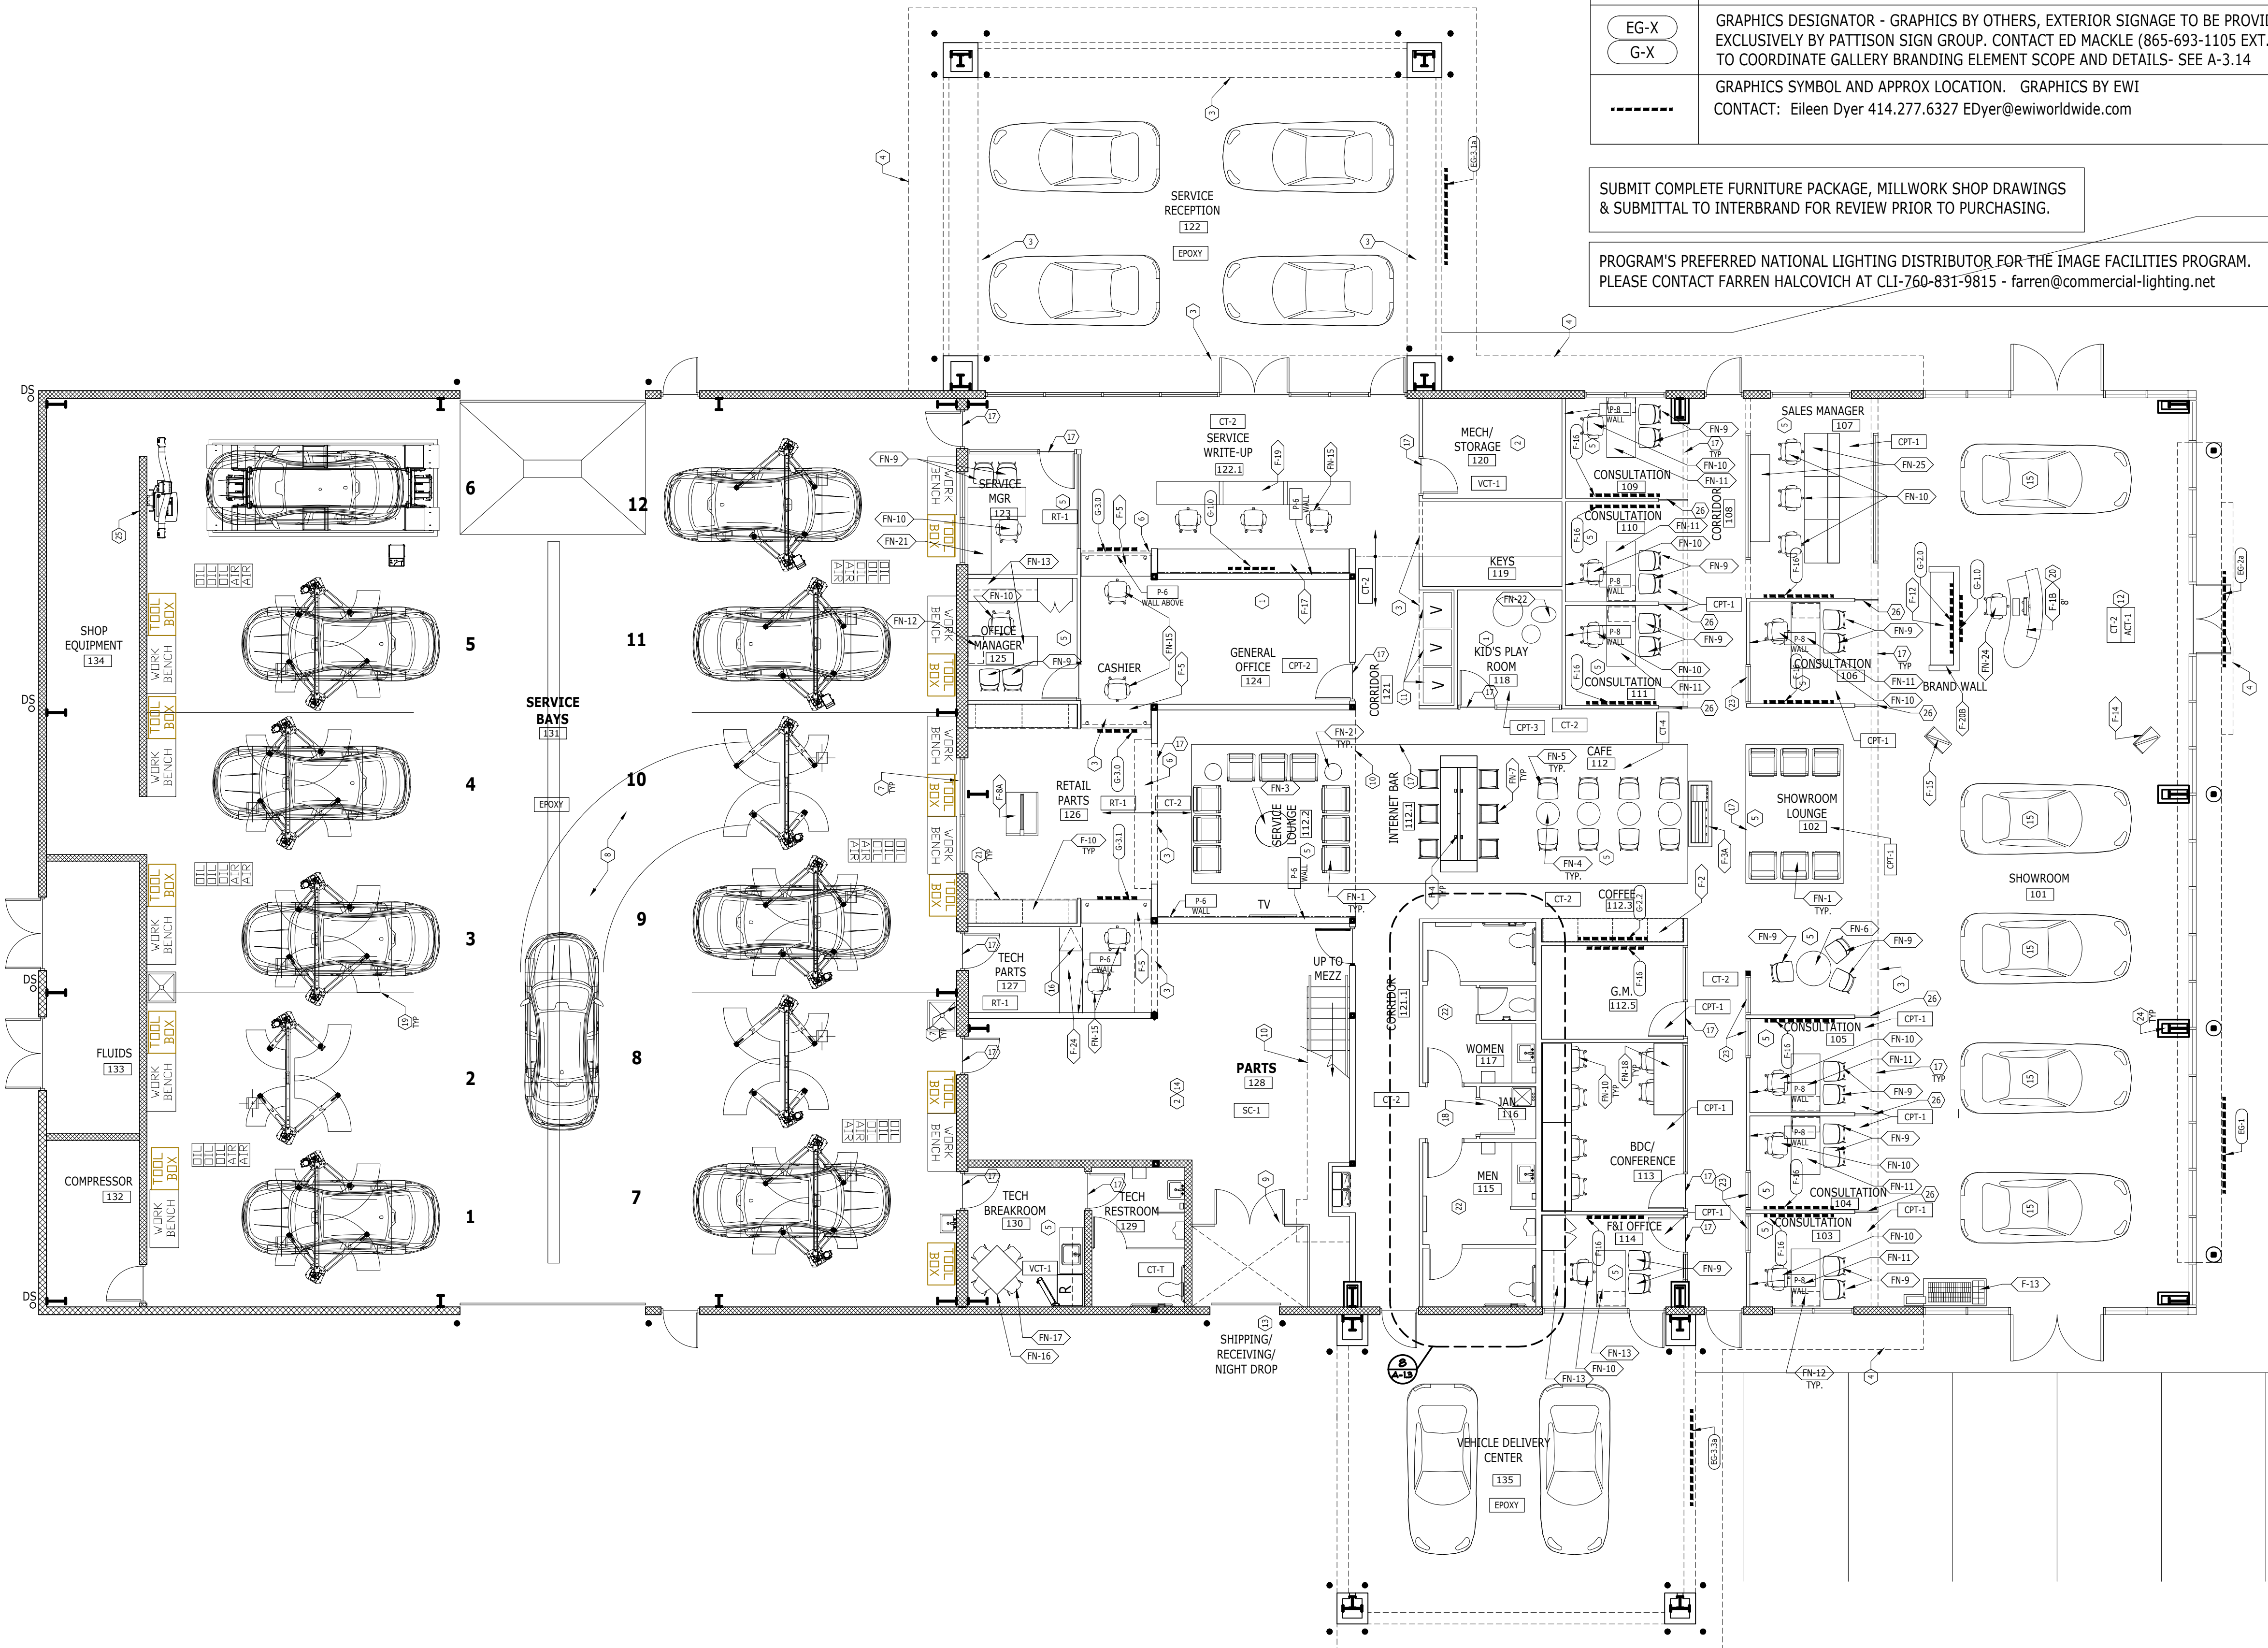

FURNITURE - FINISH PLAN
A-3.3 SCALE: 1/8"=1'-0"

THESE DRAWING AND SPECIFICATIONS REPRESENT AN INSTRUMENT OF SERVICE AND AS SUCH SHALL REMAIN IN OWNERSHIP WITH THE ARCHITECT. USE OR REPRODUCTION BY ANY MEANS, IN WHOLE OR IN PART, WITHOUT THE ARCHITECT'S WRITTEN CONSENT, IS PROHIBITED.

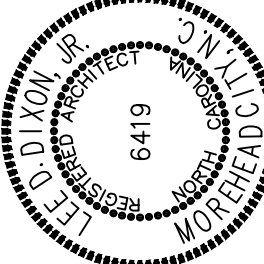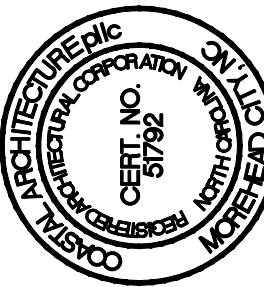

FURNITURE LAYOUT
LEGEND

16034

ISSUED: 20 NOV 18

DWG BY: BLS

CKD BY: LDD

REVISIONS


SHEET NO.

A-3.4
OF

LEGEND	
#	NOTE DESIGNATOR - REFER TO DRAWING NOTES ON THIS SHEET
FN-#	FURNITURE ITEM - REFER TO A-3.9 THRU A-3.12

DRAWING NOTES

- SIZES VARY. SEE FURNITURE SCHEDULE FOR ADDITIONAL INFORMATION.
NOTE: OWNER & FURNITURE DEALER TO PROVIDE/COORDINATE FURNITURE DIMENSIONS APPROPRIATE TO AUTO DEALER SIZE & VOLUME. ALL OWNER PROGRAMMING NEEDS ARE TO BE CONSIDERED. OWNER TO COORDINATE DESKING REQUIREMENTS (LIGHTING, HARDWARE, CORD & CABLE MANAGEMENT, WALL STRIP ATTACHMENTS, ACCESSORIES & STORAGE ETC.) WITH FURNITURE DEALER FOR EXACT SPECIFICATIONS & SITE SPECIFIC REQUIREMENTS.
NOTE: ADDITIONAL OFFICE COMPONENTS (STORAGE, FILING, ETC.) & OPTIONAL FEATURES FOR REQUIRED SEATING (PNEUMATIC, TILT MECHANISM, ARM PAD, ETC.) COULD BE ADDED FOLLOWING THE RECOMMENDED MANUFACTURER/ PRODUCT GUIDELINES LISTED IN THE SCHEDULE. AUTO DEALER TO COORDINATE THESE ADDITIONAL NEEDS WITH THEIR LOCAL FURNITURE DEALER.


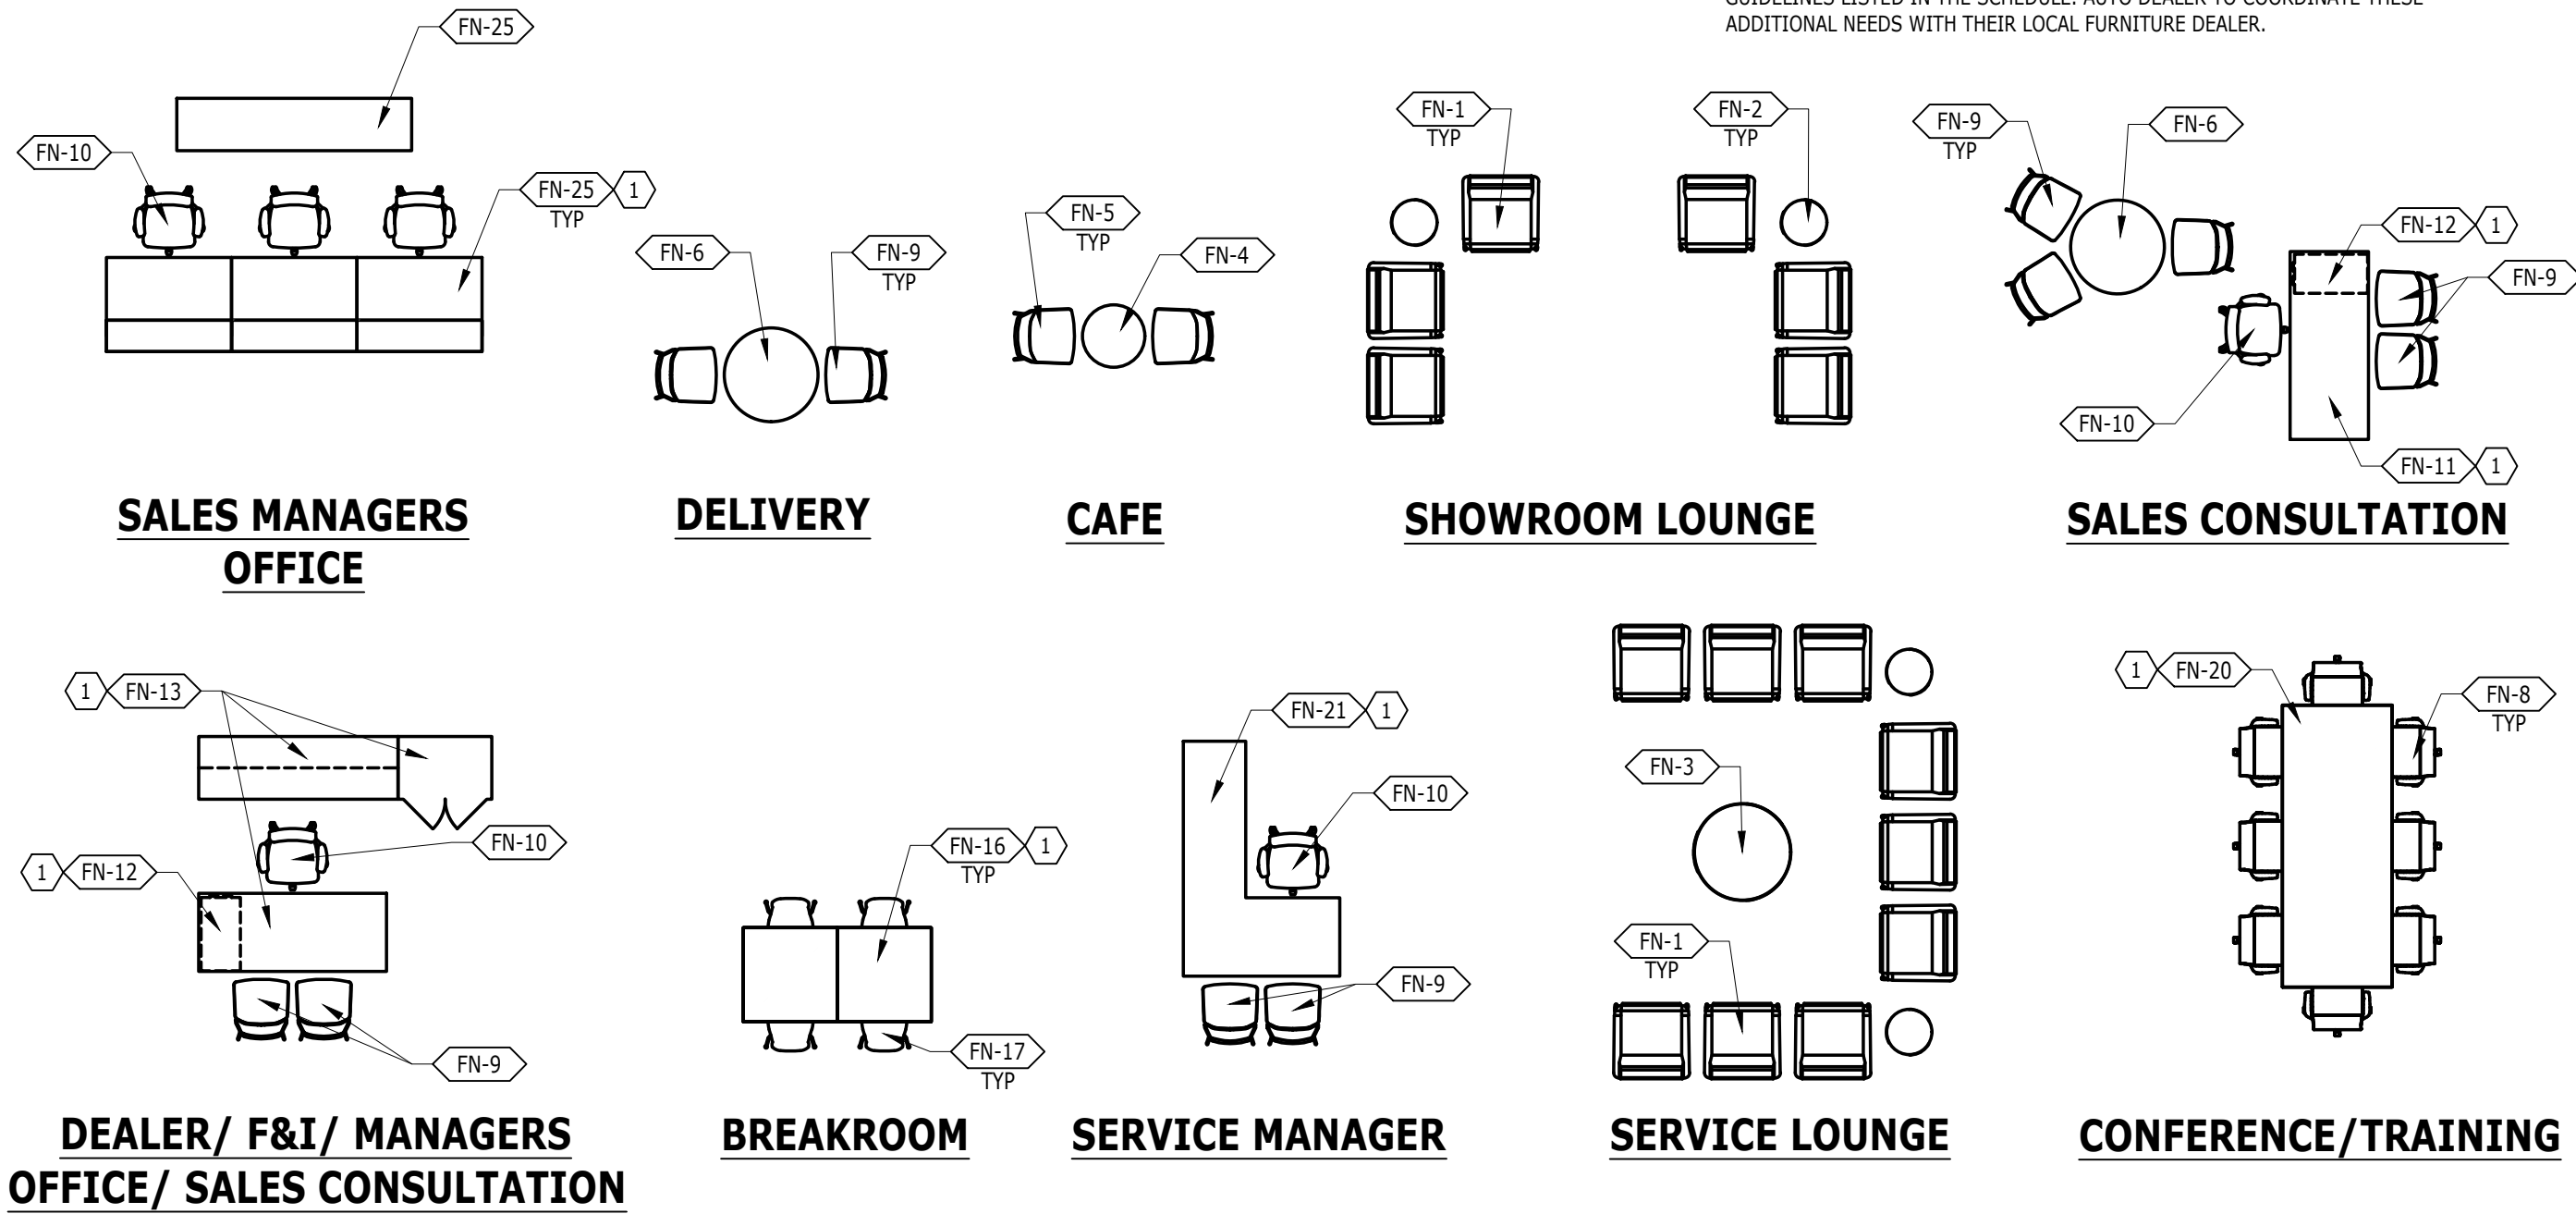


FURNITURE LAYOUT SCALE: NONE

SUBMIT COMPLETE FURNITURE PACKAGE, MILLWORK SHOP DRAWINGS
& SUBMITTAL TO INTERBRAND FOR REVIEW PRIOR TO PURCHASING.

PROGRAM'S PREFERRED NATIONAL LIGHTING DISTRIBUTOR FOR THE IMAGE FACILITIES PROGRAM.
PLEASE CONTACT FARREN HALCOVICH AT CLI-760-831-9815 - farren@commercial-lighting.net

NOTE: ALL FURNITURE TO BE PROVIDED BY OWNER UNLESS OTHERWISE NOTED

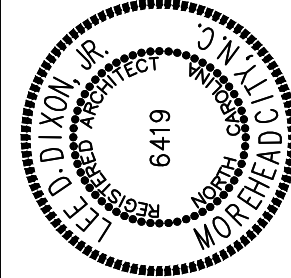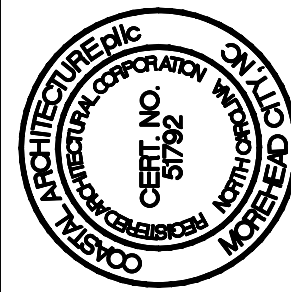

INTERIOR FINISH
INFORMATION

16034

ISSUED: 20 NOV 18

DWG BY: BLS, LSA

CKD BY: LDD

REVISIONS

SHEET NO.


A-3.5
OF

DRAWING NOTES

1. NOT USED
2. NOT USED
3. VERTICAL ASHLAR CARPET INSTALLATION IN CUSTOMER CONTACT AREAS.
4. NOT USED
5. NOT USED
6. STACKED BOND INSTALLATION REQUIRED FOR ALL LARGE FORMAT WALL TILES.
7. REFER TO TCNA HANDBOOK & ANSI REQUIREMENTS FOR PROPER INSTALLATION METHODS FOR LARGE FORMAT CERAMIC TILE WALL TILE. REFER TO ANSI A108.02 SECTION 4.3.7 REGARDING LIPPAGE & SECTION 4.3.8 REGARDING GROUT JOINT SIZE, PARTICULARLY IN RELATION TO THE TILE SIZE, DIMENSIONAL PRECISION & OFF-SET PATTERN.
8. REQUIRED: TO ACHIEVE PROPER INSTALLATION FOR LARGER FORMAT WALL TILES, CONTRACTOR TO USE THE TUSCAN LEVELING SYSTEM OR EQUAL & DOUBLE SPREADING TECHNIQUE (BACK-BUTTERING). REFER TO THINSET MANUFACTURES TECHNICAL DATA SHEET FOR RECOMMENDED TROWEL SIZE & COVERAGE INFORMATION.

LEGEND


#	NOTE DESIGNATOR - REFER TO DRAWING NOTES ON THIS SHEET
?-#	FINISH DESIGNATOR - REFER TO SCHEDULES ON A-3 SERIES SHEETS

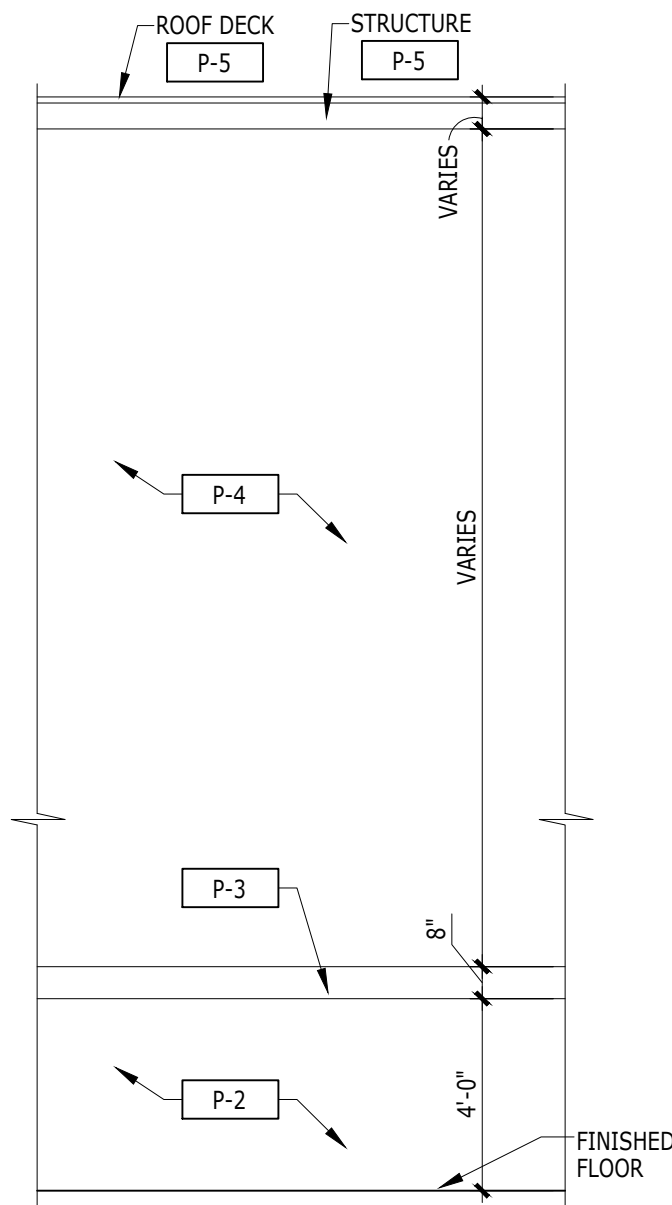

SERVICE BAY
WALL ELEVATION


1
A-3.5
1/4" = 1'-0"

2
A-3.5
NOT USED

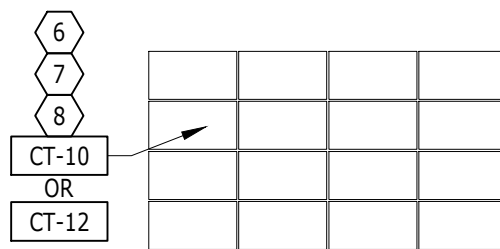

RESTROOMS - STACKED
BOND WALL TILE PATTERN

3
A-3.5
1/4" = 1'-0"

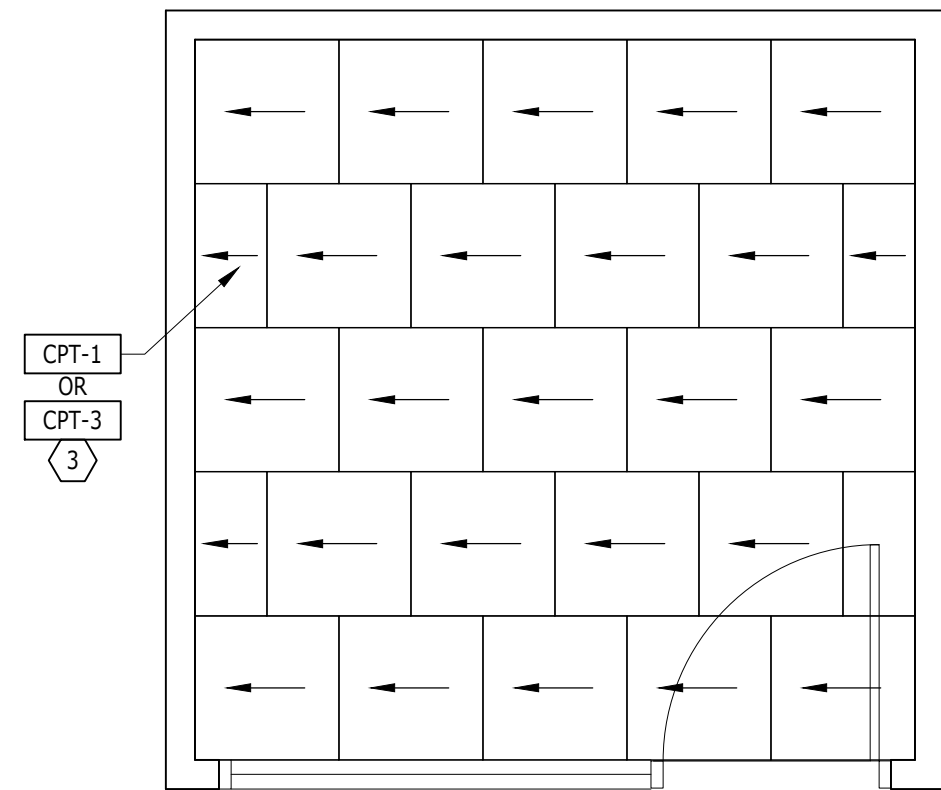

CONSULTATION/OFFICE
VERTICAL ASHLAR PATTERN

4
A-3.5
3/8" = 1'-0"





Member of the American
Institute of Architects

Lee D. Dixon, Jr., AIA
252-247-2121
lee@coastalarchitecture.net

4206 Bridges St. Ext.,
Suite C
Morehead City, NC
28557

www.CoastalArchitecture.net

NC074 KIA OF NEW BERN
NEW BERN, NORTH CAROLINA

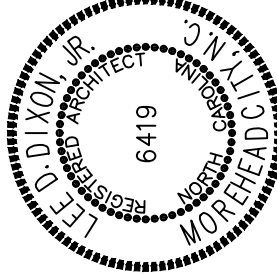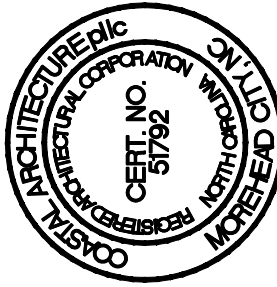

ROOM FINISH SCHEDULE

16034

ISSUED: 20 NOV 18
DWG BY: BLS, LSA
CKD BY: LDD

REVISIONS	

SHEET NO.

A3.6
OF

ROOM FINISH SCHEDULE

ROOM NUMBERS	ROOM	FLOORS	BASE	WALLS	PRIMARY PAINT	ACCENT PAINT	CEILING	HEIGHT (NOMINAL)	REMARKS
101	SHOWROOM	CT-2	CTB-1	GWB	PI		ACT-1	20'-0"	
102	SHOWROOM LOUNGE	CPT-1/CT-2	CTB-1	GWB	PI		ACT-1	11'-6"	
103	CONSULTATION	CPT-1	RB-1	GWB	PI	F8	ACT-1	11'-6"	②
104	CONSULTATION	CPT-1	RB-1	GWB	PI	F8	ACT-1	11'-6"	②
105	CONSULTATION	CPT-1	RB-1	GWB	PI	F8	ACT-1	11'-6"	②
106	CONSULTATION	CPT-1	RB-1	GWB	PI	F8	ACT-1	11'-6"	②
107	SALES MANAGER	CPT-1	RB-1	GWB	PI	N/A	ACT-1	11'-6"	
108	CORRIDOR	CT-2	CTB-1	GWB	PI	N/A	ACT-1	11'-6"	
109	CONSULTATION	CPT-1	RB-1	GWB	PI	F8	ACT-1	10'-0"	②
110	CONSULTATION	CPT-1	RB-1	GWB	PI	F8	ACT-1	10'-0"	②
111	CONSULTATION	CPT-1	RB-1	GWB	PI	F8	ACT-1	10'-0"	②
112	CAFE	CT-2/CT-4	CTB-1	GWB	PI	N/A	ACT-1	11'-6"	
112.1	INTERNET BAR	CT-2/CT-4	CTB-1	GWB	PI	N/A	ACT-1	11'-6"	
112.2	SERVICE LOUNGE	CT-2/CT-4	CTB-1	GWB	PI	N/A	ACT-1	11'-0"	
112.3	COFFEE	CT-4	CTB-1	GWB	PI	N/A	ACT-1	11'-6"	
112.5	GENERAL MANAGER	CPT-1	RB-1	GWB	PI	N/A	ACT-1	10'-0"	②
113	BDC CONFERENCE	CPT-1	RB-1	GWB	PI	N/A	ACT-1	10'-0"	
114	F#1 OFFICE	CPT-1	RB-1	GWB	PI	F8	ACT-1	10'-0"	②
115	MEN TOILET	CT-2	CTB-1	CT-10, CT-12, GWB	PI	N/A	GWB	10'-0"	①
116	JANITOR	CT-2	CTB-1	GWB	PI	N/A	GWB	10'-0"	①
117	WOMEN TOILET	CT-2	CTB-1	CT-10, CT-12, GWB	PI	N/A	GWB	10'-0"	①
118	KID'S PLAY ROOM	CPT-3	RB-1	GWB	PI	N/A	ACT-1	10'-0"	
119	KEYS	CT-2	CTB-1	GWB	PI	N/A	ACT-1	10'-6"	
120	MECHANICAL STORAGE	VCT-1	RB-1	GWB	PI	N/A	EXPOSED STRUCTURE	N/A	
121	CORRIDOR	CT-2	CTB-1	GWB	PI	N/A	ACT-1	11'-6"	
121.1	CORRIDOR	CT-2	CTB-1	GWB	PI	F6	ACT-1	11'-6"	④
122	SERVICE RECEPTION	EPOXY	N/A	METAL / CMU	PI	N/A	DEF8	14'-0"	
122.1	SERVICE WRITE-UP	CT-2	CTB-1	GWB	PI	N/A	ACT-1	11'-6"	
123	SERVICE MANAGER	RT-1	RB-1	GWB	PI	N/A	ACT-1	11'-6"	
124	GENERAL OFFICE	CPT-2	RB-1	GWB	PI	F8	ACT-1	10'-0"	②
125	OFFICE MANAGER	CPT-2	RB-1	GWB	PI	N/A	ACT-1	10'-0"	
126	RETAIL PARTS	RT-1	RB-1	GWB	PI	N/A	ACT-1	10'-0"	③
127	TECH PARTS	RT-1	RB-1	CMU / GWB	PI	N/A	ACT-1	10'-0"	
128	PARTS	SC-1	RB-1	CMU / GWB	PI	N/A	EXPOSED STRUCTURE	N/A	
129	TECH RESTROOM	CT-8	CTB-1	CT-3 ON CMU	PI	N/A	GWB	9'-0"	
130	TECH BREAKROOM	VCT-1	RB-1	CMU	PI	N/A	GWB	9'-0"	
131	SERVICE BAYS	EPOXY	N/A	CMU	PI	N/A	EXPOSED STRUCTURE	N/A	
132	COMPRESSOR	SC-1	RB-1	CMU	PI	N/A	EXPOSED STRUCTURE	N/A	
133	FLUIDS	SC-1	RB-1	CMU	PI	N/A	EXPOSED STRUCTURE	N/A	
134	SHOP EQUIPMENT	SC-1	RB-1	CMU	PI	N/A	EXPOSED STRUCTURE	N/A	
135	VEHICLE DELIVERY	EPOXY	N/A	METAL / CMU	PI	N/A	DEF8	14'-0"	
200	PARTS STORAGE	SC-1	RB-1	CMU / GWB	PI	N/A	EXPOSED STRUCTURE		
201	DEAD FILE	SC-1	RB-1	CMU / GWB	PI	N/A	EXPOSED STRUCTURE		
202	MECHANICAL	SC-1	RB-1	CMU / GWB	PI	N/A	EXPOSED STRUCTURE		

ROOM FINISH SCHEDULE REMARKS

- MOISTURE & MILDEW RESISTANCE %" GWB REQUIRED ON ALL WALLS & CEILING'S U.O.N.
- SEE SHEETS A-3.1 AND A-3.2 FOR FINISH DESCRIPTIONS.

- ① CT FLOOR TO BE MATTE FINISH.
- ② F8 ON ACCENT WALL- OWNER OPTION- SEE SHEET A-3.3 FOR LOCATION.
- ③ RETAIL PARTS SOFFIT PAINTED P-1

Coastal

Architecture

• Architectural Design

• Planning

• Interiors



Member of the American Institute of Architects

Lee D. Dixon, Jr., AIA

252-247-2121

lee@coastalarchitect.com


4206 Bridges St. Ext., Suite C

Morehead City, NC 28557

www.CoastalArchitecture.net

NC074 KIA OF NEW BERN

NEW BERN, NORTH CAROLINA

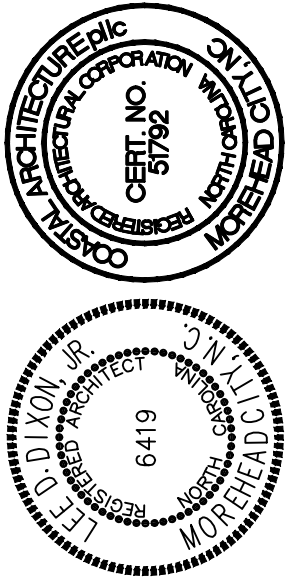

ROOM FINISH SCHEDULE

16034

ISSUED: 20 NOV 18
DWG BY: BLS, LSA
CKD BY: LDD

REVISIONS	

SHEET NO.
A3.7
OF

CODE	MATERIAL	MANUFACTURER	DESCRIPTION			LOCATION	ADDITIONAL INFORMATION
			PRODUCT	COLOR	DIMENSION		
ACT-1	ACOUSTIC CEILING TILE	ARMSTRONG	DUNE 1775	COLOR: WHITE EDGE DETAIL: 9/16" BEVELED TEGULAR GRID: INTERLUDE XL (9/16") DIMENSIONAL TEE GRID, COLOR, WHITE	24" X 24" X 5/8"	OFFICES, SHOWROOM, ADMINISTRATION, CUSTOMER CONTACT AREAS	CONTACT: BARRY BURNETT AT ARMSTRONG (877) 276-7876 EXT. 8325
CPT-1	CARPET	MOHAWK COMMERCIAL	LEES CUSTOM MODULAR	STYLE NUMBER: J2894 COLOR: #H7052 WROUGHT IRON	24" X 24" WIDE MODULAR TILE	SHOWROOM ACCENT, CONSULTATION, CONFERENCE ROOM, INTERNET/BDC	CONTACT: LES TERWILLEGGER AT MOHAWK INDUSTRIES (502) 439-3762 OR MELINDA WALLS AT MOHAWK INDUSTRIES (800) 622-6228 EXT. 44240 NOTE: VERTICAL ASHLAR INSTALLATION, CARPET TO BE INSTALLED PARALLEL TO THE FRONT OF THE OFFICE, REFER TO SHEET A-4E FOR ADDITIONAL INFORMATION NOTE: NATIONAL ACCOUNT PRICING HAS BEEN ESTABLISHED FOR THIS SPECIFICATION, PLEASE CONTACT LES TERWILLEGGER AT MOHAWK INDUSTRIES FOR DETAILS.
CPT-2	CARPET	MOHAWK COMMERCIAL	GATHERED STYLE	STYLE: 989 / BC404 / BQ404 COLOR: PIQUE	12"-0 WIDTH BROADLOOM	BOH, GENERAL OFFICES	CONTACT: LES TERWILLEGGER AT MOHAWK INDUSTRIES (502) 439-3762 OR MELINDA WALLS AT MOHAWK INDUSTRIES (800) 622-6228 EXT. 44240 NOTE: NATIONAL ACCOUNT PRICING HAS BEEN ESTABLISHED FOR THIS SPECIFICATION, PLEASE CONTACT LES TERWILLEGGER AT MOHAWK INDUSTRIES FOR DETAILS.
CPT-3	CARPET	MOHAWK COMMERCIAL	LEES GROUND STRATA MODULAR	STYLE NUMBER: GROUND STRATA II MODULAR COLOR: CELESTIAL 975	24" X 24" WIDE MODULAR TILE	KIDS AREA	CONTACT: LES TERWILLEGGER AT MOHAWK INDUSTRIES (502) 439-3762 OR MELINDA WALLS AT MOHAWK INDUSTRIES (800) 622-6228 EXT. 44240 NOTE: VERTICAL ASHLAR INSTALLATION, CARPET TO BE INSTALLED PARALLEL TO THE FRONT OF THE OFFICE, REFER TO SHEET A-3.5 FOR ADDITIONAL INFORMATION NOTE: NATIONAL ACCOUNT PRICING HAS BEEN ESTABLISHED FOR THIS SPECIFICATION, PLEASE CONTACT LES TERWILLEGGER AT MOHAWK INDUSTRIES FOR DETAILS.
CTB-1	CERAMIC TILE BASE BULLNOSE	VINE STREET TILE STUDIOS	PORCELAIN	KARBON FINISH: MATTE	3" X 12" BULLNOSE	GENERAL SHOWROOM	CONTACT: LORI RING AT HAMILTON PARKER & ASSOCIATES (614) 778-1491 SPECIAL NOTE: ARCHTTECT OF RECORD AND TILE INSTALLER ARE RESPONSIBLE FOR SPECIFYING ALL APPROPRIATE TRIMS & BASES. BASE TRIMS AND OUTSIDE CORNER PIECES MAY REQUIRE 6-8 WEEKS LEAD TIME FOR PRODUCTION.
CT-1	NOT USED						
CT-2	CERAMIC TILE	VINE STREET TILE STUDIOS	PORCELAIN	CARBON FINISH: POLISHED OR MATTE	24" X 24"	GENERAL SHOWROOM FIELD TILE, RESTROOM FLOOR TILE	CONTACT: LORI RING AT HAMILTON PARKER & ASSOCIATES (614) 778-1491 NOTE: USE WITH GR-1 NOTE: NATIONAL ACCOUNT PRICING HAS BEEN ESTABLISHED FOR THIS SPECIFICATION, PLEASE CONTACT HAMILTON PARKER & ASSOCIATES FOR DETAILS.
CT-3	NOT USED						
CT-4	CERAMIC TILE	DALTILE	YACHT CLUB	YC02 BRIDGE DECK	6" X 24"	CAFE FLOORING, SERVICE LOUNGE	CONTACT: TAMARA GRANDUSKY AT DAL-TILE CORPORATION (510) 817-4035, NOTE: USE WITH GR-2 NOTE: REFER TO ANSI REQUIREMENTS FOR CERAMIC TILE INSTALLATIONS, ANSI A108.02 SECTION 4.3.8 REGARDING GROUT JOINT SIZE, PARTICULARLY IN RELATION TO THE TILE SIZE, DIMENSIONAL PRECISION & OFF-SET PATTERN: NOTE: THE RUNNING BOND OFFSET WILL BE A MAXIMUM OF 33% UNLESS OTHERWISE SPECIFIED BY THE TILE MANUFACTURER, SEE SECTION 4.3.8.2.FOR RUNNING BOND/BRICK JOINT OFFSET.
CT-5	NOT USED						
CT-6	NOT USED						
CT-7	NOT USED						
CT-8	CERAMIC TILE	ROYAL MOSA	GLOBAL COLLECTION MOSA	75600V	12" X 12"	TECH RESTROOM, TECH LOCKER ROOM FLOOR FIELD TILE	CONTACT: NAN MCGINNIS AT LOUISVILLE TILE (513) 703-5801 NOTE: USE WITH GR-1
CT-9	CERAMIC TILE	ROYAL MOSA	1030 COLLECTION	13070	4" X 12"	TECH RESTROOM, TECH LOCKER ROOM WALL FIELD TILE	CONTACT: NAN MCGINNIS AT LOUISVILLE TILE (513) 703-5801 NOTE: USE SCHLUTER DILEX AHK (SATIN ALUMINUM) AHK1S 100AE FOR COVE BASE NOTE: USE WITH GR-1
				SCHLUTER JOLLY EDGE PROTECTION/FINISHING ATGB BRUSHED NICKEL ANODIZED ALUMINUM		TECH RESTROOM, TECH LOCKER ROOM TRIM PIECE	
CT-10	CERAMIC TILE	VINE STREET TILE STUDIOS	DIAMANTE FENDI AC	WHITE FINISH: SATIN	13" X 24" FIELD TILE	RESTROOM WALLS	CONTACT: LORI RING AT HAMILTON PARKER & ASSOCIATES (614) 778-1491 NOTE: USE WITH GR-3 NOTE: NATIONAL ACCOUNT PRICING HAS BEEN ESTABLISHED FOR THIS SPECIFICATION, PLEASE CONTACT HAMILTON PARKER & ASSOCIATES FOR DETAILS. NOTE: STACKED BOND INSTALLATION REQUIRED FOR ALL LARGE FORMAT WALL TILES NOTE: REFER TO THE TCNA HANDBOOK & ANSI REQUIREMENTS FOR PROPER INSTALLATION METHODS FOR LARGE FORMAT CERAMIC TILE WALL TILE. REFER TO ANSI A108.02 SECTION 4.3.7 REGARDING LIPPAGE & SECTION 4.3.8 REGARDING GROUT JOINT SIZE, PARTICULARLY IN RELATION TO THE TILE SIZE, DIMENSIONAL PRECISION & OFF-SET PATTERN. REQUIRED: TO ACHIEVE PROPER INSTALLATION FOR LARGER FORMAT WALL TILES, CONTRACTOR TO USE THE TUSCAN LEVELING SYSTEM OR EQUAL, DOUBLE SPREADING TECHNIQUE (BACK-BUTTERING). REFER TO THINSET MANUFACTURES TECHNICAL DATA SHEET FOR RECOMMENDED TROWEL SIZE & COVERAGE INFORMATION
CT-11	NOT USED						
CT-12	CERAMIC TILE	VINE STREET TILE STUDIOS	DIAMANTE RED BR	RED FINISH: POLISHED	13" X 24"	RESTROOM WALLS	CONTACT: LORI RING AT HAMILTON PARKER & ASSOCIATES (614) 778-1491 NOTE: USE WITH GR-3 NOTE: NATIONAL ACCOUNT PRICING HAS BEEN ESTABLISHED FOR THIS SPECIFICATION, PLEASE CONTACT HAMILTON PARKER & ASSOCIATES FOR DETAILS. NOTE: STACKED BOND INSTALLATION REQUIRED FOR ALL LARGE FORMAT WALL TILES NOTE: REFER TO THE TCNA HANDBOOK & ANSI REQUIREMENTS FOR PROPER INSTALLATION METHODS FOR LARGE FORMAT CERAMIC TILE WALL TILE. REFER TO ANSI A108.02 SECTION 4.3.7 REGARDING LIPPAGE & SECTION 4.3.8 REGARDING GROUT JOINT SIZE, PARTICULARLY IN RELATION TO THE TILE SIZE, DIMENSIONAL PRECISION & OFF-SET PATTERN. REQUIRED: TO ACHIEVE PROPER INSTALLATION FOR LARGER FORMAT WALL TILES, CONTRACTOR TO USE THE TUSCAN LEVELING SYSTEM OR EQUAL, DOUBLE SPREADING TECHNIQUE (BACK-BUTTERING). REFER TO THINSET MANUFACTURES TECHNICAL DATA SHEET FOR RECOMMENDED TROWEL SIZE & COVERAGE INFORMATION
D-7	INTERIOR DOOR	VT INDUSTRIES ARCHITECTURAL WOOD DOORS OR APPROVED EQUAL		404 VT DOOR TYPE, PC-HPDL- 5 HIGH PRESSURE DECORATIVE LAMINATE BONDED PARTICLE BOARD CORE 5-PLY CONSTRUCTION, NON-RATED OR 20 MIN. FINISH: PLASTIC LAMINATE, D354-60 DESIGNER WHITE, MATTE FINISH		GENERAL SHOWROOM	***NOTE: RATING AS REQUIRED NOTE: DOOR FRAME FINISH TO BE CLEAR ANODIZED
D-8	NOT USED						
D-9	INTERIOR STOREFRONT DOOR	KI - LIGHTLINE ARCHITECTURAL WALL	LUDS FULL HEIGHT SINGLE SLIDE DOOR	ODTD = GLASS PoA = CLEAR ANODIZED	FULL HEIGHT X 43.5"	SALES CONSULT OFFICES	CONTACT: KELLY OESTER AT KI (714) 393-9763 KELLY.OESTER@KI.COM DOOR HARDWARE: BPCS# 38.13.3979
DP-1	DRAWER PULL	MOCKET	DP3C	SATIN NICKEL	6"	FIXTURES AS NOTED	
FIX-1	ESPRESSO MACHINE	SAECO	TABLE TOP VENDING MACHINES	RUBINO 200 ESPRESSO		COFFEE BAR	CONTACT: SAECO USA AT (800) 933-7876
FIX-2	RESTROOM LAVATORY	TOTO	UNDERCOUNTER LAVATORY	LT191(G) SANAGLOSS GLAZING COLOR: #01 COTTON	23 3/4" W 14 3/8" D	RESTROOMS	CONTACT: TOTO USA, INC. (800) 350-8686



- Architectural Design
- Planning
- Interiors



Member of the American Institute of Architects

Lee D. Dixon, Jr., AIA
252-247-2121
lee@coastalarchitecture.net



4206 Bridges St. Ext., Suite C
Morehead City, NC 28557

www.CoastalArchitecture.net

NC074 KIA OF NEW BERN

NEW BERN, NORTH CAROLINA

CODE	MATERIAL	MANUFACTURER	DESCRIPTION			LOCATION	ADDITIONAL INFORMATION
			PRODUCT	COLOR	DIMENSION		
FIX-3	RESTROOM FAUCET	TOTO	GOOSENECK ECOPOWER FAUCET	FAUCET - .05 GPM LAVATORY FAUCETS TEL155-D10ETEL155 - C20ET#CP COLOR/FINISH: #CP POLISHED CHROME		RESTROOMS	CONTACT: TOTO USA, INC. (800) 350-8686
FIX-4	HAND DRYER	DYSON	DYSON AIRBLADE	AB-14 COLOR/FINISH: GRAY/ SILVER	14.3" W X 12.2" D X 29.1" H	RESTROOMS	CONTACT: DYSON BTB INC. (888) 397-6622
FIX-5	TOILET	TOTO	WALL MOUNTED FLUSHOMETER TOILET, 1.28 GPF WHEN USED WITH HIGH EFFICIENCY FLUSHOMETER VALVE	CT708E(VG) SANAGLOSS CERAMIC GLAZE COLOR: #01 COTTON INCLUDE FLUSHOMETER VALVE - ECOPOWER & SEAT		RESTROOMS	CONTACT: TOTO USA, INC. (800) 350-8686
FIX-6	URINAL	TOTO	0.5GPF LOW CONSUMPTION WASHOUT URINAL	UT104E 3/4" TOP SPUD INLET COLOR: #01 COTTON INCLUDE FLUSH VALVE - ECOPOWER		RESTROOMS	CONTACT: TOTO USA, INC. (800) 350-8686
GF-1	GLASS FILM	3M	FASARA GLASS FINISHES	COLOR: WHITE, SH2MACRX2 STYLE: FROST/MAT	50" x 98.4" ROLL THICKNESS: 2.76 MIL	SALES CONSULT REAR WINDOWS	CONTACT: 3M AT 1-888-650-3497 WWW.3M.COM/AMD
GL-1	NOT USED						
GL-2	NOT USED						
GL-3	NOT USED						
GR-1	GROUT	BOSTIK CERAMIC PRODUCTS	HYDROMENT TRU COLOR PRE-MIXED GROUT OR HYDROMENT CERAMIC TILE SANDED GROUT	COLOR: H195 SHADOW/ D-644 COBBELSTONE		USED ON CT-1, CT-2, CT-5, CT-8, CT-9 ONLY	CONTACT: LORI RING AT HAMILTON PARKER & ASSOCIATES (614) 778-1491 NOTE: TRU COLOR GROUT IS A URETHANE PRODUCT, REFER TO MANUFACTURERS WEBSITE OR SALES REPRESENTATIVE FOR RECOMMENDED URETHANE GROUT INSTALLATION.
GR-2	GROUT	BOSTIK CERAMIC PRODUCTS	HYDROMENT TRU COLOR PRE-MIXED GROUT OR HYDROMENT CERAMIC TILE SANDED GROUT	COLOR: H142 FRENCH GRAY/ D-G06 STORM		USED ON CT-3, CT-4 CT-6 , CT-7 ONLY	
GR-3	GROUT	BOSTIK CERAMIC PRODUCTS	HYDROMENT TRU COLOR PRE-MIXED GROUT OR HYDROMENT CERAMIC TILE SANDED GROUT	COLOR: H158 CLASSIC BONE/ D-G19 CLASSIC BONE		USED ON CT-10, CT-11, AND CT-12 ONLY	
MT-1	NOT USED						
P-1	PAINT	BENJAMIN MOORE	524 AURA EGGSHELL WATERBORNE INTERIOR PAINT	INTERIOR READY MIXED WHITE 01 NOTE: THIS IS AN OPTION TO WC-1		GENERAL WALLS, CEILING SOFFITS, COLUMNS, SERVICE RECEPTION & DELIVERY WALLS	CONTACT: JASON WALKER AT BENJAMIN MOORE (773) 597-8698 NOTE: CONTACT MANUFACTURER TO OBTAIN APPROPRIATE PRIMER & PAINT FOR SUBSTRATE. FOR DARKER COLORS TINT THE PRIMER TO FIFTY PERCENT (50%). SUPER SPEC HP REQUIRES A CATALYST, USE KP43-86 FOR SEMI-GLOSS CATALYST. NOTE: FOR METAL INTERIOR COLUMNS, PLEASE USE SUPER SPEC HP DTM ACRYLIC LOW LUSTER P25
P-2	PAINT	BENJAMIN MOORE	INSL-X COROTECH PRE-CATALYZED WATERBORNE EPOXY SEMI-GLOSS V341	2125-40 SHADOW GRAY		LOWER WALL IN SERVICE AREA	CONTACT: JASON WALKER AT BENJAMIN MOORE (773) 597-8698 PRIMER: GYP BOARD -BENJAMIN MOORE SURE SEAL LATEX PRIMER SEALER (027); CONCRETE BLOCK - BENJAMIN MOORE SUPER SPEC MASONRY INTERIOR/EXTERIOR HI-BUILD BLOCK FILLER (N068); ANY OTHER SUBSTRATE - CONSULT SPEC SHEET OR CONTACT MANUFACTURER FOR APPROPRIATE RECOMMENDATION
P-3	PAINT	BENJAMIN MOORE	INSL-X COROTECH PRE-CATALYZED WATERBORNE EPOXY SEMI-GLOSS V341	2125-20 DEEP SPACE		SERVICE AREA STRIPE	
P-4	PAINT	BENJAMIN MOORE	INSL-X COROTECH PRE-CATALYZED WATERBORNE EPOXY SEMI-GLOSS V341	2125-70 WEDDING VEIL		GENERAL WALLS IN SERVICE AREA	
P-5	PAINT	BENJAMIN MOORE	PRIMER: P04 ACRYLIC METAL PRIMER - AS NEEDED PAINT: P29 DTM ACRYLIC SEMI-GLOSS	2125-70 WEDDING VEIL		SERVICE AREA CEILINGS	CONTACT: JASON WALKER AT BENJAMIN MOORE (773) 597-8698 NOTE: CONTACT MANUFACTURER TO OBTAIN APPROPRIATE PRIMER & PAINT FOR SUBSTRATE. FOR DARKER COLORS TINT THE PRIMER TO FIFTY PERCENT (50%). SUPER SPEC HP REQUIRES A CATALYST, USE KP43-86 FOR SEMI-GLOSS CATALYST.
P-6	PAINT	GLIDDEN PROFESSIONAL	PRIMER: 1030-1200N PVA, INTERIOR PRIMER SEALER PAINT: 1433 ULTRA-HIDE 150, INTERIOR LO LUSTRE	#31YR 10/591 CRIMSON RED NOTE: THIS IS AN OPTION TO WC-2		ACCENT WALLS	CONTACT: GENE MILLER AT GLIDDEN PROFESSIONAL (937) 604-0004
P-7	PAINT	BENJAMIN MOORE	524 AURA EGGSHELL WATERBORNE INTERIOR PAINT	2126-50 GRAY TIMBER WOLF		RETAIL PARTS SOFFIT	CONTACT: JASON WALKER AT BENJAMIN MOORE (773) 597-8698 NOTE: CONTACT MANUFACTURER TO OBTAIN APPROPRIATE PRIMER & PAINT FOR SUBSTRATE. FOR DARKER COLORS TINT THE PRIMER TO FIFTY PERCENT (50%). SUPER SPEC HP REQUIRES A CATALYST, USE KP43-86 FOR SEMI-GLOSS CATALYST.
P-8	PAINT	BENJAMIN MOORE	524 AURA EGGSHELL WATERBORNE INTERIOR PAINT	2112-50 STORMY MONDAY		GENERAL OFFICE ACCENT WALL	CONTACT: JASON WALKER AT BENJAMIN MOORE (773) 597-8698 NOTE: CONTACT MANUFACTURER TO OBTAIN APPROPRIATE PRIMER & PAINT FOR SUBSTRATE. FOR DARKER COLORS TINT THE PRIMER TO FIFTY PERCENT (50%). SUPER SPEC HP REQUIRES A CATALYST, USE KP43-86 FOR SEMI-GLOSS CATALYST.
PL-1	LAMINATE	WILSONART	SOLIDS	D354-01 DESIGNER WHITE HIGH GLOSS FINISH		RESTROOM PARTITIONS FIXTURES AS NOTED	CONTACT: DONNA ARIAPAD AT FLAGG INC. (800) 736-3524
PL-2	LAMINATE	WILSONART	PREMIUM WILSONART LAMINATE	1595-60 BLACK MATTE FINISH			CONTACT: DONNA ARIAPAD AT FLAGG INC. (800) 736-3524
PL-3	LAMINATE	WILSONART	PREMIUM WILSONART LAMINATE	4880-38 CARBON MESH FINE VELVET TEXTURE FINISH		BREAKROOM COUNTERTOP	CONTACT: DONNA ARIAPAD AT FLAGG INC. (800) 736-3524
PL-4	LAMINATE	WILSONART	PREMIUM WILSONART LAMINATE	4877-38 GREY MESH FINE VELVET TEXTURE FINISH		BREAKROOM CABINETS	CONTACT: DONNA ARIAPAD AT FLAGG INC. (800) 736-3524
QS-1	NOT USED						
QS-2	QUARTZ SURFACE	DUPONT	ZODIAC	STORM GREY		RESTROOM COUNTERTOPS	CONTACT: DAVID GREENING AT DUPONT (614) 975-6700 DAVID.P.GREENING@DUPONT.COM
RB-1	RESILIENT BASE	ROPPE CORPORATION	PINNACLE STANDARD RUBBER WALL BASE	123 CHARCOAL TYPE TS	4" HEIGHT 1/8" THICKNESS	STORAGE, BREAKROOM GENERAL OFFICES, CONFERENCE ROOM, ADMIN	CONTACT: JENNIFER FINLAYSON AT ROPPE CORPORATION (419) 435-8546
RP-1	RESTROOM PARTITIONS	ACCURATE PARTITIONS CORP.	POWDERCOATED STEEL	PARTITION COLOR: 980 WHITE FLOOR ANCHORED		RESTROOMS	CONTACT: ACCURATE PARTITION CORP. (708) 442-6800 WWW.ACCURATEPARTITIONS.COM
RS-1	NOT USED						
RT-1	RUBBER TILE FLOORING	ROPPE CORPORATION	SAFETCORK RUBBER TILE	Z100 BLACK STYLE: 996 RAISED CIRCULAR VANTAGE PROFILE	19" X 19"	SERVICE MANAGER, RETAIL PARTS, TIRES/EQUIPMENT	CONTACT: JENNIFER FINLAYSON AT ROPPE CORPORATION (419) 435-8546
RV-1	NOT USED						
RV-2	NOT USED						
RV-3	REVEAL	FRY REGLET ARCHITECTURAL METALS	"F" REVEAL MOLDING	PART# DRMF-XX-XX SILVER SATIN		BRAND WALL AS NOTED	
SC-1	SEALED CONCRETE	SCOFIELD SYSTEMS		SCOFIELD FORMULA ONE LITHIUM DENSIFIER MP & SCOFIELD FORMULA ONE FINISH COAT		PARTS ROOM, BOH	CONTACT: ROBERT E. KRAUSKOPF AT L.M. SCOFIELD COMPANY (800) 800-9900 NOTE: REFER TO MANUFACTURERS SALES REP FOR APPROPRIATE PRODUCTS & INSTALLATION RECOMMENDATIONS
SF-2	STORE FRONT	PITTCO ARCHITECTURAL METALS, INC. OR EQUAL	BY ARCHITECT OF RECORD	CLEAR ANODIZED FINISH #42 TOP & BOTTOM TRIM, TEMPERED GLASS, POLISHED EDGES	GLASS THICKNESS TBD BY GLAZING CONTRACTOR	INTERIOR OFFICES	PROVIDED BY ARCHITECT OF RECORD
SS-1	SOLID SURFACE	DUPONT	CORIAN	GLACIER WHITE		FIXTURES AS NOTED	CONTACT: DAVID GREENING AT DUPONT (614) 975-6700 DAVID.P.GREENING@DUPONT.COM
SS-2	SOLID SURFACE	DUPONT	CORIAN	GRAYLITE		FIXTURES AS NOTED	CONTACT: DAVID GREENING AT DUPONT (614) 975-6700 DAVID.P.GREENING@DUPONT.COM
TS-1	TRANSITION	SCHLUTER		SCHIENE FINISH: (AE) SATIN ANODIZED ALUMINUM		CERAMIC TILE TO CERAMIC TILE	CONTACT: JAY WRAY AT SCHLUTER SYSTEMS (800) 472-4588 EXT.112
TS-2	TRANSITION	SCHLUTER		RENO-TK FINISH: (AE) SATIN ANODIZED ALUMINUM		CERAMIC TILE TO CARPET	CONTACT: JAY WRAY AT SCHLUTER SYSTEMS (800) 472-4588 EXT.112
TS-3	TRANSITION	SCHLUTER		RENO-V FINISH: (AE) SATIN ANODIZED ALUMINUM		CARPET TO VINYL FLOORING	CONTACT: JAY WRAY AT SCHLUTER SYSTEMS (800) 472-4588 EXT.112
TS-4	TRANSITION	SCHLUTER		RENO-U FINISH: (AE) SATIN ANODIZED ALUMINUM		CERAMIC TILE TO VINYL/RUBBER FLOORING	CONTACT: JAY WRAY AT SCHLUTER SYSTEMS (800) 472-4588 EXT.112
VCT-1	VINYL COMPOSITION TILE	ARMSTRONG	MIGRATIONS	T3503 ASHEN GREY	12" X 12" 1/8" THICKNESS	TECH BREAKROOM FLOORING	CONTACT: JACK MACKEVERICAN AT ARMSTRONG (800) 356-9301 EXT. 8846
VF-1	VINYL FLOORING	TAJIMA FLOORING	STEEL TILE	MAE-3036 CARBON	18" X 18" 1/8" THICKNESS	BREAKROOM FLOORING	CONTACT: TAJIMA FLOORING (888) 652-2111

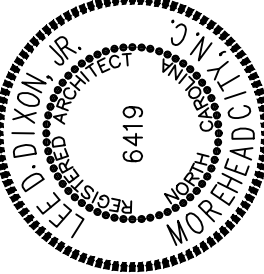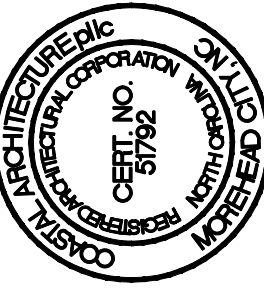

ROOM FINISH SCHEDULE

16034



ISSUED: 20 NOV 18

DWG BY: BLS, LSA

CKD BY: LDD

REVISIONS

SHEET NO.
A3.8
OF

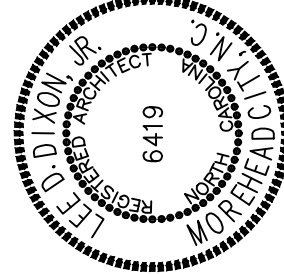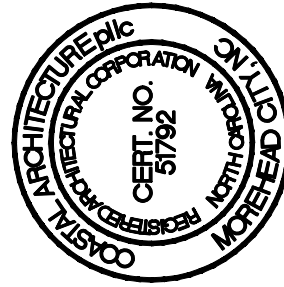

FURNITURE SCHEDULE

16034

ISSUED: 20 NOV 18

DWG BY: BLS

CKD BY:

REVISIONS

SHEET NO.

A-3.9

OF

CODE	MATERIAL	MANUFACTURER	DESCRIPTION			LOCATION	ADDITIONAL INFORMATION
			PRODUCT	COLOR	DIMENSION		
FB-1	FABRIC *REQUIRED, SEE NOTES	PALLAS	FABRIC FOR LOUNGE SEATING ON KI, LYRA CHAIR	PATTERN: HOLY COW COLOR: THUNDERSTORM 27.144.092	HIDE SIZE 55 SQ. FT.	SALES FLOOR LOUNGE SEATING	CONTACT: LOIS WILTGEN 877-287-4927 LOIS.WILTGEN@KI.COM NOTE: THIS IS A REQUIRED FABRIC FOR THE KIA CBS PROGRAM, SEE FB-1 OPTION FOR AN ALLOWABLE SUBSTITUTION.
FB-1 *OPTION	FABRIC	PALLAS	FABRIC FOR LOUNGE SEATING	PATTERN: SANDSTONE COLOR: OBSIDIAN 27.222.202	54" WIDE	SALES FLOOR LOUNGE SEATING	CONTACT: LOIS WILTGEN 877-287-4927 LOIS.WILTGEN@KI.COM NOTE: THIS IS AN OPTION FOR FB-1
FB-2	FABRIC *REQUIRED, SEE NOTES	MOMENTUM TEXTILES	FABRIC FOR SIDE SEATING	PATTERN: SILICA 09122452 COLOR: CUMULUS	54" WIDE	CONSULTATION & OFFICE SIDE SEATING	CONTACT: AMBER SUMMERS AT THE MOMENTUM GROUP (800) 366-6839 EXT.819 NOTE: THIS IS A REQUIRED FABRIC FOR THE KIA CBS PROGRAM, NO SUBSTITUTIONS ALLOWED.
FB-3	FABRIC *REQUIRED, SEE NOTES	MOMENTUM TEXTILES	FABRIC FOR BENCH	PATTERN: BRAVO II 09135696 COLOR: CINDER	54" WIDE	SALES FLOOR & SERVICE WRITE-UP BENCH	CONTACT: AMBER SUMMERS AT THE MOMENTUM GROUP (800) 366-6839 EXT.819 NOTE: THIS IS A REQUIRED FABRIC FOR THE KIA CBS PROGRAM, NO SUBSTITUTIONS ALLOWED.
FB-4	LEATHER *REQUIRED, SEE NOTES	KI FABRIC	LEATHER OPTION FOR LOUNGE SEATING	PATTERN: HAREN LEATHER COLOR: MERCURY/LHMY	50-55 APPROX. SQ. FT.	SHOWROOM LOUNGE, SERVICE LOUNGE - OPTION, 2ND FLOOR LOUNGE AREA	CONTACT: LOIS WILTGEN 877-287-4927 LOIS.WILTGEN@KI.COM NOTE: THIS IS A REQUIRED FABRIC FOR THE KIA CBS PROGRAM, THIS IS AN ALLOWABLE SUBSTITUTION FOR THE LOUNGE SEATING FABRIC, SEE FB-1 FOR ALTERNATE OPTION.
FB-5	FABRIC	PALLAS TEXTILES	FABRIC FOR LOUNGE SEATING ON KI SELA CHAIR	PATTERN: 27.144.092 HOLY COW COLOR: THUNDERSTORM	54" WIDE	SALES FLOOR LOUNGE SEATING	CONTACT: PALLAS TEXTILES AT (800) 472-5527
FN-1	LOUNGE SEATING *REQUIRED, SEE NOTES	KI	SELA LOUNGE CHAIR WITH METAL BASE	1323 NC (NON CONTRAST) FABRIC: FB-1 CHROME BASE	32" W 33.5" D 28.25" H 17.75" SH	CUSTOMER LOUNGE AREAS	CONTACT: LOIS WILTGEN AT KI (877) 287-4927 / LOIS.WILTGEN@KI.COM NOTE: THIS IS A REQUIRED PIECE OF FURNITURE FOR THE KIA CBS PROGRAM, NO SUBSTITUTIONS ALLOWED. NOTE: NATIONAL ACCOUNT PRICING HAS BEEN ESTABLISHED FOR THIS SPECIFICATION, PLEASE CONTACT KI FOR DETAILS.
FN-2	SIDE TABLE *REQUIRED, SEE NOTES	KEILHAUER	CAHOOTS TABLES	SQ #12-0503-01, KIA STANDARDS 9081 - SMALL ROUND TABLE TOP: ANODIZED ALUMINUM, COLOR: SILVER BASE: CHROME	17.25" DIAMETER 17.25" HEIGHT	SHOWROOM LOUNGE, SERVICE LOUNGE	CONTACT: STEVE GROH AT GROH CONTRACT SERVICES LLC. (513) 683-8282 NOTE: THIS IS A REQUIRED PIECE OF FURNITURE FOR THE KIA CBS PROGRAM, NO SUBSTITUTIONS ALLOWED. NOTE: NATIONAL ACCOUNT PRICING HAS BEEN ESTABLISHED FOR THIS SPECIFICATION, PLEASE CONTACT GROH CONTRACT SERVICES LLC. FOR DETAILS, REFERENCE SQ #12-0503-01, KIA STANDARDS
FN-3	COFFEE TABLE *REQUIRED, SEE NOTES	KEILHAUER	CAHOOTS TABLES	SQ #12-0503-01, KIA STANDARDS 9083 - LARGE ROUND TABLE, HIGH TOP: ANODIZED ALUMINUM, COLOR: SILVER BASE: CHROME	37" DIA 18" H	SHOWROOM LOUNGE, SERVICE LOUNGE	CONTACT: STEVE GROH AT GROH CONTRACT SERVICES LLC. (513) 683-8282 NOTE: THIS IS A REQUIRED PIECE OF FURNITURE FOR THE KIA CBS PROGRAM, NO SUBSTITUTIONS ALLOWED. NOTE: NATIONAL ACCOUNT PRICING HAS BEEN ESTABLISHED FOR THIS SPECIFICATION, PLEASE CONTACT GROH CONTRACT SERVICES LLC. FOR DETAILS, REFERENCE SQ #12-0503-01, KIA STANDARDS
FN-4	CAFE TABLE	BERNHARDT DESIGN	STORY TABLE ROUND TOP	Q-YAY-F-F-V-611 TOP: LAMINATE, FORMICA, BRITE WHITE 459-58, WITH DESIGNER WHITE EDGE	24" X 24" 1.25" H	CAFE	CONTACT: CHRISSSIE DIXON AT BERNHARDT DESIGN (828) 759-6765 chrissiedixon@bernhardt.com COLEMAN GUTSHALL AT BERNHARDT DESIGN (828) 759-6539 colemangutshall@bernhardt.com NOTE: NATIONAL ACCOUNT PRICING HAS BEEN ESTABLISHED FOR THIS SPECIFICATION, PLEASE CONTACT THE DORSEY GROUP FOR DETAILS.
			STORY TABLE BASE	V-5FX-X-X-6-XXX FINISH: POLISHED ALUMINUM TABLE HEIGHT FIXED	29" W 29" D 27.75" H		
FN-4 *OPTION	CAFE TABLE *ALTERNATE WOOD OPTION, ADDITIONAL COST	THONET.DE BY ICF FURNITURE	1404 SERIES SQUARE CAFE TABLE	140400BE0WHL000035SQ - STEFAN DIEZ TABLE, BEECH COVERED IN WHITE LAQUER	35.4" X 34.5" 28" H	CAFE	CONTACT: CONNAL DORSEY AT THE DORSEY GROUP (740) 881-9955 NOTE: IMPORTED. EXTENDED LEAD TIME OF APPROXIMATELY 12-14 WEEKS DUE TO SHIPPING & PROCESSING THROUGH CUSTOMS.
FN-5	CAFE CHAIRS	GORDON INTERNATIONAL	2540 FORMULA CHAIR	2540 FORMULA CHAIR, HARD SHELL, 4 LEG STACKABLE SIDE CHAIR COLOR: WHITE	19.25" W 22.5" D 31" H 18" SH	CAFE	CONTACT: TIM O'NEIL AT TIM O'NEIL & ASSOCIATES (614) 560-3373 NOTE: IMPORTED. EXTENDED LEAD TIME OF APPROXIMATELY 12-14 WEEKS DUE TO SHIPPING & PROCESSING THROUGH CUSTOMS.
FN-5 *OPTION	CAFE CHAIRS	VITRA	VITRA HAL TUBE	44020200, KIA STANDARDS PLASTIC SHELL: WHITE, GLIDE COLOR: WHITE LEG/BASE FINISH: CHROME	18.5" W 17" D 31" H 17" SH	CAFE	CONTACT: NICOLE VALDES STARKEY AT (562) 277-3774 NICOLE.STARKEY@VITRA.COM
FN-6	CONSULTATION TABLE	KEILHAUER	JUXTA 47243	ROUND TABLE: LAM 31 DESIGNER WHITE LAMINATE FINISH TOP LAMINATE REVERSE BEVEL VINYL EDGE OUTLET FIXTURE IS AN OPTION BASE COLOR: POLISHED ALUMUNUM NOTE: SEE CIRCUIT MEDIATRAC FOR POWER & DATA MANAGEMENT	36" D 29" H	CONSULTATION, DELIVERY	CONTACT: STEVE GROH AT GROH CONTRACT SERVICES LLC. (513) 683-8282 NOTE: ARCHITECT OF RECORD & FURNITURE DEALER TO PROVIDE/COORDINATE POWER & DATA REQUIREMENTS FOR CONSULTATION TABLE. SEE CIRCUIT MEDIATRAC SYSTEM FOR POWER & DATA MANAGEMENT. NOTE: NATIONAL ACCOUNT PRICING HAS BEEN ESTABLISHED FOR THIS SPECIFICATION, PLEASE CONTACT GROH CONTRACT SERVICES LLC FOR DETAILS.
FN-7	BAR STOOL	ANDREU WORLD	LINEAL COMFORT BARSTOOL BQ-0599 OR LINEAL BARSTOOL BQ-0590	FABRIC: ANDREU WORLD VINYL, VALENCIA 107-2075 ROT./CAT. 1 FRAME: STEEL SLED BASE FRAME OR WOOD: BEECH/ OAK/ ASH FINISH: 642L RAL 3013 (RED)	20.75" W 20" D 41" H	INTERNET BAR, RETAIL PARTS BOUTIQUE	CONTACT: STEVE GROH AT GROH CONTRACT SERVICES LLC. (513) 683-8282 NOTE: NATIONAL ACCOUNT PRICING HAS BEEN ESTABLISHED FOR THIS SPECIFICATION, PLEASE CONTACT GROH CONTRACT SERVICES LLC FOR DETAILS.
FN-8	TASK SEATING	HERMAN MILLER	SETU MULTIPURPOSE CHAIR (5-STAR BASE)	CQ51-M-A-SG-5Y-BB-4W01 ARMS: RIBBON ARMS BASE: 5 STAR BASE, STANDARD-HEIGHT RANGE, FRAME FINISH: (SG) SLATE GREY, BASE FINISH: (5Y) SEMI-POLISHED LYRIS FABRIC: 4W01 ALPINE HARD CARPET CASTER, BLACK YOLK	25 1/8" W 17 1/4" D 38 3/8" H 17" - 21 1/2" SH	BOH ONLY	CONTACT: LESLEY COLLETT-FELIX AT HERMAN MILLER: (614) 561-9778 NOTE: FURNITURE DEALER TO COORDINATE SPECIFIC SEATING REQUIREMENTS & SEATING QUANTITIES WITH THE OWNER AND/OR ARCHITECT OF RECORD. ALL AUTO DEALER PROGRAMMING NEEDS ARE TO BE CONSIDERED. NOTE: NATIONAL ACCOUNT PRICING HAS BEEN ESTABLISHED FOR THIS SPECIFICATION, PLEASE CONTACT LESLEY COLLETT-FELIX AT HERMAN MILLER FOR DETAILS.
FN-9	GUEST SEATING *REQUIRED, SEE NOTES	KEILHAUER	CAHOOTS ARMLESS SIDE CHAIR W/ LEG BASE	SQ #12-0503-01, KIA STANDARDS 9070 FABRIC: FB-2, MOMENTUM, SILICA, CUMULUS LEG/FRAME FINISH: CHROME	21" W 23.25" D 35" H 18.25" SH	SALES CONSULTATION, GENERAL OFFICE GUEST CHAIR, DELIVERY	CONTACT: STEVE GROH AT GROH CONTRACT SERVICES LLC. (513) 683-8282 NOTE: THIS IS A REQUIRED PIECE OF FURNITURE FOR THE KIA CBS PROGRAM, NO SUBSTITUTIONS ALLOWED. NOTE: NATIONAL ACCOUNT PRICING HAS BEEN ESTABLISHED FOR THIS SPECIFICATION, PLEASE CONTACT GROH CONTRACT SERVICES LLC. FOR DETAILS, REFERENCE SQ #12-0503-01, KIA STANDARDS.
FN-9 *OPTION	GUEST SEATING *REQUIRED, SEE NOTES	SITONIT SEATING	ACHIEVE ARMLESS SIDE CHAIR	91FS, KIA STANDARDS FABRIC: GRD6 MOMENTUM, SILICA, CUMULUS LEG/FRAME FINISH: METALIC SILVER	22" W 24" D 33.5" H 18" SH	SALES CONSULTATION, GENERAL OFFICE GUEST CHAIR, DELIVERY	CONTACT: BRETT WIKANDER AT (714) 995-4800 BWIKANDER@EXEMPLIS.COM
FN-10	TASK SEATING *REQUIRED, SEE NOTES	HUMANSCALE	DIFFRIENT WORLD CHAIR	W-1-1-V-M14-V114-STANDARD-STANDARD-STANDARD ARMS: HEIGHT ADJUSTABLE DURON ARMS FRAME FINISH: (V) GRAY, BACKREST: (M) MONOFILAMENT STRIPE, COLOR PLATINUM SEAT: (V) VELLUM, COLOR LIGHT GRAY, 5 STAR BASE, STANDARD-HEIGHT RANGE, STANDARD HARD CARPET CASTER	21.1" W 16.5"-20" D 36.5"-41.5" H 16"-21" SH	MANAGERS OFFICES, F&I OFFICE, SALES CONSULTATION, INTERNET SALES	CONTACT: BRIAN LEE AT HUMANSCALE (714) 430-6850 EXT.3128 NOTE: FURNITURE DEALER TO COORDINATE SPECIFIC SEATING REQUIREMENTS & SEATING QUANTITIES WITH THE OWNER AND/OR ARCHITECT OF RECORD. ALL AUTO DEALER PROGRAMMING NEEDS ARE TO BE CONSIDERED. NOTE: OPTIONAL FEATURES FOR REQUIRED SEATING (PNEUMATIC, TILT MECHANISM, ARM PADS ETC.) COULD BE ADDED FOLLOWING THE DIFFERENT WORLD CHAIR SPECIFICATION GUIDELINES (STYLE, FABRIC, FINISHES) LISTED IN SCHEDULE. AUTO DEALER TO COORDINATE THESE ADDITIONAL NEEDS WITH THEIR LOCAL FURNITURE DEALER OR SALES REP. NOTE: THIS IS A REQUIRED PIECE OF FURNITURE FOR THE KIA CBS PROGRAM, NO SUBSTITUTIONS ALLOWED. NOTE: NATIONAL ACCOUNT PRICING HAS BEEN ESTABLISHED FOR THIS SPECIFICATION, PLEASE CONTACT BRIAN LEE AT HUMANSCALE FOR DETAILS.

NOTE: ALL FURNITURE TO BE PROVIDED BY OWNER UNLESS OTHERWISE NOTED

P:\2019\16034 KIA of New Bern\GIBERN\A-110\DWG\NEW BERN\16034 KIA.dwg, 11/20/2019 1:44:48 PM, DWG, 30, 0.01 g3d

CODE	MATERIAL	MANUFACTURER	DESCRIPTION			LOCATION	ADDITIONAL INFORMATION
			PRODUCT	COLOR	DIMENSION		
FN-11	WORK STATION *REQUIRED, SEE NOTES	HERMAN MILLER	CANVAS FURNITURE, SQUARE EDGE RECTANGULAR DESK WITH PLASTIC SCREEN	FTS10-30-72-LS-XX 30" X 72" SQUARE EDGE RECTANGULAR LAMINATE SURFACE W/STIFFNER (FV696.57) TOP FINISH: (COL) CUSTOMERS OWN LAMINATE NEVAMAR WOOD-GRAIN LAMINATE, WT0003PV VALENCIA TEAK, EDGE COLOR: (MT) ***SEE NOTES FOR CABLE MANAGEMENT	SIZES VARY, SEE NOTES 30"W X 72"L	SALES CONSULTATION, NEW SALES MANAGER, USED SALES MANAGER, SERVICE MANAGER, OFFICE MANAGER	CONTACT: LESLEY COLLETT-FELIX AT HERMAN MILLER: (614) 561-9778 NOTE: OWNER & FURNITURE DEALER TO PROVIDE/COORDINATE FURNITURE DIMENSIONS APPROPRIATE TO AUTO DEALER SIZE & VOLUME. ALL OWNER PROGRAMMING NEEDS ARE TO BE CONSIDERED. OWNER AND/OR ARCHITECT OF RECORD TO COORDINATE DESKING REQUIREMENTS (LIGHTING, HARDWARE, CORD & CABLE MANAGEMENT, WALL STRIP ATTACHMENTS, ACCESSORIES & STORAGE ETC.) WITH FURNITURE DEALER FOR EXACT SPECIFICATIONS & SITE SPECIFIC REQUIREMENTS. A STIFFNER IS REQUIRED FOR SIZE OF WORK SURFACE NOTED. FOR OTHER WORK SURFACE SIZES, REFER TO HERMAN MILLER PLANNING GUIDE FOR STIFFNER REQUIREMENTS. NOTE: ADDITIONAL OFFICE COMPONENTS, STORAGE, FILING, ETC. COULD BE ADDED FOLLOWING THE CANVAS SPECIFICATION GUIDELINES (STYLE, FABRIC, FINISHES) LISTED IN SCHEDULE. AUTO DEALER TO COORDINATE THESE ADDITIONAL NEEDS WITH THEIR LOCAL HERMAN MILLER DEALER NOTE: THIS IS A REQUIRED PIECE OF FURNITURE FOR THE CBS PROGRAM, NO SUBSTITUTIONS ALLOWED. NOTE: NATIONAL ACCOUNT PRICING HAS BEEN ESTABLISHED FOR THIS SPECIFICATION, PLEASE CONTACT LESLEY COLLETT-FELIX AT HERMAN MILLER FOR DETAILS.
			SQUARE OPEN LEG SUPPORT	FV2D2-S-30-FL (INCLUDE RIGHT LEG)-MS FRAME: SQUARE OPEN LEG, PAINTED (MS) METALLIC SILVER, FIXED LEG			
			SCREEN	FV694-A-12A-66-39-MS SCREEN: TRANSLUCENT PLASTIC, OPAL FROSTED NOTE: SCREEN SHOULD BE INSTALLED WITH A 6.7" INSET, CUSTOMER SIDE. REFER TO FURNITURE DEALER FOR PROPER INSET DIMENSIONS PER SPECIFIED DESK DEPTH	DESK DEPTH - 30" REAR DIMENSION - 6.7" FRONT DIMENSION - 19.5"		
FN-12	FILE STORAGE	HERMAN MILLER	MERIDIAN PEDESTALS STANDARD PULL MOBILE PEDESTAL	M16-15 OR 18- T1 STANDARD PULL MOBILE PEDESTAL (15" OR 18" WIDTHS),, 1" HIGH PAINTED METAL TOP W/SQUARE EDGE, BOX/FILE (18", 22" OR 28" DEEP) CABINET & PULL COLOR: SMOOTH PAINT ON SMOOTH STEEL(SS), (MS) METALLIC SILVER LOCK: STANDARD (STD)	SIZES VARY, SEE NOTES	SALES CONSULTATION, NEW SALES MANAGER, USED SALES MANAGER, SERVICE WRITE-UP, SERVICE MANAGER, OFFICE MANAGER, DEALER OFFICE, F & I OFFICE	CONTACT: LESLEY COLLETT-FELIX AT HERMAN MILLER: (614) 561-9778 NOTE: OWNER & FURNITURE DEALER TO PROVIDE/COORDINATE FURNITURE DIMENSIONS APPROPRIATE TO AUTO DEALER SIZE & VOLUME. ALL OWNER PROGRAMMING NEEDS ARE TO BE CONSIDERED. OWNER AND/OR ARCHITECT OF RECORD TO COORDINATE DESKING REQUIREMENTS (LIGHTING, HARDWARE, CORD & CABLE MANAGEMENT, WALL STRIP ATTACHMENTS, ACCESSORIES & STORAGE ETC.) WITH FURNITURE DEALER FOR EXACT SPECIFICATIONS & SITE SPECIFIC REQUIREMENTS. NOTE: ADDITIONAL OFFICE COMPONENTS, STORAGE, FILING, ETC. COULD BE ADDED FOLLOWING THE CANVAS SPECIFICATION GUIDELINES (STYLE, FABRIC, FINISHES) LISTED IN SCHEDULE. AUTO DEALER TO COORDINATE THESE ADDITIONAL NEEDS WITH THEIR LOCAL HERMAN MILLER DEALER NOTE: NATIONAL ACCOUNT PRICING HAS BEEN ESTABLISHED FOR THIS SPECIFICATION, PLEASE CONTACT LESLEY COLLETT-FELIX AT HERMAN MILLER FOR DETAILS.
FN-13	DESK SYSTEM *REQUIRED, SEE NOTES	HERMAN MILLER	CANVAS FURNITURE, SQUARE EDGE RECTANGULAR DESK WITH PLASTIC SCREEN	FTS10-30-72-LS-XX 30" X 72" SQUARE EDGE RECTANGULAR LAMINATE SURFACE W/STIFFNER (FV696.57) TOP FINISH: (COL) CUSTOMERS OWN LAMINATE NEVAMAR WOOD-GRAIN LAMINATE, WT0003PV VALENCIA TEAK, EDGE COLOR: (MT) ***SEE NOTES FOR CABLE MANAGEMENT	SIZES VARY, SEE NOTES 30" W X 72" L	MANAGER OFFICE, F & I OFFICE, GENERAL OFFICES, DEALER OFFICE	CONTACT: LESLEY COLLETT-FELIX AT HERMAN MILLER: (614) 561-9778 NOTE: OWNER & FURNITURE DEALER TO PROVIDE/COORDINATE FURNITURE DIMENSIONS APPROPRIATE TO AUTO DEALER SIZE & VOLUME. ALL OWNER PROGRAMMING NEEDS ARE TO BE CONSIDERED. OWNER AND/OR ARCHITECT OF RECORD TO COORDINATE DESKING REQUIREMENTS (LIGHTING, HARDWARE, CORD & CABLE MANAGEMENT, WALL STRIP ATTACHMENTS, ACCESSORIES & STORAGE ETC.) WITH FURNITURE DEALER FOR EXACT SPECIFICATIONS & SITE SPECIFIC REQUIREMENTS. A STIFFNER IS REQUIRED FOR SIZE OF WORK SURFACE NOTED. FOR OTHER WORK SURFACE SIZES, REFER TO HERMAN MILLER PLANNING GUIDE FOR STIFFNER REQUIREMENTS. NOTE: ADDITIONAL OFFICE COMPONENTS, STORAGE, FILING, ETC. COULD BE ADDED FOLLOWING THE CANVAS SPECIFICATION GUIDELINES (STYLE, FABRIC, FINISHES) LISTED IN SCHEDULE. AUTO DEALER TO COORDINATE THESE ADDITIONAL NEEDS WITH THEIR LOCAL HERMAN MILLER DEALER. NOTE: THIS IS A REQUIRED PIECE OF FURNITURE FOR THE KIA CBS PROGRAM, NO SUBSTITUTIONS ALLOWED. NOTE: NATIONAL ACCOUNT PRICING HAS BEEN ESTABLISHED FOR THIS SPECIFICATION, PLEASE CONTACT LESLEY COLLETT-FELIX AT HERMAN MILLER FOR DETAILS.
			SQUARE OPEN LEG SUPPORT - DESK	FV2D2-S-30-FL (INCLUDE RIGHT LEG)-MS FRAME: SQUARE OPEN LEG, PAINTED (MS) METALLIC SILVER, FIXED LEG			
			SCREEN	FV694-A-12A-66-39-MS SCREEN: TRANSLUCENT PLASTIC, OPAL FROSTED NOTE: SCREEN SHOULD BE INSTALLED WITH A 6.7" INSET, CUSTOMER SIDE. REFER TO FURNITURE DEALER FOR PROPER INSET DIMENSIONS PER SPECIFIED DESK DEPTH	DESK DEPTH - 30" REAR DIMENSION - 6.7" FRONT DIMENSION - 19.5"		
			CANVAS FURNITURE, BACK CREDENZA	FTS10-24-72-LS-XX 24" X 72" SQUARE EDGE RECTANGULAR LAMINATE SURFACE W/STIFFNER (FV696.57) TOP FINISH: (COL) CUSTOMERS OWN LAMINATE NEVAMAR WOOD-GRAIN LAMINATE, WT0003PV VALENCIA TEAK	SIZES VARY, SEE NOTES 24" W X 72" L		
			SQUARE OPEN LEG SUPPORT - BACK CREDENZA	FV2D2-S-24-FL (INCLUDE RIGHT LEG)-MS FRAME: SQUARE OPEN LEG, PAINTED (MS) METALLIC SILVER, FIXED LEG, INCLUDE BOTH RIGHT & LEFT LEG			
			CANVAS FURNITURE, OVERHEAD STORAGE CABINET, FULL ENCLOSURE	FV442-WM-15-72LAL-XX-91-XX-39 WALL MOUNTED, 15" X 60" OVERHEAD STORAGE CABINET, LOCK, KEYED TOP/CASE: (91) WHITE LAMINATE PRIMARY DOOR MATERIAL: (COL) CUSTOMERS OWN LAMINATE NEVAMAR WOOD-GRAIN LAMINATE, WT0003PV VALENCIA TEAK SECONDARY DOOR MATERIAL: (A) TRANSLUCENT PLASTIC (39) OPAL FROSTED	SIZES VARY, SEE NOTES		
			CANVAS FURNITURE, VERTICAL STORAGE CABINET	FV515-XX-XX-(R OR L)-L-L-XX-91-XX VERTICAL STORAGE CABINET, LOCK, KEYED CASE: (91) WHITE LAMINATE PRIMARY DOOR MATERIAL: (COL) CUSTOMERS OWN LAMINATE NEVAMAR WOOD-GRAIN LAMINATE, WT0003PV VALENCIA TEAK NOTE: HEIGHT, SHELIVING & WARDROBE LOCATION TO BE COORDINATED WITH DEALER THROUGH FURNITURE DEALER	SIZES VARY, SEE NOTES		
			CANVAS FILING & STORAGE, METAL LOW CREDENZA WITH DOORS	FM71-K-MS-XX-20-4-L-03-L-XS-91 METAL LOW CREDENZA WITH DOORS, LOCK, KEYED, ARC PULL TOP FINISH: 3/8" THICK LAMINATE (91) WHITE CASE: (91) WHITE TEXTURED PAINT ON SMOOTH STEEL PRIMARY DOOR MATERIAL: (COL) CUSTOMERS OWN LAMINATE NEVAMAR WOOD-GRAIN LAMINATE, WT0003PV VALENCIA TEAK BASE FINISH: (MS) METALLIC SILVER, 4" HEIGHT FOOT NOTE: DUE TO THE (COL) FINISH, THIS PIECE IS PART OF THE HERMAN MILLER OPTIONS PROGRAM, FURNITURE DEALER TO COORDINATE SPECIFICS THROUGH THE SALES REP.	SIZES VARY, SEE NOTES		
FN-14	BENCH	BERNHARDT DESIGN	BALANCE BENCH - LARGE	6867 FABRIC: FB-3, MOMENTUM TEXTILES, BRAVO 09064295 CINDER	63" W 20" D 18" H	SERVICE WRITE-UP	CONTACT: CHRISSIE DIXON AT BERNHARDT DESIGN (828) 759-6765 chrissiedixon@bernhardt.com COLEMAN GUTSHALL AT BERNHARDT DESIGN (828) 759-6539 colemangutshall@bernhardt.com NOTE: OWNER & FURNITURE DEALER TO PROVIDE/COORDINATE FURNITURE DIMENSIONS APPROPRIATE TO AUTO DEALER SIZE & VOLUME. ALL OWNER PROGRAMMING NEEDS ARE TO BE CONSIDERED. NOTE: NATIONAL ACCOUNT PRICING HAS BEEN ESTABLISHED FOR THIS SPECIFICATION, PLEASE CONTACT THE DORSEY GROUP FOR DETAILS.
			BALANCE BENCH - MEDIUM	6865 FABRIC: FB-3, MOMENTUM TEXTILES, BRAVO 09064295 CINDER	41.5" W 20" D 18" H		
			BALANCE BENCH - SMALL	6861 FABRIC: FB-3, MOMENTUM TEXTILES, BRAVO 09064295 CINDER	20.5" W 20" D 18" H		
FN-15	STOOL	HERMAN MILLER	CAPER MULTIPURPOSE, HEIGHT ADJUSTABLE, HIGH- STOOL, BASIC	WC1-21-P-BK-BK-C7-BK-6V02 CAPER OPTIONS HIGH-STOOL WITH FLEXNET SEAT, COLOR (6V02) SILVER GRAY ARM FINISH: (BK) BLACK, FRAME FINISH: (BK) BLACK, HARD FLOOR/CARPET CASTER *** THIS IS A NON-STANDARD PRODUCT, SEE NOTES	24.5" W 18 3/8" D 25"-34.5" SH	TECH LIBRARY, TECH PARTS, RETAIL PARTS, SERVICE WRITE-UP	CONTACT: LESLEY COLLETT-FELIX AT HERMAN MILLER: (614) 561-9778 NOTE: THE CAPER STOOL SPECIAL IS PART OF THE HERMAN MILLER OPTIONS PROGRAM, FURNITURE DEALER TO COORDINATE SPECIFICS THROUGH THE SALES REP.

NOTE: ALL FURNITURE TO BE PROVIDED BY OWNER UNLESS OTHERWISE NOTED



- Architectural Design
- Planning
- Interiors



Member of the American Institute of Architects



Lee D. Dixon, Jr., AIA
252-247-2121
lee@coastalarchitecture.net

4206 Bridges St. Ext., Suite C
Morehead City, NC 28557

www.CoastalArchitecture.net

NC074 KIA OF NEW BERN

NEW BERN, NORTH CAROLINA

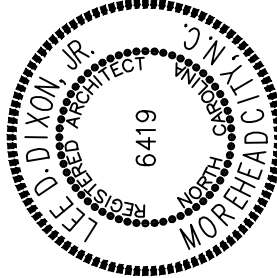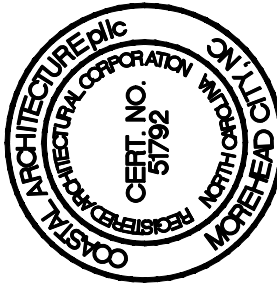

FURNITURE SCHEDULE

16034

ISSUED: 20 NOV 18

DWG BY: BLS, LSA

CKD BY:

REVISIONS

SHEET NO.

A-3.10
OF

P:\2018\16034 KIA of New Bern\GIBBS\A-111\DWG\16034 KIA of New Bern.dwg 11/20/2018 4:46:30 PM DWG 30 x 36" p3

CODE	MATERIAL	MANUFACTURER	DESCRIPTION			LOCATION	ADDITIONAL INFORMATION
			PRODUCT	COLOR	DIMENSION		
FN-15A *ADA OPTION	TASK CHAIR	HERMAN MILLER	CAPER MULTIPURPOSE CHAIR	WC1-21-P-BK-BK-BB-BK-6V02 CAPER MULTIPURPOSE CHAIR WITH FLEXNET SEAT, COLOR (6V02) SILVER GRAY ARM FINISH: (BK) BLACK, FRAME FINISH: (BK) BLACK, HARD FLOOR/CARPET CASTER	24.5" W 18 3/8" D 25"-34.5" SH	TECH LIBRARY, TECH PARTS, RETAIL PARTS, SERVICE WRITE-UP *ADA OPTION	CONTACT: LESLEY COLLETT-FELIX AT HERMAN MILLER: (614) 561-9778
FN-16	BREAKROOM TABLE	HERMAN MILLER	EVERYWHERE TABLES SQUARE TABLE	DT1B- 3636 -L -S SQUARE LAMINATE TABLE WITH SINGLE COLUMN BASE LAMINATE: (91) WHITE LEG FINISH: (MS) METALLIC SILVER	SIZES VARY, SEE NOTES 36" W X 36" D	BREAKROOM, TECH BREAKROOM	CONTACT: LESLEY COLLETT-FELIX AT HERMAN MILLER (614) 561-9778 NOTE: OWNER & FURNITURE DEALER TO PROVIDE/COORDINATE FURNITURE DIMENSIONS APPROPRIATE TO AUTO DEALER SIZE & VOLUME. ALL OWNER PROGRAMMING NEEDS ARE TO BE CONSIDERED. OWNER AND/OR ARCHITECT OF RECORD TO COORDINATE DESKING REQUIREMENTS (LIGHTING, HARDWARE, CORD & CABLE MANAGEMENT, WALL STRIP ATTACHMENTS, ACCESSORIES & STORAGE ETC.) WITH FURNITURE DEALER FOR EXACT SPECIFICATIONS & SITE SPECIFIC REQUIREMENTS.
FN-17	BREAKROOM CHAIR	HUMANSCALE	CINTO STACKING CHAIR	C-1-0-S-18 CINTO CHAIR, FOUR LEGS W/GLIDES, ARMLESS BACKREST/SEAT PAN: (18) LIGHT GRAY FRAME FINISH: (S) SILVER	17.8" W 21.13" D 35" H	BREAKROOM, TECH BREAKROOM	CONTACT: BRIAN LEE AT HUMANSCALE (714) 430-6850 EXT.3128 NOTE: FURNITURE DEALER TO COORDINATE SPECIFIC SEATING REQUIREMENTS & SEATING QUANTITIES WITH THE OWNER AND/OR ARCHITECT OF RECORD. ALL OWNER PROGRAMMING NEEDS ARE TO BE CONSIDERED.
FN-18	TABLE/DESK SYSTEM	HERMAN MILLER	CANVAS OFFICE LANDSCAPE, BEAM-BASED, BEAM SECTION, SINGLE SIDED	FW121-30-96-A-AN-MS 30" X 96", BEAM SECTION, SINGLE SIDED FW123-S IN-LINE BEAM CONNECTOR, SINGLE SIDED FW130-30L OR 30R-A-MS-MS-AN END SUPPORT, OPEN LEG BODY/CROSS BAR FINISH: (MS) METALLIC SILVER FW133-S-MS-MS MID-RUN SUPPORT, OPEN SUPPORT BODY/FACE FINISH: (MS) METALLIC SILVER FW150-XX-96 POWER HARNESS (SIZES MAY VARY, SEE NOTES) FWS10E-30-XX-L-A-91 RECTANGULAR SURFACE, END POSITION LAMINATE TOP SURFACE: (91) WHITE FWS10M-30-XX-L-A-91 RECTANGULAR SURFACE, MIDDLE POSITION LAMINATE TOP SURFACE: (91) WHITE	SIZES VERY, SEE NOTES	BUSINESS DEVELOPMENT CENTER/INTERNET OFFICE	CONTACT: LESLEY COLLETT-FELIX AT HERMAN MILLER (614) 561-9778 NOTE: OWNER & FURNITURE DEALER TO PROVIDE/COORDINATE FURNITURE DIMENSIONS APPROPRIATE TO AUTO DEALER SIZE & VOLUME. ALL OWNER PROGRAMMING NEEDS ARE TO BE CONSIDERED. OWNER AND/OR ARCHITECT OF RECORD TO COORDINATE DESKING REQUIREMENTS (LIGHTING, HARDWARE, CORD & CABLE MANAGEMENT, WALL STRIP ATTACHMENTS, ACCESSORIES & STORAGE ETC.) WITH FURNITURE DEALER FOR EXACT SPECIFICATIONS & SITE SPECIFIC REQUIREMENTS. NOTE: ADDITIONAL OFFICE COMPONENTS, STORAGE, FILING, ETC. COULD BE ADDED FOLLOWING THE CANVAS SPECIFICATION GUIDELINES (STYLE, FABRIC, FINISHES) LISTED IN SCHEDULE. AUTO DEALER TO COORDINATE THESE ADDITIONAL NEEDS WITH THEIR LOCAL HERMAN MILLER DEALER NOTE: NATIONAL ACCOUNT PRICING HAS BEEN ESTABLISHED FOR THIS SPECIFICATION, PLEASE CONTACT LESLEY COLLETT-FELIX AT HERMAN MILLER FOR DETAILS.
FN-19	SERVICE WRITE-UP POTIUM						THE SERVICE WRITE-UP PODIUMS HAVE BEEN REVISED AND ARE REQUIRED TO BE PURCHASED THROUGH EWI. PLEASE CONTRACT EILEEN DYER
FN-20	CONFERENCE TABLE	DESKMAKERS	CONFERENCE COLLECTION TABLE TOP	CF-REC1-SPCL-B1 RECTANGULAR CONFERENCE TABLE TOP - 1 PIECE, 1-1/8" THICK, 3/8" RADIUS WOOD EDGE **NEVAMAR WT003PV VALENCIA TEAK** OP-HPL1-25 HPL CONFERENCE TABLE TOP, TRAINING TABLE TOP, OR SHOWROOM STANDARD TOPS ONLY	SIZES VARY AS NEEDED 42"D X 108"W	CONFERENCE ROOM	CONTACT: RODENDECK AND ASSOCIATES JUSTIN RODENDECK AT JUSTINR@RODENDECK.COM OR 310-980-1429/310-559-3900
			CONFERENCE COLLECTION TABLE BASE	CF-BBOT-2-20: BOATSHAPED BASE FOR TABLES OP-HPL1-30: HPL PANEL, RECTANGULAR, AND SQUARE CONFERENCE TABLE BASES	SIZES VARY AS NEEDED 42" X 84", 42" X 96", 48" X 96", 48" X 120" 1-PIECE 2-BASES (9" X 20")		
			CONFERENCE COLLECTION ACCESSORIES	OP-CONF-715/31/2016: UPGRADE KICKPLATE TO SILVER METALLIC, WHITE, OR MATCHING PVC FINISH CF-WMST-SPCL5/31/2016: ADD WIRE MANAGEMENT STRETCHER TROUGH TO 108" ONE-PIECE TABLES OP-HPL1-4: HPL ENTIRE TROUGH OP-CONF-57: ADD WIRE ACCESS DOOR TO BOATSHAPE BASE ACDPGR-70-SM: RECESSED POWER (2 WORK SURFACE, 1 BELOW)/DATA (TELECOM PLATE NOT INCLUDED). SILVER METALLIC POWDER COAT FINISH. AX-DPGR-ABB: INTERFACE PLATE - QTY 2 RJ45 CAT 6 -- 1 RJ11 PHONE CONNECTORS	QUANTITIES VARY AS NEEDED *FURTHER DETAILS WITH MANUFACTURER		
FN-21	WORKSTATION W/ RETURN	HERMAN MILLER	CANVAS FURNITURE, SQUARE EDGE RECTANGULAR DESK W/ RETURN	FTS10-30-60-LS-XX 30" X 60" SQUARE EDGE RECTANGULAR LAMINATE SURFACE W/STIFFNER TOP FINISH: (COL) CUSTOMERS OWN LAMINATE NEVAMAR WOOD-GRAIN LAMINATE, WT0003PV VALENCIA TEAK ***SEE NOTES FOR CABLE MANAGEMENT	SIZES VARY, SEE NOTES 30" W X 60" L	SERVICE MANAGER	CONTACT: LESLEY COLLETT-FELIX AT HERMAN MILLER (614) 561-9778 NOTE: OWNER & FURNITURE DEALER TO PROVIDE/COORDINATE FURNITURE DIMENSIONS APPROPRIATE TO AUTO DEALER SIZE & VOLUME. ALL OWNER PROGRAMMING NEEDS ARE TO BE CONSIDERED. OWNER AND/OR ARCHITECT OF RECORD TO COORDINATE DESKING REQUIREMENTS (LIGHTING, HARDWARE, CORD & CABLE MANAGEMENT, WALL STRIP ATTACHMENTS, ACCESSORIES & STORAGE ETC.) WITH FURNITURE DEALER FOR EXACT SPECIFICATIONS & SITE SPECIFIC REQUIREMENTS. A STIFFNER IS REQUIRED FOR SIZE OF WORK SURFACE NOTED. FOR OTHER WORK SURFACE SIZES, REFER TO HERMAN MILLER PLANNING GUIDE FOR STIFFNER REQUIREMENTS.
			SQUARE OPEN LEG SUPPORT - DESK	FV2D2-S-30-FL-MS FRAME: SQUARE OPEN LEG, PAINTED (MS) METALLIC SILVER, FIXED LEG			
			SQUARE EDGE RECTANGULAR RETURN SURFACE	FTS10-24-60-L-S-XX 24" X 60" SQUARE EDGE RECTANGULAR LAMINATE SURFACE W/STIFFNER TOP FINISH: (COL) CUSTOMERS OWN LAMINATE NEVAMAR WOOD-GRAIN LAMINATE, WT0003PV VALENCIA TEAK, EDGE COLOR: (MT) ***SEE NOTES FOR CABLE MANAGEMENT	SIZES VARY, SEE NOTES		NOTE: ADDITIONAL OFFICE COMPONENTS, STORAGE, FILING, ETC. COULD BE ADDED FOLLOWING THE CANVAS SPECIFICATION GUIDELINES (STYLE, FABRIC, FINISHES) LISTED IN SCHEDULE. AUTO DEALER TO COORDINATE THESE ADDITIONAL NEEDS WITH THEIR LOCAL HERMAN MILLER DEALER NOTE: NATIONAL ACCOUNT PRICING HAS BEEN ESTABLISHED FOR THIS SPECIFICATION, PLEASE CONTACT LESLEY COLLETT-FELIX AT HERMAN MILLER FOR DETAILS.
FN-22	KIDS FURNITURE	LINEA INC.	TATINO (SPHERICAL)	RT-ED860 FABRIC: MALAGA, 4174 COCCINELLA	19 1/8" DIA 17 1/8" H	KIDS AREA	CONTACT: SHERI CHARRON AT LINEA INC. (310) 273-5425 NOTE: PLEASE ALLOW FOR A 12-14 WEEK LEAD TIME WHEN ORDERING. ARCHITECT OF RECORD TO COORDINATE CURRENT FABRIC SELECTIONS THROUGH LINEA INC. AND/OR LOCAL FURNITURE DEALER.
			TATONE (BAGEL)	RT-ED870 FABRIC: MALAGA, 9200 SQUALO	30 3/4" DIA 14 1/4" H		
			TATO (EGG)	RT-ED855 FABRIC: MALAGA, 9199 MASTICE	17 1/4" W 25 3/4" D 16 1/4" H		
FN-23	NOT USED						

NOTE: ALL FURNITURE TO BE PROVIDED BY OWNER UNLESS OTHERWISE NOTED



- Architectural Design
- Planning
- Interiors



Member of the American
Institute of Architects



Lee D. Dixon, Jr., AIA
262-247-2121
lee@coastalarchitecture.net

4206 Bridges St. Ext.,
Suite C
Morehead City, NC
28557

www.CoastalArchitecture.net

NC074 KIA OF NEW BERN

NEW BERN, NORTH CAROLINA

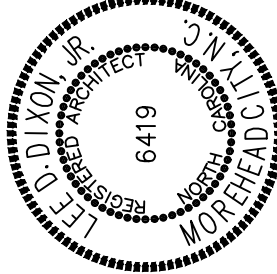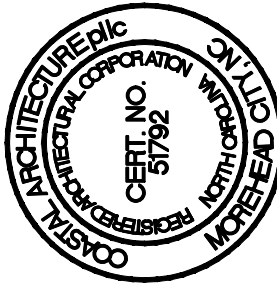

FURNITURE SCHEDULE

16034

ISSUED: 20 NOV 18

DWG BY: BLS, LSA

CKD BY:

REVISIONS

SHEET NO.

A-3.11
OF

P:\2018\16034 KIA of New Bern\GIBBS\A-12 FURNITURE SCHEDULE.dwg 11/20/2018 4:46:02 PM DWG To PDF.plt

CODE	MATERIAL	MANUFACTURER	DESCRIPTION			LOCATION	ADDITIONAL INFORMATION
			PRODUCT	COLOR	DIMENSION		
FN-24	TASK SEATING *REQUIRED, SEE NOTES	HUMANSCALE	WORLD TASK CHAIR, ADJUSTABLE DURON ARMS, WHITE FRAME, CATENA POPPY SEED BACK, LOTUS WHITE K128, STANDARD 5" CYLINDER, STANDARD CASTER, STANDARD PLASTICS, BASE CAPS W/ WHITE FRAME, CARTON PACKAGING	W11WJ1AK128 ARMS: HEIGHT ADJUSTABLE DURON ARMS FRAME FINISH:(W) WHITE BACKREST: (J1A) CATENA, COLOR: POPPY SEED SEAT: K-128, LOTUS WHITE	21.1" W 16.5"-20" D 36.5"-41.5" H 16"-21" SH	RECEPTION	CONTACT: LINDA C. TONG AT HUMANSCALE (714) 430-6850 EXT. 3129 NOTE: FURNITURE DEALER TO COORDINATE SPECIFIC SEATING REQUIREMENTS & SEATING QUANTITIES WITH THE OWNER AND/OR ARCHITECT OF RECORD. ALL OWNER PROGRAMMING NEEDS ARE TO BE CONSIDERED. NOTE: OPTIONAL FEATURES FOR REQUIRED SEATING (PNEUMATIC, TILT MECHANISM, ARM PADS ETC.) COULD BE ADDED FOLLOWING THE DIFFERENT WORLD CHAIR SPECIFICATION GUIDELINES (STYLE, FABRIC, FINISHES) LISTED IN SCHEDULE. AUTO DEALER TO COORDINATE THESE ADDITIONAL NEEDS WITH THEIR LOCAL FURNITURE DEALER OR SALES REP. NOTE: THIS IS A REQUIRED PIECE OF FURNITURE FOR THE KIA CBS PROGRAM, NO SUBSTITUTIONS ALLOWED. NOTE: NATIONAL ACCOUNT PRICING HAS BEEN ESTABLISHED FOR THIS SPECIFICATION, PLEASE CONTACT ELIZABETH EWING AT HUMANSCALE FOR DETAILS.
FN-25	WORKSTATION	HERMAN MILLER	CANVAS WALL BASED WORK STATIONS WITH TRANSACTION TOP	PANEL - PART# FT110.3542X FRAME, NO BASE COVERS 35H 42W PANEL - PART# FT128.35 CONNECTION HARDWARE, FRAME-TO-FRAME 35H PANEL - PART# FT160.35BP FINISHED END, BASE COVER PTD 35H, (MS) METALLIC SILVER PANEL - PART# FT963.42JTF SINGLE SIDED BASE COVER KIT, PWR/DATA KNOCKOUTS, ATTACHMENT TO-THE-FLOOR TILES ON (1) SIDE 42W, (MS) METALLIC SILVER PANEL - PART# FT162.42 POWER ENTRY, RETROFIT BASE COVER 42W, (MS) METALLIC SILVER PANEL - PART# FT140.06 POWER ENTRY, EXTERNAL DIRECT CONNECT 6' LONG, (LZ) PVC FREE PANEL - PART# FT150.42 BASE POWER HARNESS 42W, (LZ) PVC FREE PANEL - PART# FT152.42 POWER HARNESS, LOWER PWR/DATA TILE 42W, (LZ) PVC FREE PANEL - PART# FT154.2 POWER JUMPER 36" LONG, (LZ) PVC FREE PANEL - PART# FT155.A 15 AMP RECEPTACLE 4 CIRCUIT , DUPLEX, CIRCUIT A 6/PKG, (CL) COOL GREY NEUTRAL PANEL - PART# FT155.D 15 AMP RECEPTACLE 4 CIRCUIT, DUPLEX, CIRCUIT D ISOLATED GROUND 6/PKG, (CL) COOL GREY NEUTRAL PANEL - PART# SA542723 VARY EASY TO-THE-FLOOR EXTENDED-WIDTH LOWER TILE, STANDARD PRODUCT REFERENCE - #FT376V.3584LHXMSMT MODIFIED PRODUCT REFERENCE - #FT376V.3584L**MSMT LAMINATE FINISH: NEVAMAR WT0003PV VALENCIA TEAK LAMINATE HORIZONTAL BEAD FINISH: (MS) METALLIC SILVER, EDGE FINISH: (MT) MEDIUM TONE PANEL - PART# FT171.3042C TILE, LOWER PWR/DATA, PWR/DATA CUT BELOW WS, PTD 30H 42W, (MS) METALLIC SILVER, (MS) METALLIC SILVER, (CL)COOL GREY NEUTRAL	SIZES VERY, SEE NOTES	SALES MANAGER	CONTACT: LESLEY COLLETT-FELIX AT HERMAN MILLER (614) 561-9778 NOTE: OWNER & FURNITURE DEALER TO PROVIDE/COORDINATE FURNITURE DIMENSIONS APPROPRIATE TO AUTO DEALER SIZE & VOLUME. ALL OWNER PROGRAMMING NEEDS ARE TO BE CONSIDERED. OWNER AND/OR ARCHITECT OF RECORD TO COORDINATE DESKING REQUIREMENTS (LIGHTING, HARDWARE, CORD & CABLE MANAGEMENT, WALL STRIP ATTACHMENTS, ACCESSORIES & STORAGE ETC.) WITH FURNITURE DEALER FOR EXACT SPECIFICATIONS & SITE SPECIFIC REQUIREMENTS. A STIFFNER IS REQUIRED FOR SIZE OF WORK SURFACE NOTED. FOR OTHER WORK SURFACE SIZES, REFER TO HERMAN MILLER PLANNING GUIDE FOR STIFFNER REQUIREMENTS. NOTE: NATIONAL ACCOUNT PRICING HAS BEEN ESTABLISHED FOR THIS SPECIFICATION, PLEASE CONTACT LESLEY COLLETT-FELIX AT HERMAN MILLER FOR DETAILS.
			TRANSACTION TOP	PART# FT280.84LP TRANSACTION SURFACE, SQ-EDGE LAMINATE SURFACE, PTD STANDARD TOP CAP 84W, (8Q) FOLKSTONE GREY, (MS) METALLIC SILVER, (MS) METALLIC SILVER, (LD) STACKING ON 35", 46", 57", 68", 79" BASE FRAME			
			WORKSURFACE	PART# FTS10.2484LF, RECTANGULAR SURFACE, SQUARE-EDGE, LAMINATE TOP/VINYL EDGE, 24D 84W, FRAME ATTACHMENT, (8Q) FOLKSTONE GRAY			
			OPEN SUPPORT LEG - LEFT	PART# FT294.24L OPEN SUPPORT, TAPPERED FOOT, FRAME ATTACHED, LEFT-HAND, 24D, (MS) METALLIC SILVER			
			OPEN SUPPORT LEG - RIGHT	PART# FT294.24R OPEN SUPPORT, TAPPERED FOOT, FRAME ATTACHED, RIGHT-HAND, 24D, (MS) METALLIC SILVER			
			LATERAL FILE	PART# LK20D.303 LATERAL FILE, BAR PULL FREESTANDING, PTD, METAL FRONT, (3) DRAWER 30W, (SS) SMOOTH PAINT ON SMOOTH STEEL, (8Q) FOLKSTONE GREY, (KA) KEYED ALIKE, (MS) METALLIC SILVER, (CB) COUNTERWEIGHT, (1R) FORNT-TO-BACK FILING RAIL PART# SA542610 VARY EASY TU FILE TOP, STANDARD PRODUCT REFERENCE - #LTPLV-09020HXMT MODIFIED PRODUCT REFERENCE - #LTPLV-09020 TOP/EDGE MATERIAL: LV, LAMINATE TOP W/THERMOPLASTIC EDGE WIDTH: 090:90" WIDE, DEPTH: 20:20" DEEP LAMINATE FINISH: NEVAMAR WT0003PV VALENCIA TEAK LAMINATE HORIZONTAL BEAD FINISH: (MS) METALLIC SILVER, EDGE FINISH: (MT) MEDIUM TONE			
			MOBILE PEDESTAL	PART# LK11D.24BBF PEDESTAL, BAR PULL, MOBILE, PTD, METAL FRONT, 24D B/B/F, (SB) FULL-EXTENSION BALL-BEARING, (SS) SMOOTH PAINT ON SMOOTH STEEL, (8Q) FOLKSTONE GREY, (KA) KEYED ALIKE, (MS) METALLIC SILVER, (NN) NONE,(H1) HAND GRIP ONLY			

NOTE: ALL FURNITURE TO BE PROVIDED BY OWNER UNLESS OTHERWISE NOTED



- Architectural Design
- Planning
- Interiors



Member of the American
Institute of Architects



Lee D. Dixon, Jr., AIA
252-247-2121
lee@coastalarchitecture.net

4206 Bridges St. Ext.,
Suite C
Morehead City, NC
28557

www.CoastalArchitecture.net

NC074 KIA OF NEW BERN

NEW BERN, NORTH CAROLINA

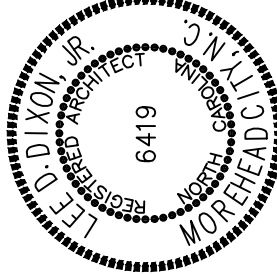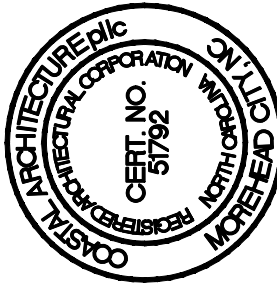

FURNITURE SCHEDULE

16034

ISSUED: 20 NOV 18

DWG BY: BLS, LSA

CKD BY:

REVISIONS

SHEET NO.

A-3.12
OF

P:\2018\16034 Kia of New Bern\GIBBNET\A-11 EXTERIOR FINISH-FC000016.dwg 11/02/2018 14:07:19 PM DWG:33 PPS:03

CODE	MATERIAL	MANUFACTURER	DESCRIPTION			LOCATION	ADDITIONAL INFORMATION
			PRODUCT	COLOR	DIMENSION		
CC-1	COLORED CONCRETE	LM SCOFIELD	CHROMIX ADMIXTURES FOR COLOR CONDITIONED CONCRETE	1266 COOL GRAY BROOM FINISH	4'X4' SCORE MARKS	ENTRY WALKWAY	CONTACT: ROBERT E. KRAUSKOPF AT LM SCOFIELD COMPANY (800) 800-9900 NOTE: REFER TO MANUFACTURERS SALES REPRESENTATIVE FOR APPROPRIATE PRODUCTS & INSTALLATION RECOMMENDATIONS. NOTE: CONTRACTOR TO CHOOSE SEALING AGENT -CURASEAL - (W) OR (S) BASED ON STATE REQUIREMENTS
CC-2	COLORED CONCRETE	LM SCOFIELD	CHROMIX ADMIXTURES FOR COLOR CONDITIONED CONCRETE	C-34 DARK GRAY BROOM FINISH		ENTRY WALKWAY STRIPING	
CF-1	CAP FLASH	BY ADJACENT MATERIAL MANUFACTURER		COLOR TO MATCH ADJACENT SURFACE			CONTACT DAVID J. KEARNEY AT ALPOLIC (757) 382-5724
CMU-1	CONCRETE MASONRY UNIT	ANCHOR CONCRETE PRODUCTS (OLDCASTLE ARCHITECTURAL BRAND)	ANCHOR SPLIT FACE BLOCK	L-15 NOTE: USE WITH LEHIGH MASONRY CEMENT, COLOR L-15	8" X 16" STANDARD SPLT FACE BLOCK, NO RIBBING	EXTERIOR PERIMETER OF BUILDING	CONTACT: STEVEN EASTER AT ANCHOR CONCRETE PRODUCTS, INC. (908) 415-8445 OR CONTACT: DAVID JAYE AT AT ANCHOR CONCRETE PRODUCTS, INC. (908) 415-5740 NOTE: FOR PRODUCT SUBSTITUTION REFER TO OLDCASTLE ARCHITECTURAL PRODUCTS. NOTE: REFER TO MANUFACTURERS SALES REPRESENTATIVE FOR APPROPRIATE PRODUCTS, INSTALLATION RECOMMENDATIONS AND PRODUCT SUBSTITUTIONS BASED ON REGION.
D-1	MAN DOOR/ VEHICLE DOOR	PITTCO ARCHITECTURAL METALS, INC. OR EQUAL	STANDARD NARROW STILE CENTER HUNG DOOR	#63 BLACK FINISH GLASS & ALUMINUM	PAIR 3070-MAIN ENTRY; PAIR 4070-VEHICLE ACCESS (8' OPENING)	SHOWROOM	CONTACT: PITTCO ARCHITECTURAL METALS (800) 992-7488
D-2	NOT USED						
D-3	ROLLING OVERHEAD PARTS RECEIVING DOOR 591 SERIES	SEE DOOR SCHEDULE SHEET		NO GLAZING PAINT: SEE EP-1		PARTS RECEIVING	
D-4	MAN DOOR	PITTCO ARCHITECTURAL METALS, INC. OR EQUAL	STANDARD NARROW STILE CENTER HUNG DOOR	#63 BLACK FINISH GLASS & ALUMINUM	3070	SHOWROOM	CONTACT: PITTCO ARCHITECTURAL METALS (800) 992-7488
D-5	ROLLING OVERHEAD DOOR SERIES 591	SEE DOOR SCHEDULE SHEET		PROVIDE SINGLE BAND OF GLASS PAINT TO MATCH	SEE DRAWING FOR SIZE	SERVICE BAYS	
D-6	SOLID MAN DOOR	SEE DOOR SCHEDULE SHEET		PAINT: BENJAMIN MOORE, EXTERIOR RM CHARCOAL SLATE - SEE EP-1			
DP-2	DOOR PULL ASSEMBLY	TRIMCO HARDWARE	KIA CAST DOOR PULL	BRUSHED ALUMINUM	8" X 8.1" (EACH PULL PER DOOR LEAF)	PRIMARY ENTRY DOORS DOOR 101A	CONTACT: JASON BENNET (323) 262-4191 OFFICE, 949-702-3526 CELL EMAIL: JBENNET@TRIMCOHARDWARE.COM WWW.TRIMCOHARDWARE.COM
DEFS	DIRECT APPLIED EXTERIOR FINISH SYSTEM	DUROCK DEFS		DIRECT APPLIED EXTERIOR FINISH SYSTEM			CONTACT: 1-800-238-6345 www.info@durock.com
EP-1	EXTERIOR PAINT	BENJAMIN MOORE	SUPER SPEC HP DTM ACRYLIC LOW LUSTER P25	EXTERIOR READY MADE CHARCOAL SLATE		EXTERIOR METAL DOORS	CONTACT: JASON WALKER AT BENJAMIN MOORE (773) 597-8698
EP-3	EXTERIOR PAINT	BENJAMIN MOORE	SUPER SPEC HP DTM ACRYLIC LOW LUSTER P25	STERLING SILVER		METAL SIDING- SEE ELEVATIONS ON A-4	CONTACT: JASON WALKER AT BENJAMIN MOORE (773) 597-8698
GL-4	EXTERIOR GLAZING	PPG INDUSTRIES OR EQUAL	ARCHITECTURAL GLASS	ZONES 1,2 & 3: PPG SOLARBAN R100 CLEAR VISIBLE TRANSMITTANCE = 42% ZONES 4-8: PPG SOLARBAN 60 CLEAR VISIBLE TRANSMITTANCE = 70%		GENERAL	CONTACT: BOB SCHROCK AT PPG INDUSTRIES (513) 543-2555
MP-1	METAL PANEL	ALPOLIC	DRY JOINT SYSTEM	4MMSAW SAW WHITE	50/62" W X 196" L	EXTERIOR FACADE MAIN FIELD	CONTACT DAVID J. KEARNEY AT ALPOLIC (757) 382-5724 NOTE: FOR NATIONAL ACCOUNT PRICING PLEASE CONTACT VENDOR ABOVE
MP-2	METAL PANEL	ALPOLIC	DRY JOINT SYSTEM	4MMOPT MICA PLATINUM	50/62" W X 148/196" L	EXTERIOR COLUMNS, EXTERIOR CANOPY	CONTACT DAVID J. KEARNEY AT ALPOLIC (757) 382-5724
MP-3	METAL PANEL	ALPOLIC	DRY JOINT SYSTEM	4MMRON RON RED	50" W X 196" L 62" W X 183" L	BOTTOM OF CANOPIES	CONTACT DAVID J. KEARNEY AT ALPOLIC (757) 382-5724
PEMB-1	METAL PANEL			NUCOR CLASSIC WALL 26 GA METAL BUILDING PANELS			
SF-1	STOREFRONT	PITTCO ARCHITECTURAL METALS, INC.	TMW 450 & TMW 450 EFG	ANODIZED BLACK FINISH #63		EXTERIOR SHOWROOM FACADE	SEE WINDOW SCHEDULE
SF-2	STOREFRONT	PITTCO ARCHITECTURAL METALS, INC.	SEE WINDOW SCHEDULE	CLEAR ANODIZED FINISH #42		INTERIOR STOREFRONT FRAMING	SEE WINDOW SCHEDULE
SG-1	SPANDREL GLASS	PPG INDUSTRIAL OR EQUAL	ARCHITECTURAL GLASS		SEE WINDOW SCHEDULE	SHOWROOM FACADE	

THESE DRAWING AND SPECIFICATIONS REPRESENT AN INSTRUMENT OF SERVICE AND AS SUCH SHALL REMAIN IN OWNERSHIP WITH THE ARCHITECT. USE OR REPRODUCTION BY ANY MEANS, IN WHOLE OR IN PART, WITHOUT THE ARCHITECT'S WRITTEN CONSENT, IS PROHIBITED.



- Architectural Design
- Planning
- Interiors



Member of the American
Institute of Architects



Lee D. Dixon, Jr., AIA
252-247-2127
lee@coastalarchitecture.net

4206 Bridges St. Ext.,
Suite C
Morehead City, NC
28557

www.CoastalArchitecture.net

NC074 KIA OF NEW BERN

NEW BERN, NORTH CAROLINA

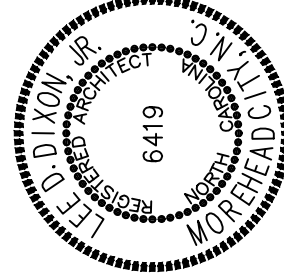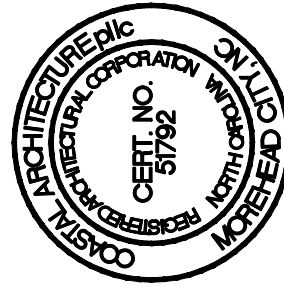

EXTERIOR FINISH
SCHEDULE

16034

ISSUED: 20 NOV 18

DWG BY: BLS, LSA

CKD BY:

REVISIONS


SHEET NO.

A-3.13
OF

G4.0 – Not Used		
G5.0 – Customer 360 Wall Graphic	Size: 60"w x 45"h	
G6.0, G6.1 and G6.2 – Service Bay Banner Graphics	Size: 144"w x 48"h	GRAPHICS TO BE PROVIDED BY OWNER












RESOURCE CONTACTS	
REQUIRED VENDORS	OPTIONAL RESOURCES
Fixtures / Interior Graphics: All fixtures and interior graphics are provided exclusively by EWI Worldwide. For information, contact: Mark Nelson ph: 949-614-7159 mnelson@ewiworldwide.com or Eileen Dyer ph: 414-277-6327 EDyer@ewiworldwide.com Front Facade Branding Element / Exterior Graphics: Front facade branding element and exterior graphics are provided exclusively by Pattison Sign Group. Contact Ed Mackle for information. ph: 865-693-1105 x132 cell: 865-228-4688 emackle@pattisonsign.com	Kids Furniture: Kidzpace Interactive, Inc. Contact: Tom McCarthy ph: 800-668-0206 www.kidzpace.com People Friendly Places ph: 800-369-6331 www.peoplefriendlyplaces.com Synergy Management ph: 504-837-8494 fax: 504-831-0057 email: info@synergysafety.com www.synergysafety.com Window Treatments: KMA & Associates Contact: Deb Mak ph: 614-563-0569 MechoSystems ph: 718-729-2020 fax: 718-729-2941 customerservice@mechosystems.com Inside Outfitters ph: 800-742-3372 info@insideoutfitters.com Lumenomics ph: 206-327-9037 411@lumenomics.com V-Kool ph: 800-SUN-2HOT www.v-kool-usa.com Kids Furniture: Broadway Equipment Company Contact: Harry Schleeter ph: 800-328-7434 fax: 612-529-0028 email: harry@broadwayequipment.com Furniture Solutions: The Wells Group Contact: Brad Wells ph: 713-464-5700 / 512-833-9000 email: brad@furnitureforbusiness.com www.furnitureforbusiness.com Interior Environments Contact: Marc Cygan ph: 248-996-6232 / c: 734-320-2692 email: mcygan@ieoffices.com www.ieoffices.com Haworth Contact: Leslie Levinski ph: 949-424-9340 email: leslie.levinski@haworth.com www.haworth.com Pivot Interiors Contact: Brian Ogden ph: 657-232-9318 / cell: 714-904-3943 email: bogden@pivotinteriors.com www.pivotinteriors.com www.pivotkiacbs.com Lighting Solutions: Commercial Lighting industries Contact: Farren Halcovich ph: 800-755-0155 / 760-831-9815 www.commercial-lighting.net Solar Panels: Onyx Solar Solar powered glazing Contact: Felipe Victoria ph: 917-261-4783 email: fvictoria@onyxsolar.com www.onyx solar.com Service Department: Autoplan Plus Contact: Gordon Manock, CEO ph: 905-331-8454 email: Gordon@autoplanplus.com www.autoplanplus.com Snap-On Business Solutions Contact: Adam Pisz, National Accounts Manager ph: 330-659-1678 / 714-316-6795 email: adam.j.pisz@snapon.com sbs.snapon.com Construction Materials: Construction Building Components (CBC) ph: 614-358-7800 email: orders@constructionbuildingcomponents.com www.constructionbuildingcomponents.com

NC074 KIA OF NEW BERN
NEW BERN, NORTH CAROLINA

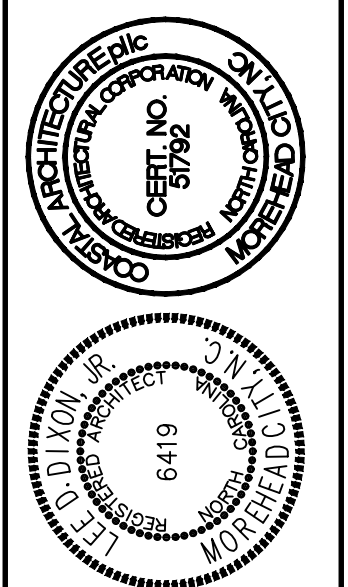

FIXTURE SCHEDULE SIGNAGE/GRAPHICS	
16034	
ISSUED: 20 NOV 18	
DWG BY: BLS, LSA	
CKD BY:	
REVISIONS	
SHEET NO.	
A-3.14	
OF	

          P:\2016\16034 KIA of New Bern\GILLBURN-A-111\Light Fixture Schedule.dwg, 11/20/2018 4:48:59 PM, DWG To PDF.plt

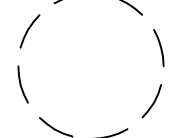LIGHT FIXTURE SCHEDULE / LEGEND - LED										
Symbol	Label	Catalog Number	Description/Location	Lamp	Watts	Symbol	Label	Catalog Number	Description/Location	Watts
	F1, F2	LSI PEC22 LED SS RAD NW UE DIM FINELITE HPR A 2X2 DCO LEDHO 4000K NOTE MAKE SURE THAT APPROPRIATE FRAME-IN KIT OR FLANGE KIT IS INCLUDED FOR DRYWALL CEILING APPLICATIONS COORDINATE T-BAR SIZE FOR PROPER MOUNTING DETAILS	Grid Ceiling Recessed Fluorescent <i>Offices, Consultation</i>	4000K LED	XX		F15	LSI ADL6 LED 20 NW UE C I100 AMERLUX E4.75R-A14 36 LED VOLTS E4.75RLD-A14 CLC VWF 4000 PHILIPS LIGHTOLIER C6L 20 N VOLTS COMFORT CLEAR TRIM, POLISHED FLANGE	Recessed Downlight <i>Hallways, Restrooms</i>	32
	F3	INTENSE IHOL 6AR L2 40 VOLTS 30 IRA600 C SF WILA 623 864 SA40 80 VOLTS	Recessed ADJUSTABLE FLOOD DISTRIBUTION <i>Vehicle Delivery and to Spotlight BRAND WALL LOGO where ceiling is 12' or less</i>	3200 LU LED	48		F17	LSI ADL6 LED 20 NW UE C I100 AMERLUX E4.75R-A14 36 LED VOLTS E4.75RLD-A14 CLC VWF 4000 WILA 665 7 6 4 SSA65 80	Recessed Downlight <i>Service Lounge, Internet Cafe, Conference Room</i>	40
	F4	Amerlux Lighting E4.75RA-16 LED-VOLT-FL-4000/E4.75RA-SDC WILA 623 5 6 4 SA40 80 Cree ESA ADR 6 14 C NDADJ SSGC FF 35K	Recessed LED <i>Retail Display</i>	LED	16					
	F5, F6,F18	SHAPER 600 SERIES 24" Sconce 600-24-2-L3/830-UNV-SN BROWNLEE 5025 24 NT E20LED 30K	<i>Restrooms</i>	2000 LU, 3000K LED	19		F19	LSI PMX LED VHO NW UE DIM TCH10 PHILIPS DAYBRITE FBX 16L L 40 UNV	Suspended <i>Service Bays</i>	16,000 LU 4000K LED 165
							F20	LSI EG3 4 S LED HO NW UE 45° BRACKET TCH10 PHILIPS DAYBRITE DWA E 65L 840 4 UNV	Suspended <i>Service Bays</i>	6500 LU, 4000K LED 65
							F21	ACOLYTE RBNL4023 4.4 35 F FEELUX DIVA 2 LSI LXC2	Concealed Ambient <i>Focal Vehicle Accent wall</i>	LED 4.4 W/F
	F7, F9	LSI DW LED HO NW UE PHILIPS DAYBRITE LF 4 EZ 38 40 U LAG PHILIPS DAYBRITE OWL 4 4000 840 UNIV	Wrap <i>Storage, Parts</i>	LED	XX		F23, F24	LSI ADL6 LED 28 NW UE C I100 PHILIPS LIGHTOLIER C7L 50 N VOLTS VB 4000K, MEDIUM BEAM COMFORT CLEAR TRIM, POLISHED FLANGE	Recessed Downlight <i>General Showroom Lighting, Service Reception</i>	6000 LU 4000K LED 70
	F8, F14	AMERLUX MESA-GRID WITH 38W FIATO LED RSA COMBOLIGHT BLACK HOUSING AND TRIM Contact: Tracie Jahn at Amerlux Lighting email: tjahn@amerlux.com phone:562-756-4734	Recessed channel - multiple Downlight <i>Showroom Vehicle Display Brand Wall</i>	4000K LED	XX					
	F11	Bonbonne <i>Provide suspension for 96" AFF mounting</i> Contact: Sheri Charron at Linea, Inc email: sheri@linea-inc.com phone 310 273 5425	Pendant <i>Lounge, Reception</i>	E26 75W 25° Spot	75		FX1	LSI XIG B LED 19 350 CW UE FL40 GPT SST	In Grade Uplight <i>Site</i>	LED XX
	F12	VIVO FR37507 BNI BRUSHED NICKEL FINISH HINKLEY LIGHTING <i>Suspend @ 90" AFF</i>	Pendant <i>Cafe tables, Service Write-up</i>	LED EDISON VINTAGE FILAMENT	4		F25	INTENSE IHOL 6AR L3 40 VOLTS 30 IRA600 C SF	Recessed ADJUSTABLE SPOT distribution <i>to Spotlight BRAND WALL LOGO For use where ceiling exceeds 12'</i>	LED XX
	F13	PREMIERE LUMINAIRE GLOBE LIGHTING CPBL36 (14' AND HIGHER CEILINGS) 30" DIA, BRUSHED NICKEL GLOBE LIGHTINIG CBPL26 (10'-12' CEILINGS) 24" DIA, BRUSHED NICKEL	Pendant <i>Feature Vehicle</i>	(36) 1.5W (G4) LED THIS WEIGHS 160 LBS (24) 1.5W (G4) LED THIS WEIGHS 110 LBS	54 36	NOTES: LED PRODUCTS ARE AVAILABLE IN A MULTITUDE OF COLOR TEMPERATURES, BEAM SPREADS AND LUMEN OUTPUT PACKAGES. THE AOR SHALL SPECIFY PRODUCTS THAT ARE APPROPRIATE FOR THE CEILING HEIGHTS AND TO PROVIDE A HIGH QUALITY INSTALLATION. WHERE MULTIPLE MANUFACTURERS/PRODUCTS ARE LISTED, EITHER IS ACCEPTABLE FOR USE AS APPROPRIATE. WHERE ONLY A SINGLE MANUFACTURER IS LISTED, PROVIDE THAT PRODUCT. SUBSTITUTES WILL NOT BE ALLOWED UNLESS APPROVED IN WRITING BY IBDF GENERALLY, ALL COLOR TEMPERATURES SHALL BE 4000K; EXCEPT RESTROOM SCONCES ARE 3000K. ALL CRIs SHALL EXCEED 80 ALL RECESSED DOWNLIGHTS ARE SELF-FLANGED; NO WHITE TRIM RINGS ALLOWED!				
THIS FIXTURE MUST BE ORDERED DIRECTLY FROM PREMIERE LIGHTING GILL SHAMIR 877 264 4277 X 5000										

Coastal

Architecture

• Architectural Design

• Planning

• Interiors

AIA

Member of the American Institute of Architects


Lee D. Dixon, Jr., AIA
252-247-2121
lee@coastalarchitecture.net

4206 Bridges St. Ext., Suite C
Morehead City, NC 28557

www.CoastalArchitecture.net

NC074 KIA OF NEW BERN

NEW BERN, NORTH CAROLINA

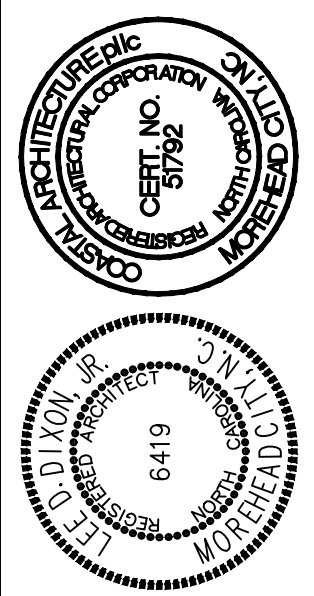

LIGHT FIXTURE SCHEDULE

16034

ISSUED: 20 NOV 18

DWG BY: BLS, LSA


CKD BY:

REVISIONS

SHEET NO.

A-3.15

OF

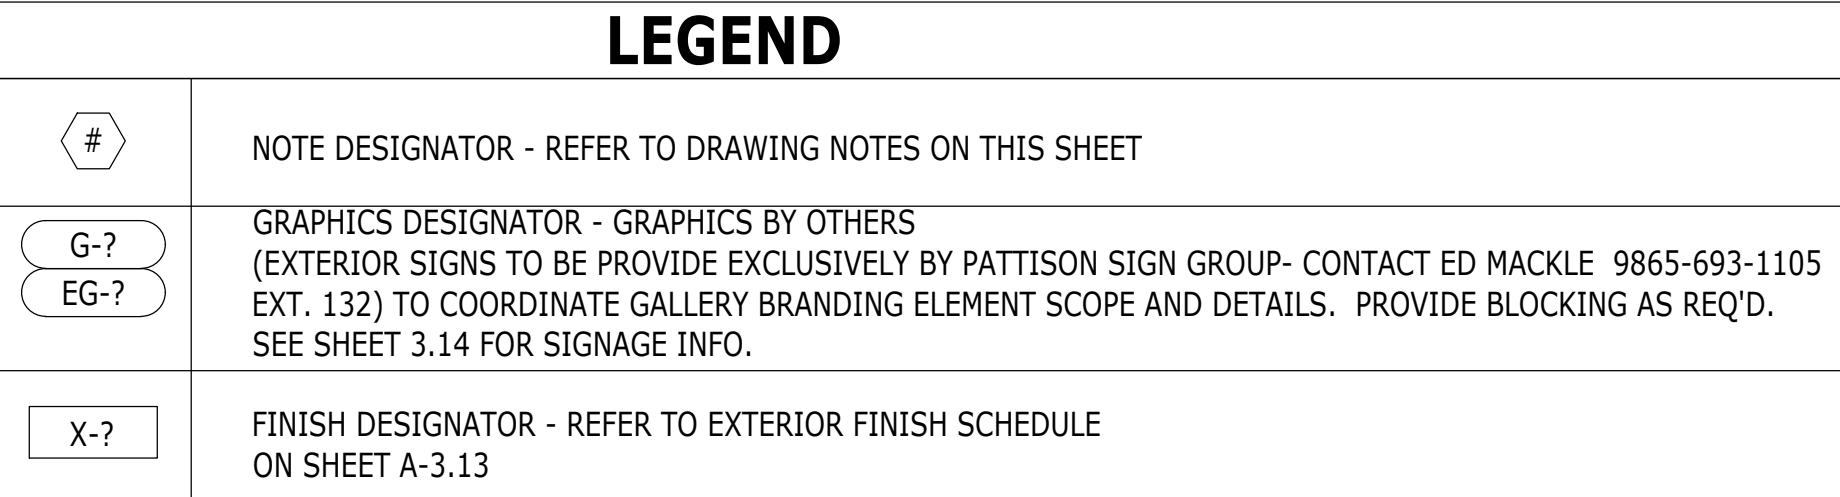

4
A-4



3
A-4



A-4 SCALE: 1/8" = 1'-0"



A-4 SCALE: 1/8" = 1'-0"

NOTES:

A. ALL EXTERIOR SITE AND BUILDING MOUNTED LIGHT FIXTURES ARE TO BE AN ANODIZED BLACK FINISH

B. PAINT NEW EXTERIOR BOLLARDS
P-6 CRIMSON RED PER INTERIOR FINISH SCHEDULE.

DRAWING NOTES

1. METAL COPING.
2. PROVIDE LIGHTING.
3. VEHICLE ACCESS DOORS.
4. METAL PANEL JOINT.
5. INSTALL DP-2 AT PRIMARY ENTRANCE PER EXTERIOR FINISH SCHEDULE.

NOTES:

A. ALL EXTERIOR SITE AND BUILDING MOUNTED LIGHT FIXTURES ARE TO BE AN ANODIZED BLACK FINISH

B. PAINT NEW EXTERIOR BOLLARDS
P-6 CRIMSON RED PER INTERIOR FINISH SCHEDULE

Coastal
Architecture
PLLC

- **Architectural Design**
- **Planning**
- **Interiors**





**Member of the American
Institute of Architects**

Lee D. Dixon, Jr., AIA
252-247-2127
lee@coastalarchitecture.net

**4206 Bridges St. Ext.,
Suite C
Morehead City, NC
28557**

www.CoastalArchitecture.net

NC074 KIA OF NEW BERN
NEW BERN, NORTH CAROLINA

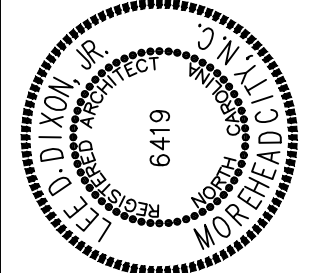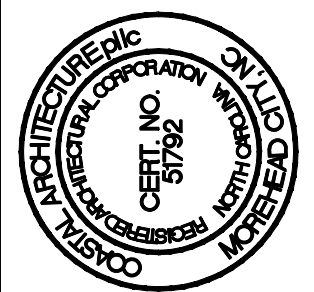

EXTERIOR
ELEVATIONS

16034

ISSUED: 20 NOV 18

DWG BY:	BLS, LSA
---------	----------


REVISIONS

SHEET NO.


A-4
OF

OF


THESE DRAWING AND SPECIFICATIONS REPRESENT AN INSTRUMENT OF SERVICE AND AS SUCH SHALL REMAIN IN OWNERSHIP WITH THE ARCHITECT. USE OR REPRODUCTION BY ANY MEANS, IN WHOLE OR IN PART, WITHOUT THE ARCHITECT'S WRITTEN CONSENT, IS PROHIBITED.

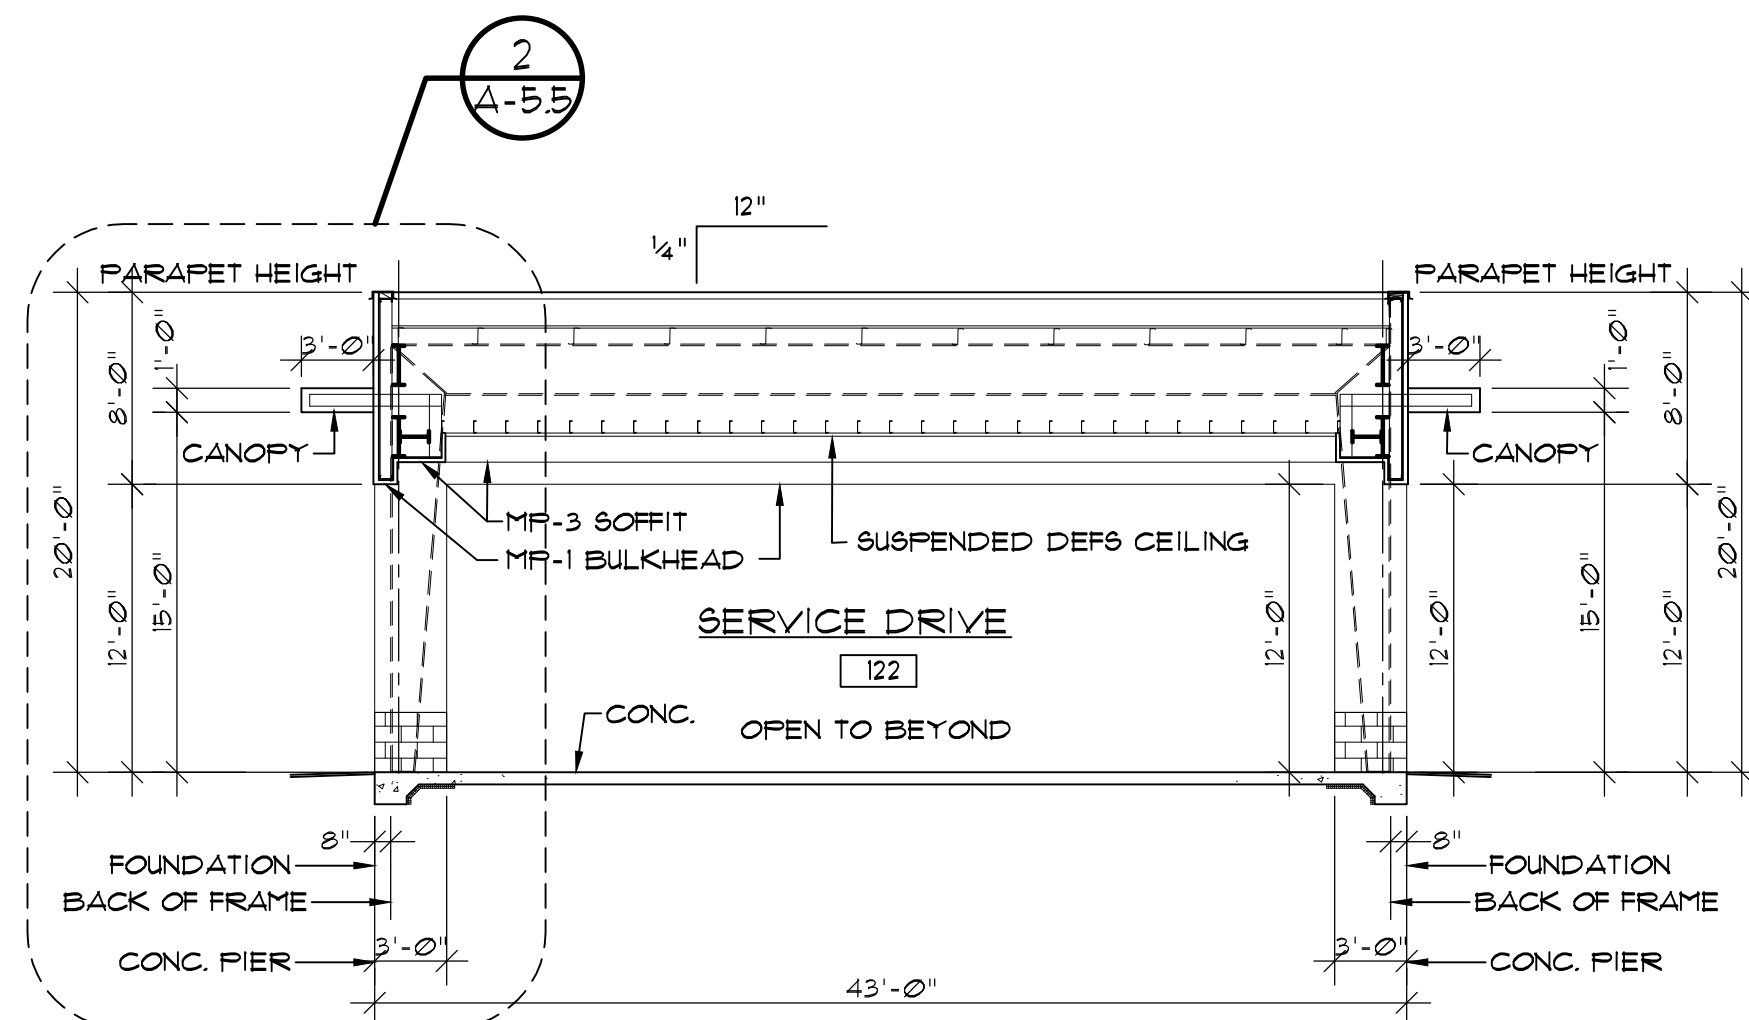


2
A-5.5
SCHEMATIC
SERVICE DRIVE SECTION
SCALE: 1/8" = 1'-0"

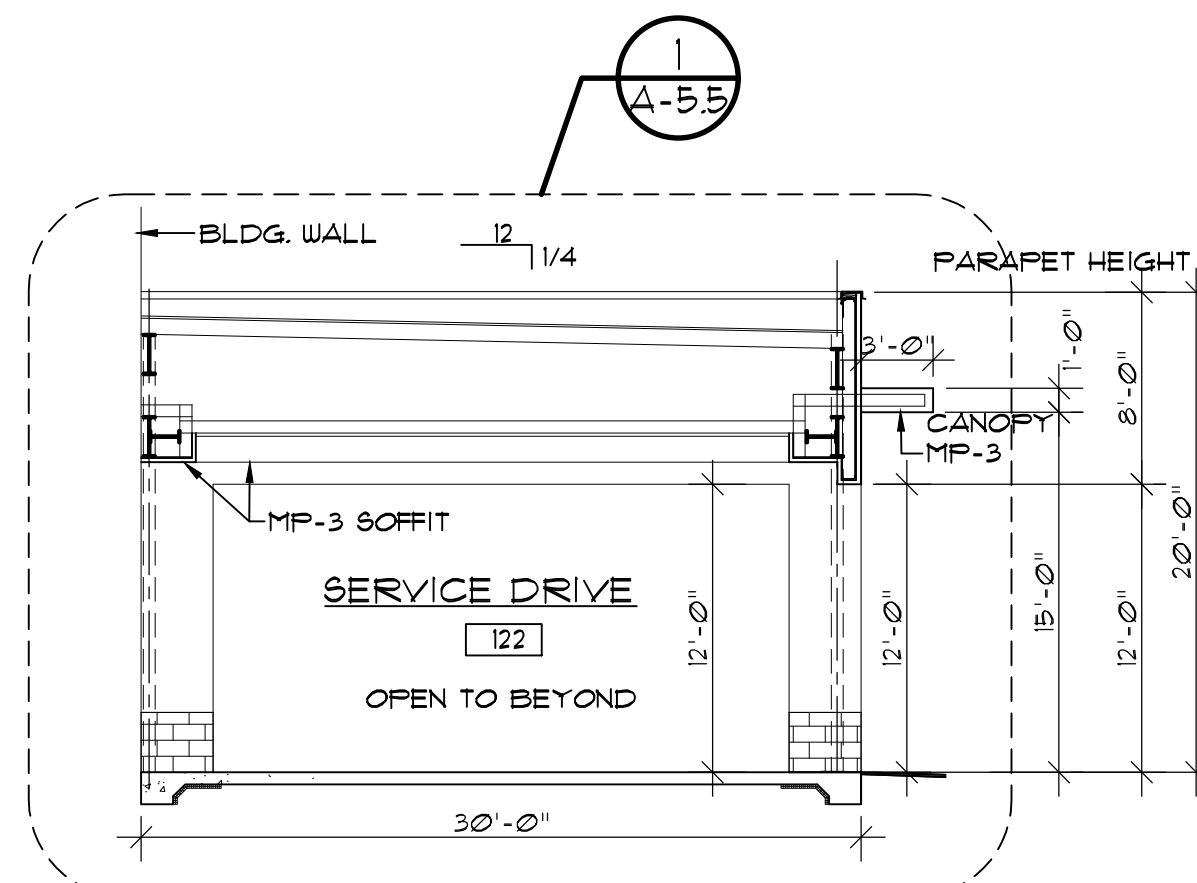


3
A-5
SCHEMATIC
SERVICE DRIVE SECTION
SCALE: 1/8" = 1'-0"

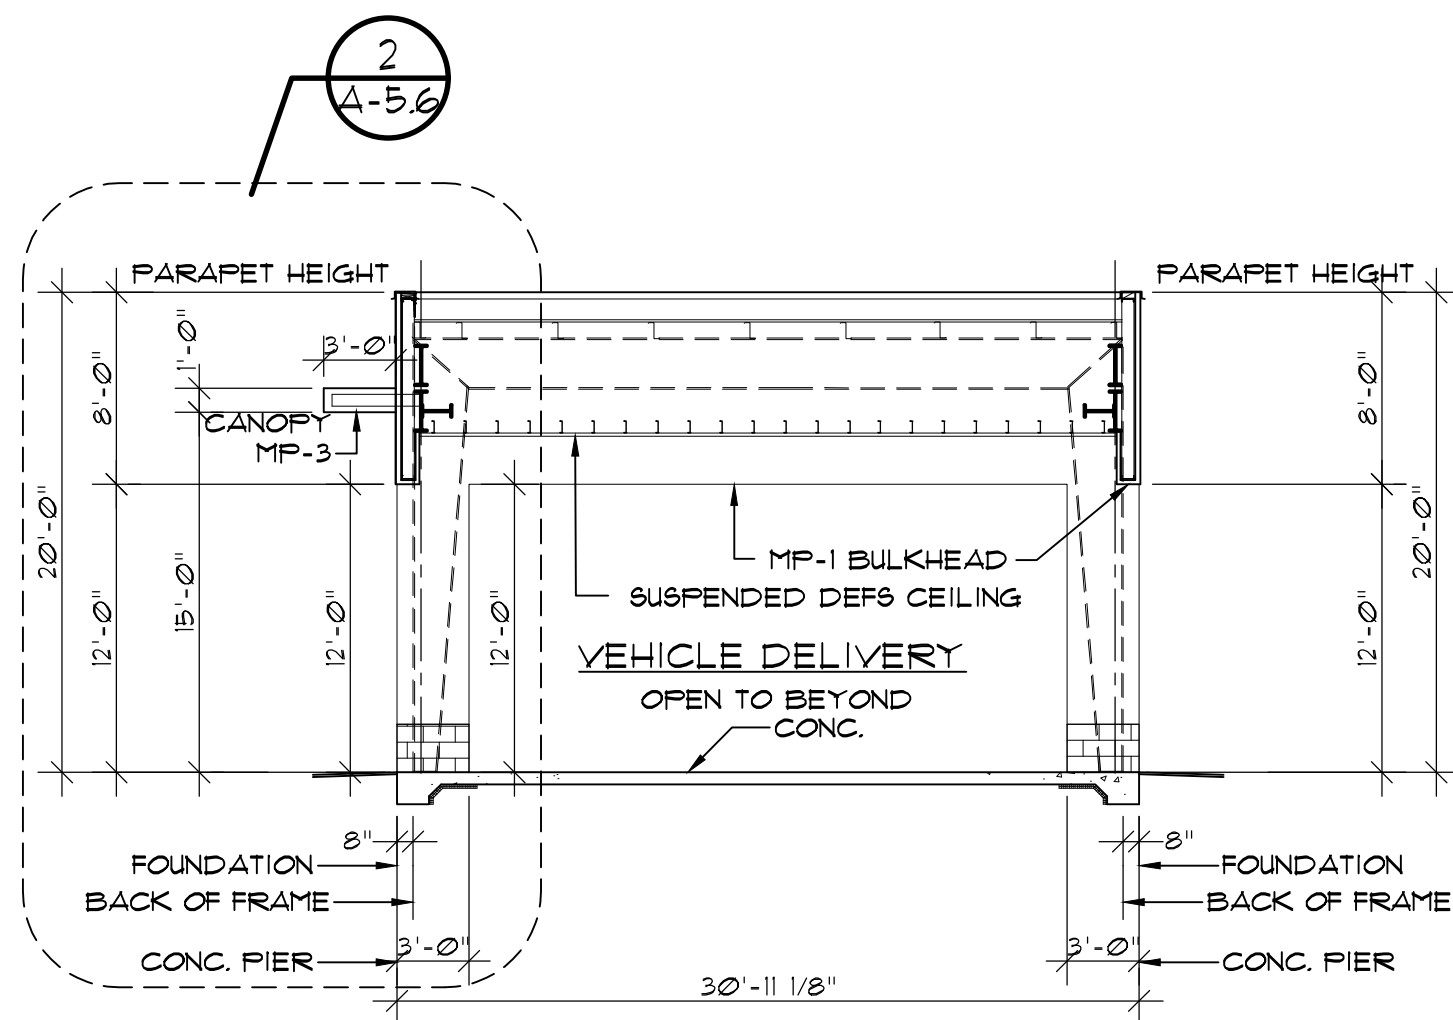

4
A-5
SCHEMATIC
VEHICAL DELIVERY SECTION
SCALE: 1/8" = 1'-0"

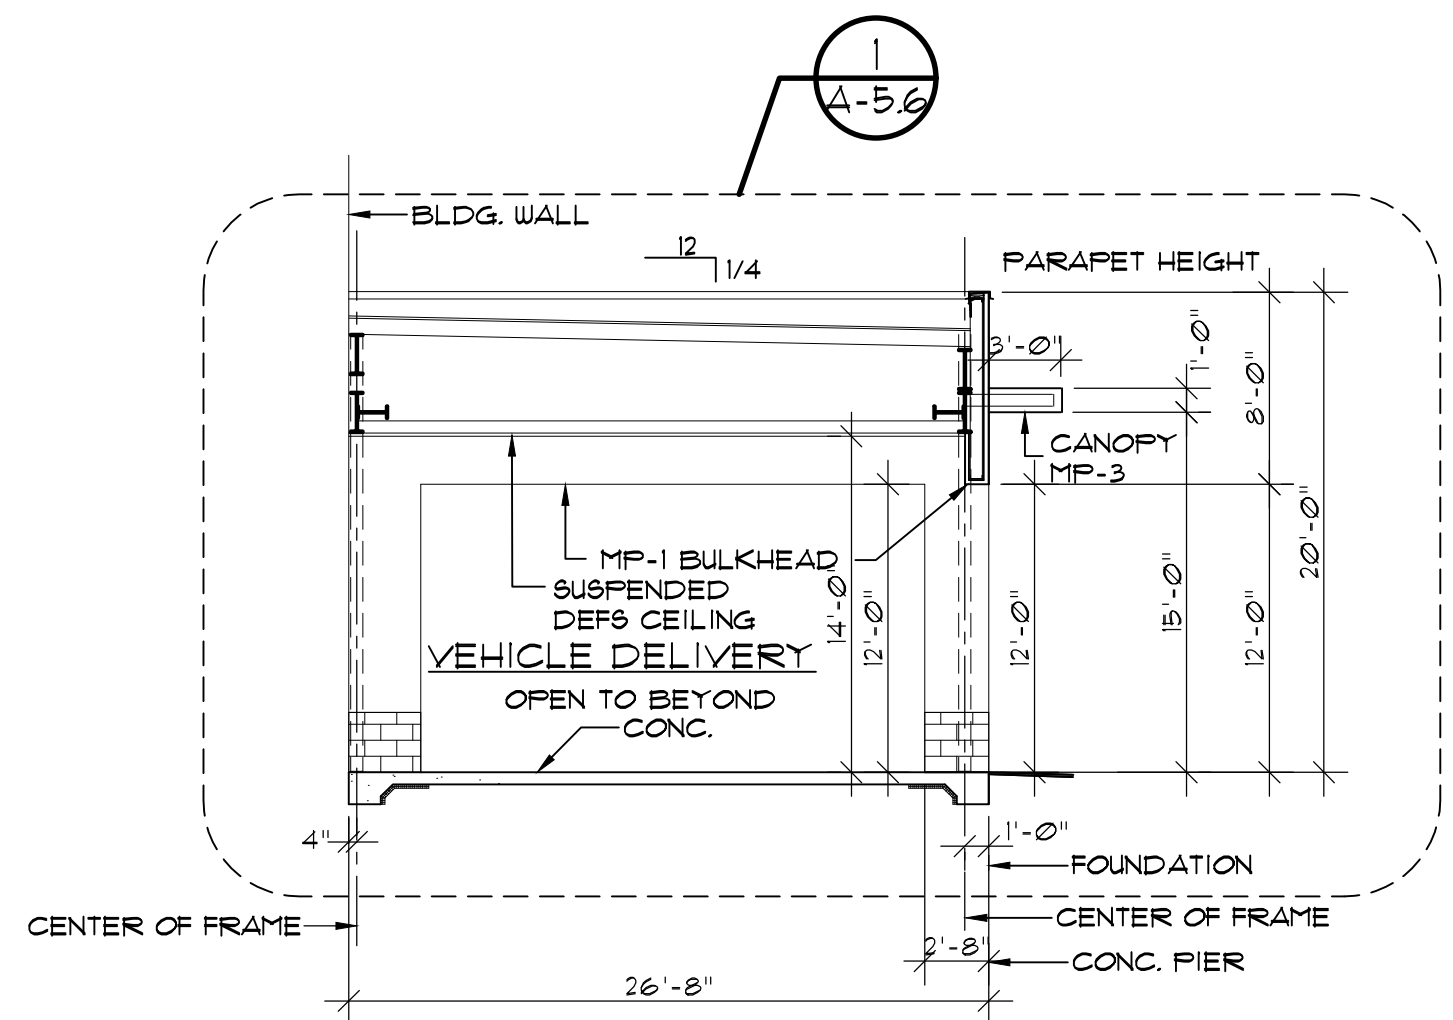

5
A-5
SCHEMATIC
VEHICAL DELIVERY SECTION
SCALE: 1/8" = 1'-0"

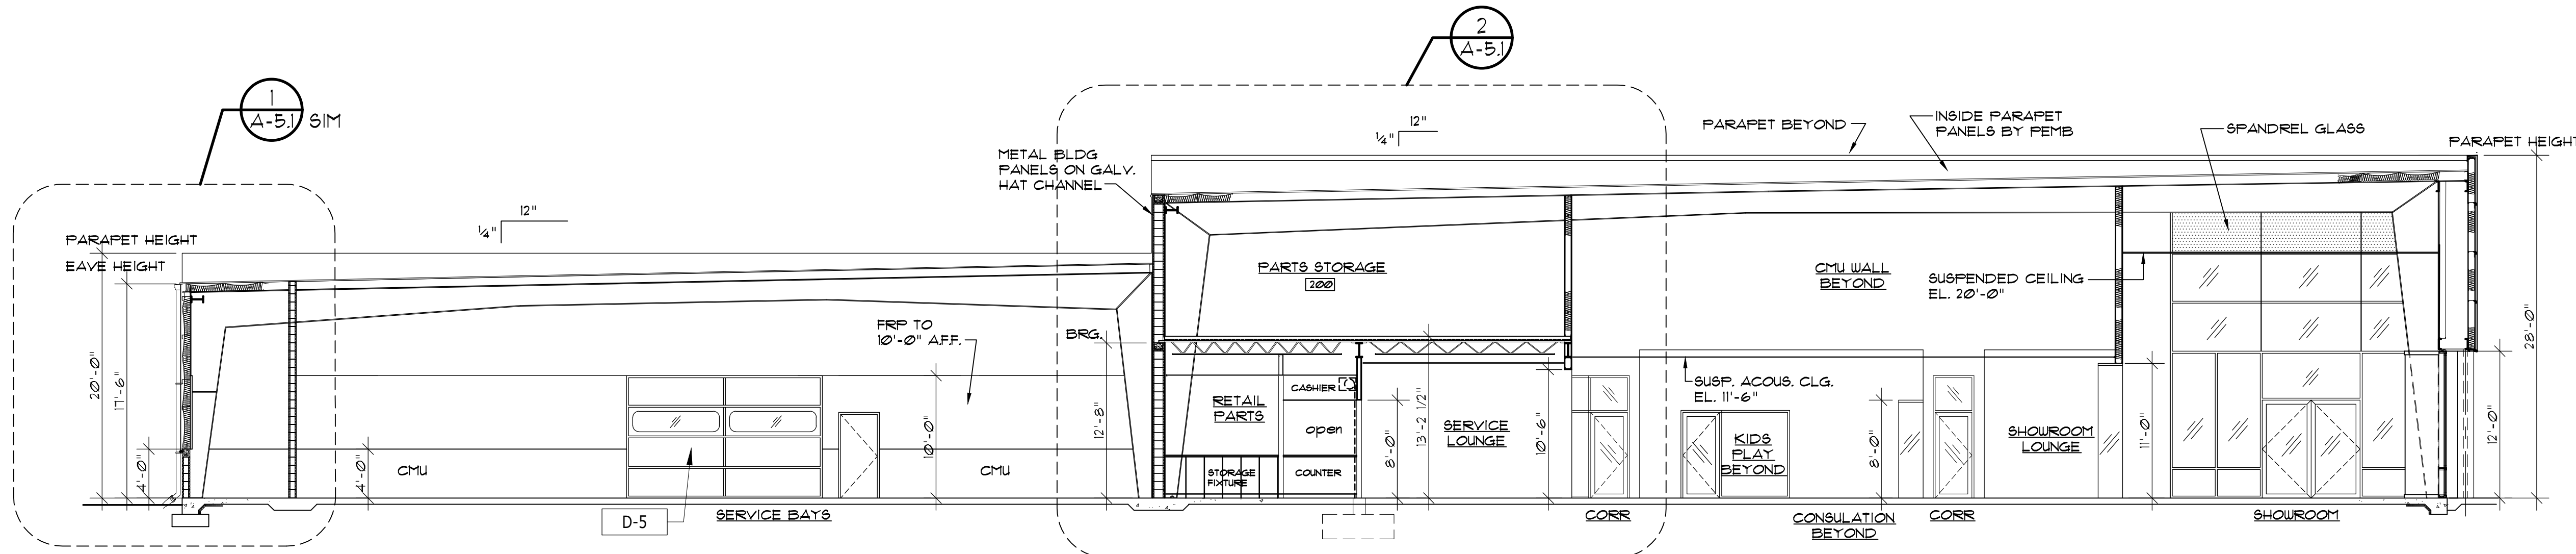

1
A-5
SCHEMATIC LONGITUDINAL
BUILDING SECTION
SCALE: 1/8" = 1'-0"





SUED: 20 NOV 18
WG BY: BLS, LSA
D BY: LDD
VISIONS

SHEET NO.
A-5.1
OF



NC074 KIA OF NEW BERN
NEW BERN, NORTH CAROLINA

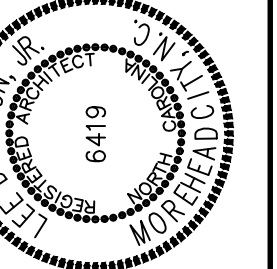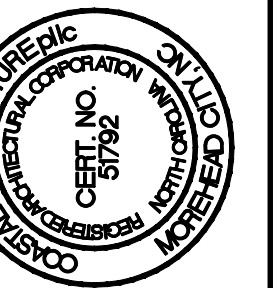

L SECTIONS

6034

BY: LDD
BY: BLS, LSA
BY: 20 NOV 18

VISIONS

SHEET NO.

A-5.2
OF






D. Dixon, Jr., AIA
252-247-2127
coastalarchitecture.net

**16 Bridges St. Ext
Suite C
Morehead City, NC
28557**

www.CoastalArchitecture.net

NC074 KIA OF NEW BERN
NEW BERN, NORTH CAROLINA

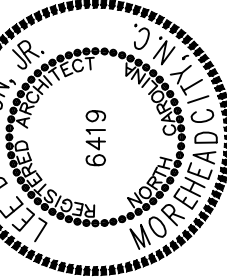

LOCAL SECTIONS

6034

ED: 20 NOV 18

BY: BLS, LS

DISCUSSION

--	--

--	--

--	--

--	--



--	--

SHEET NO.


52

A-5.5


OF

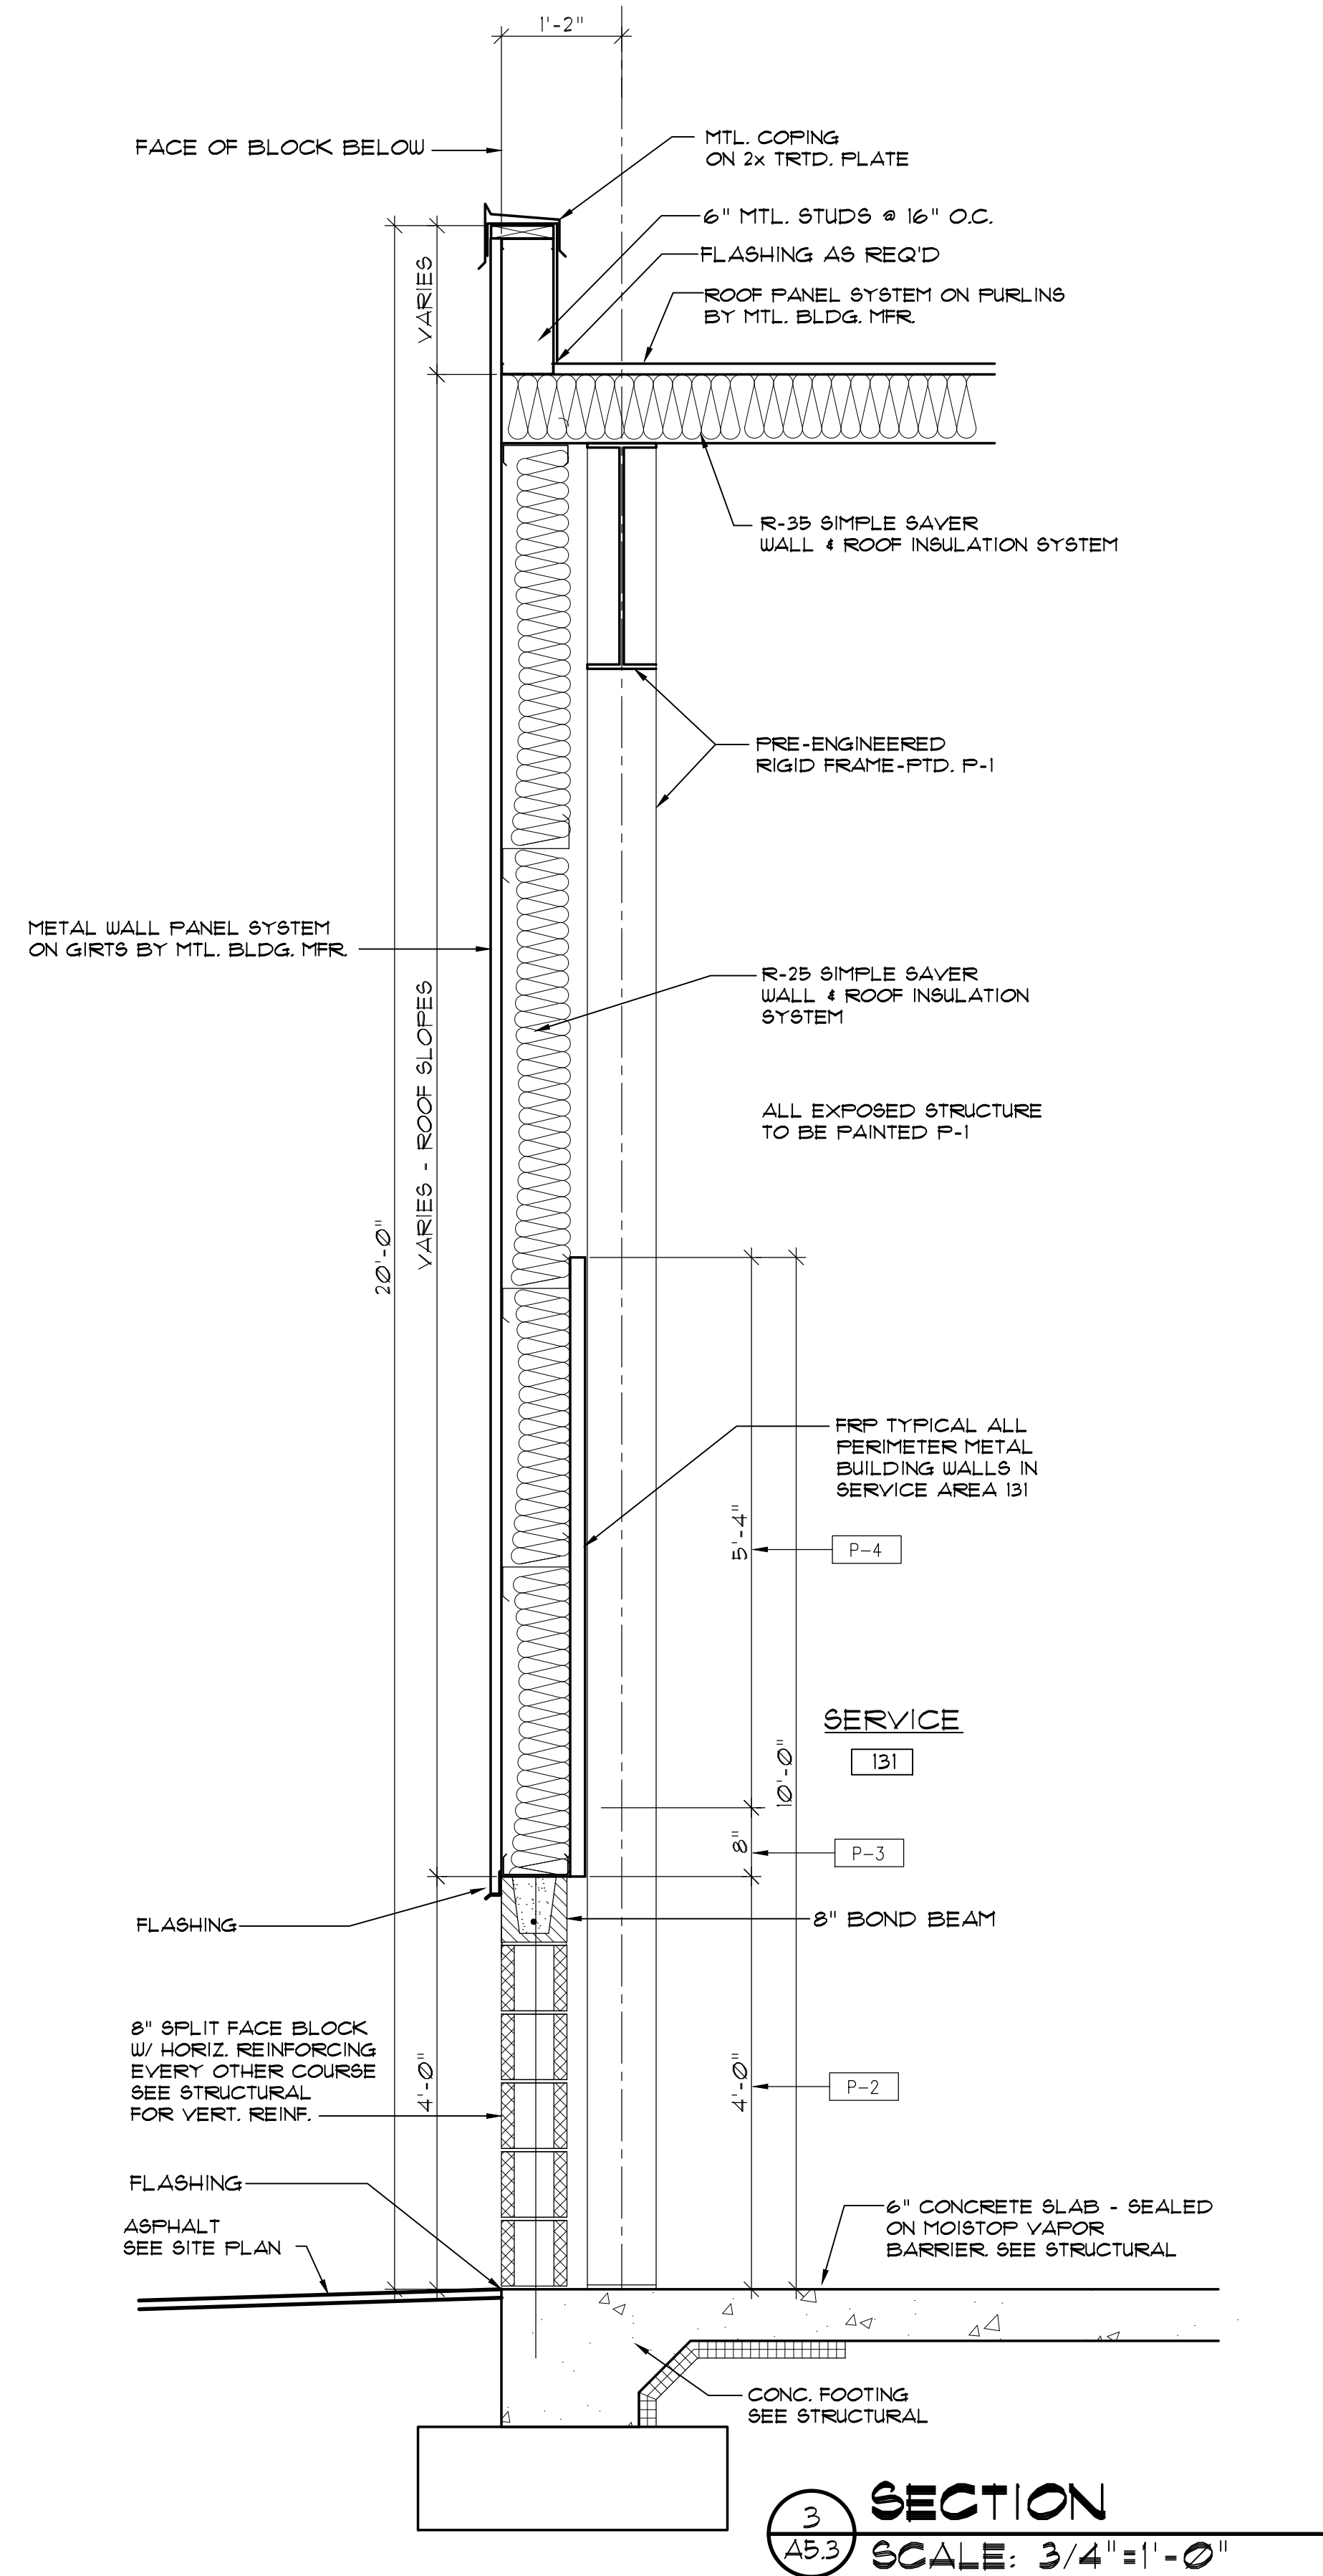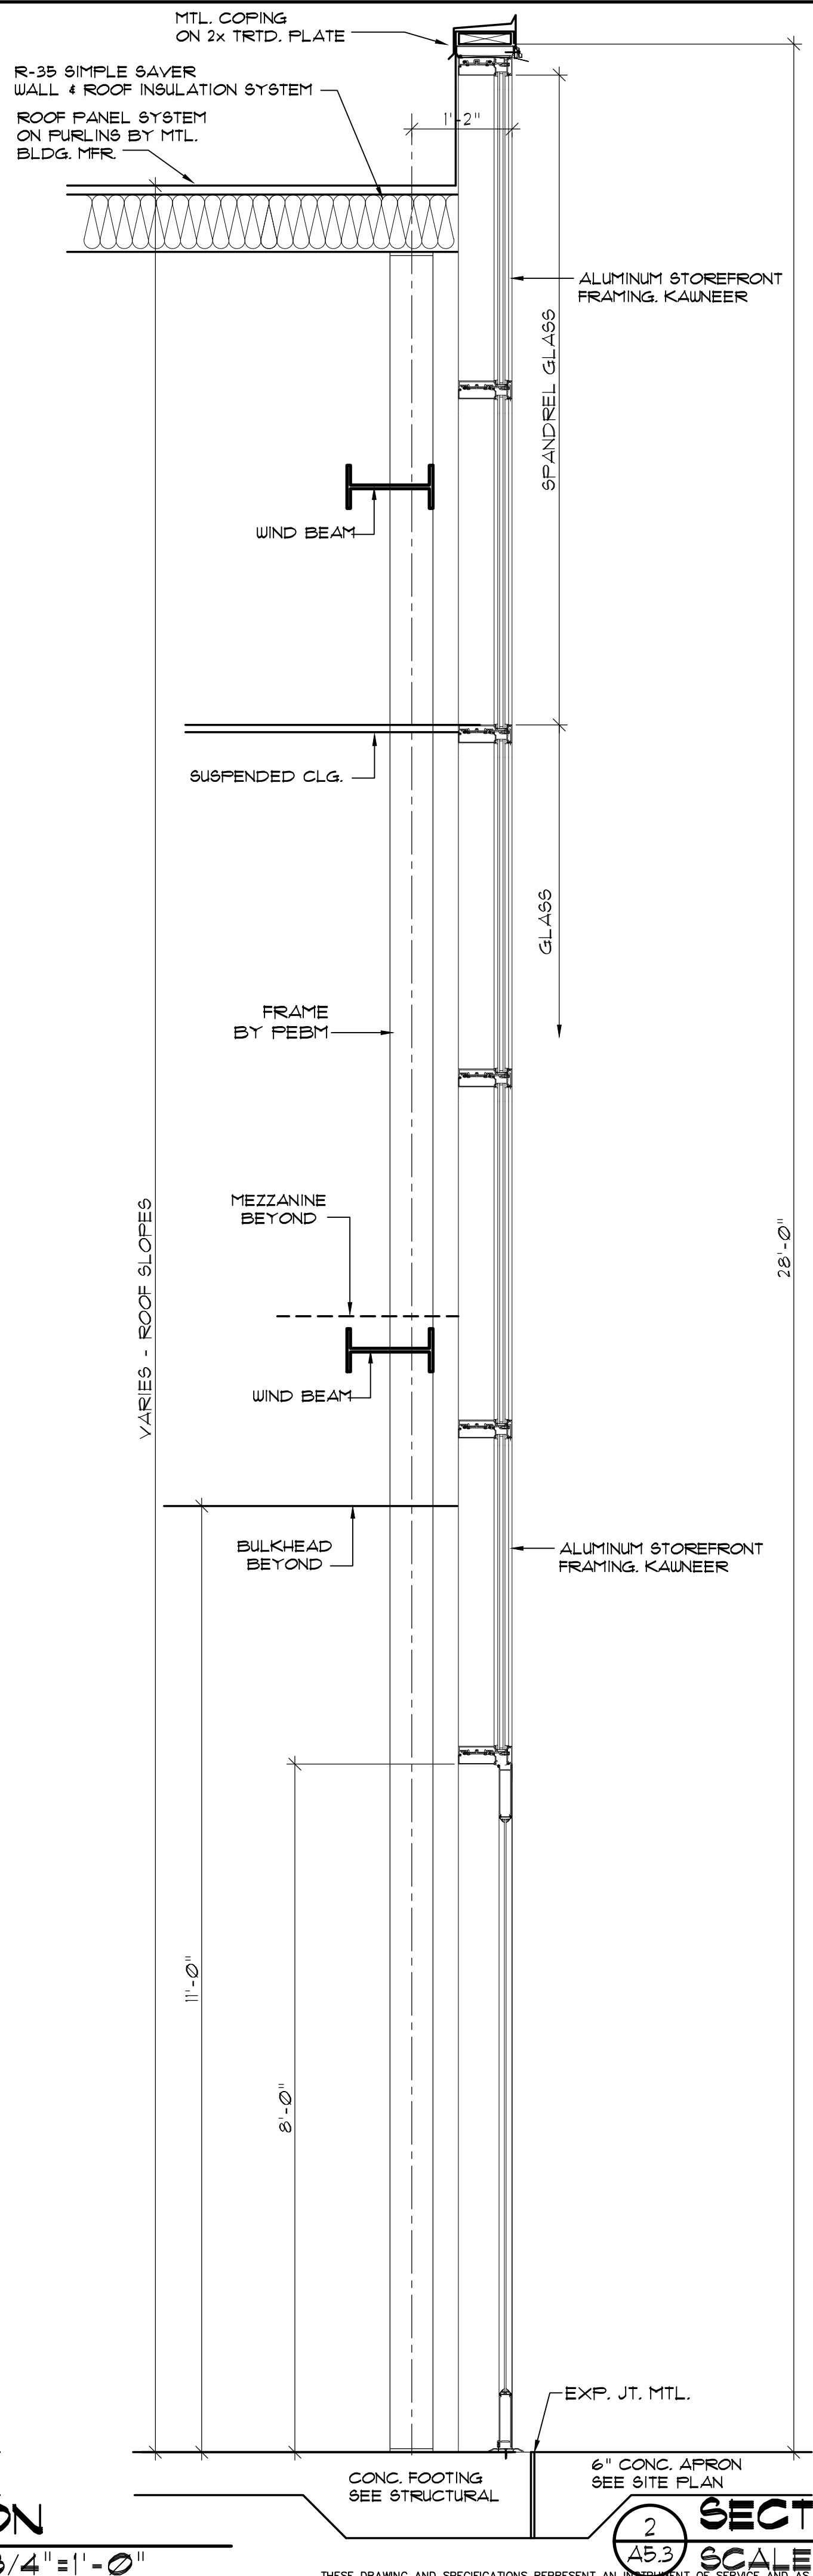

THESE DRAWING AND SPECIFICATIONS REPRESENT AN INSTRUMENT OF SERVICE AND AS SUCH SHALL REMAIN IN OWNERSHIP WITH THE ARCHITECT. USE OR REPRODUCTION BY ANY MEANS, IN WHOLE OR IN PART, WITHOUT THE ARCHITECT'S WRITTEN CONSENT, IS PROHIBITED.

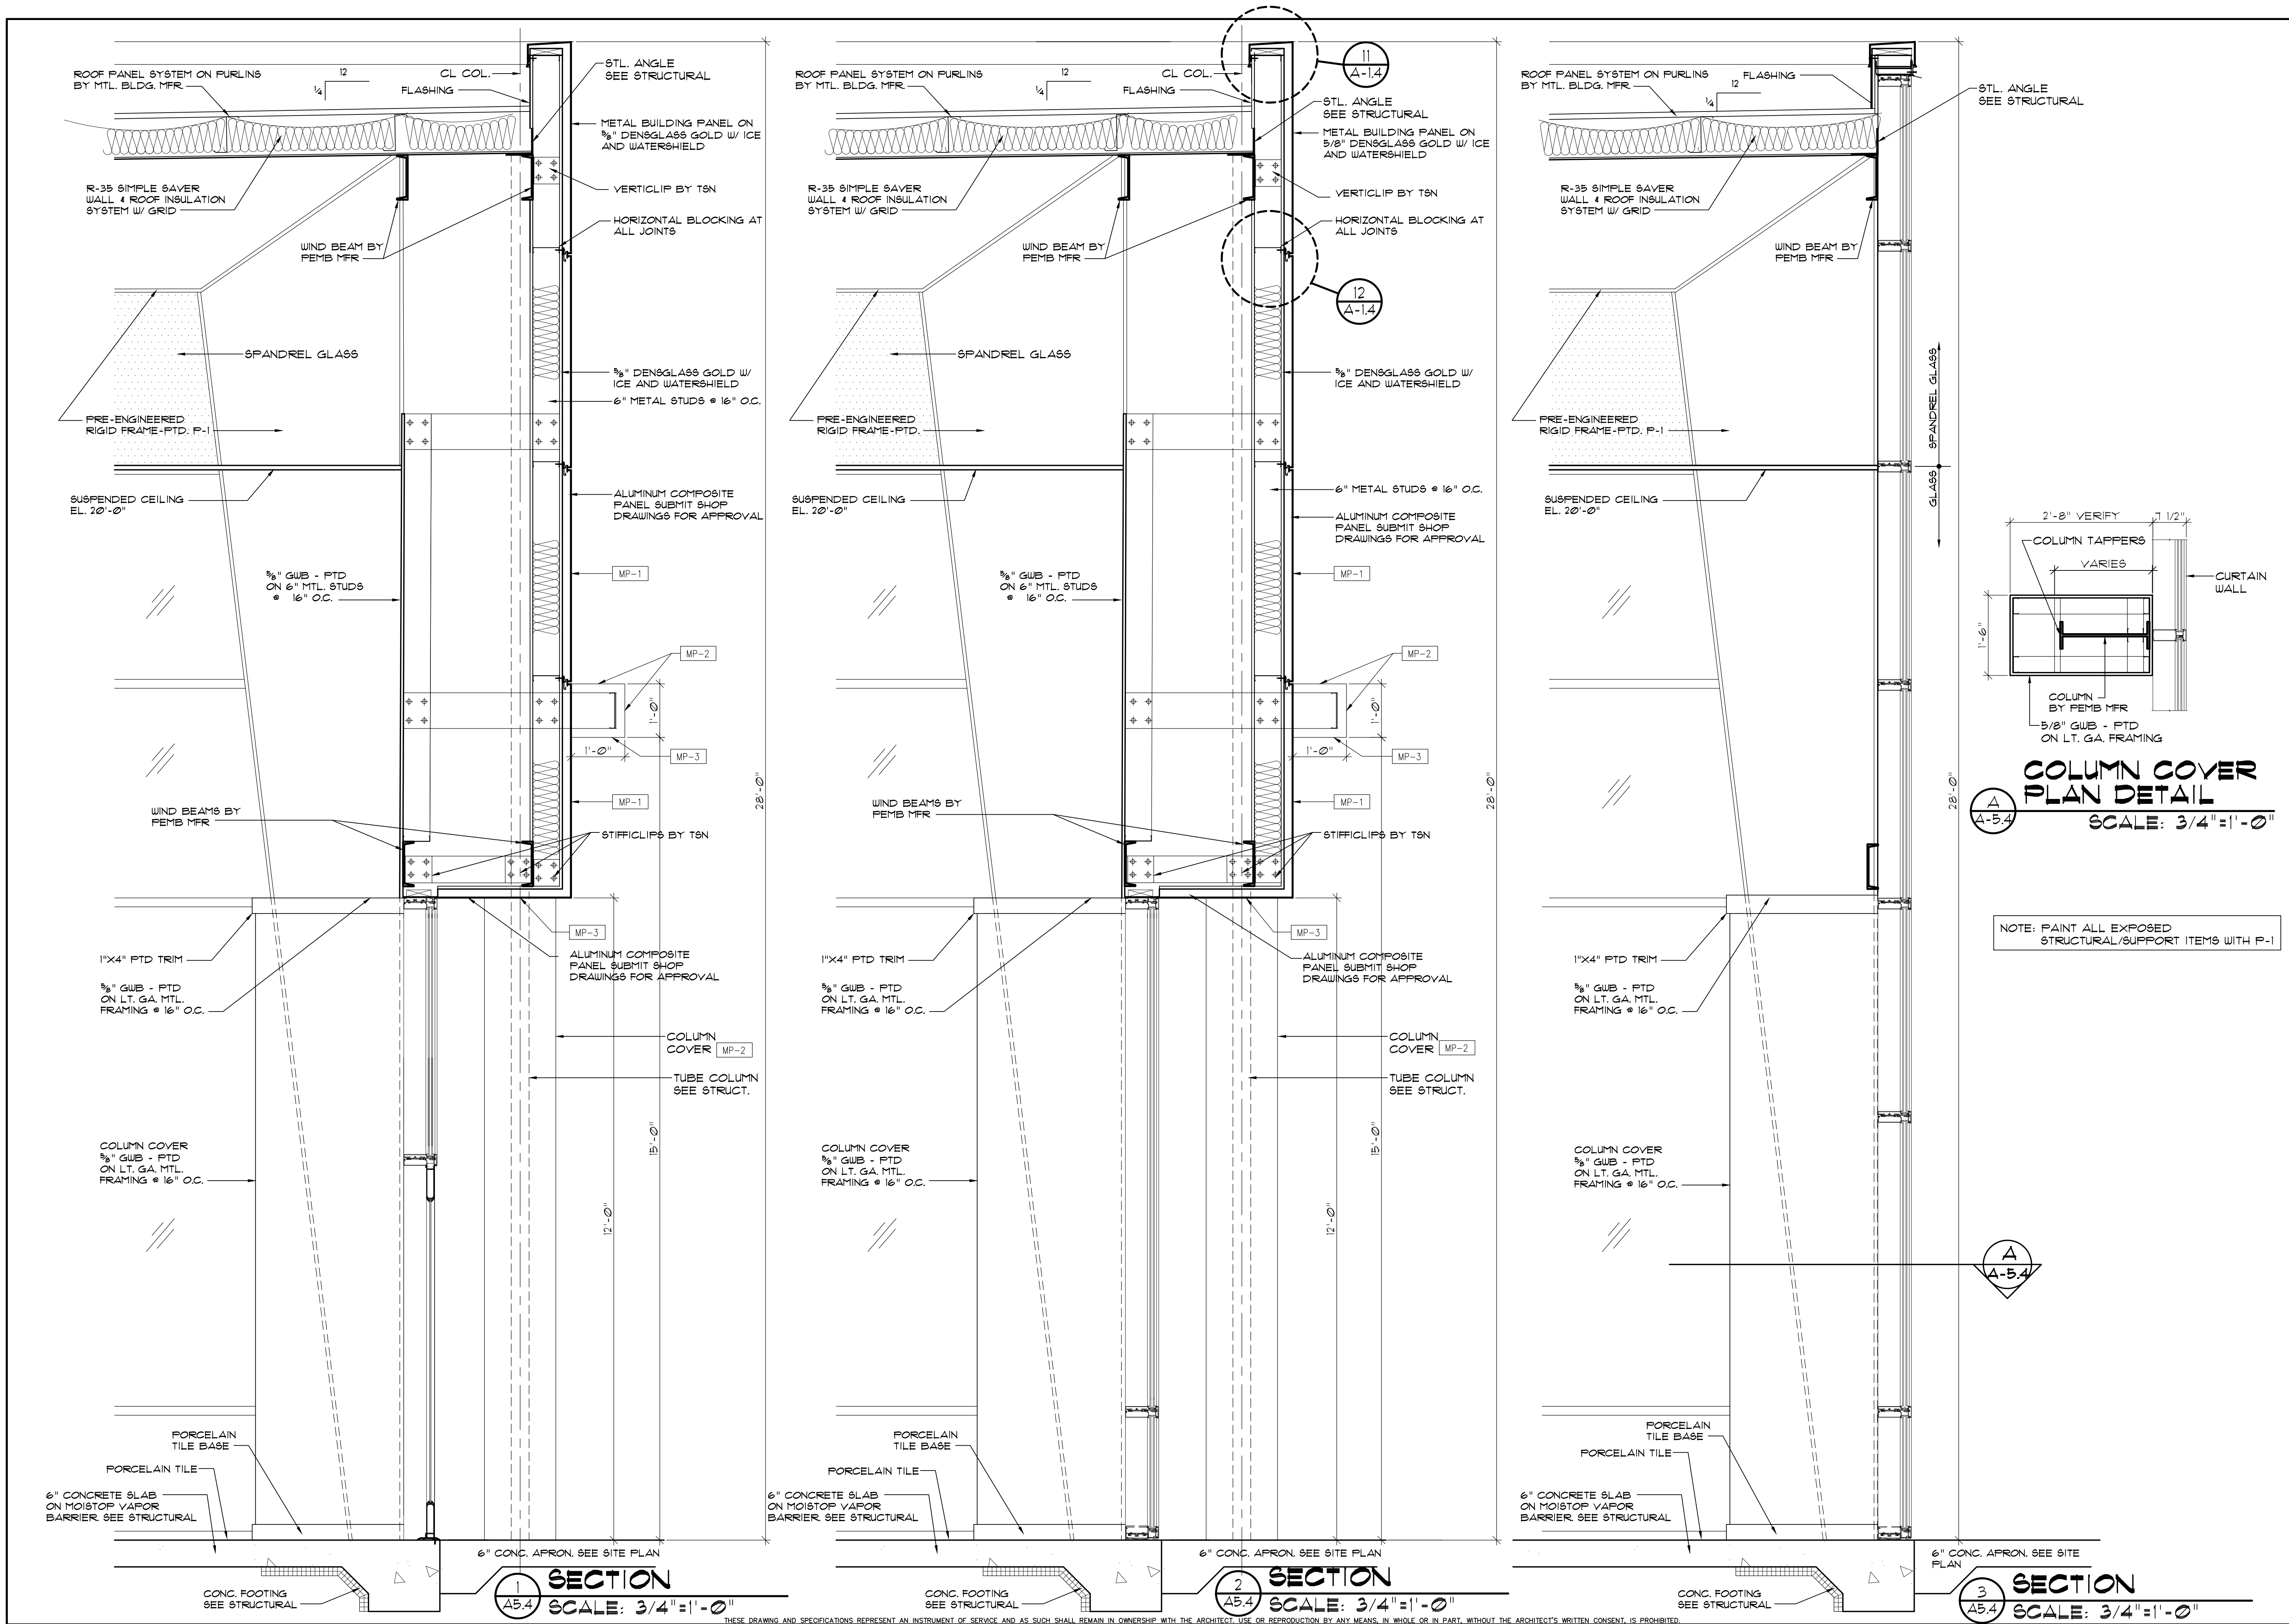

NC074 KIA OF NEW BERN
NEW BERN, NORTH CAROLINA

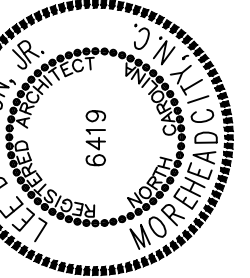

L SECTIONS

6034

ED: 20 NOV 18

BY: BLS, LSA

BY: LDD

DISCUSSION

--	--

--	--


[illegible]

SHEET NO.

-55

A-5.5


OF

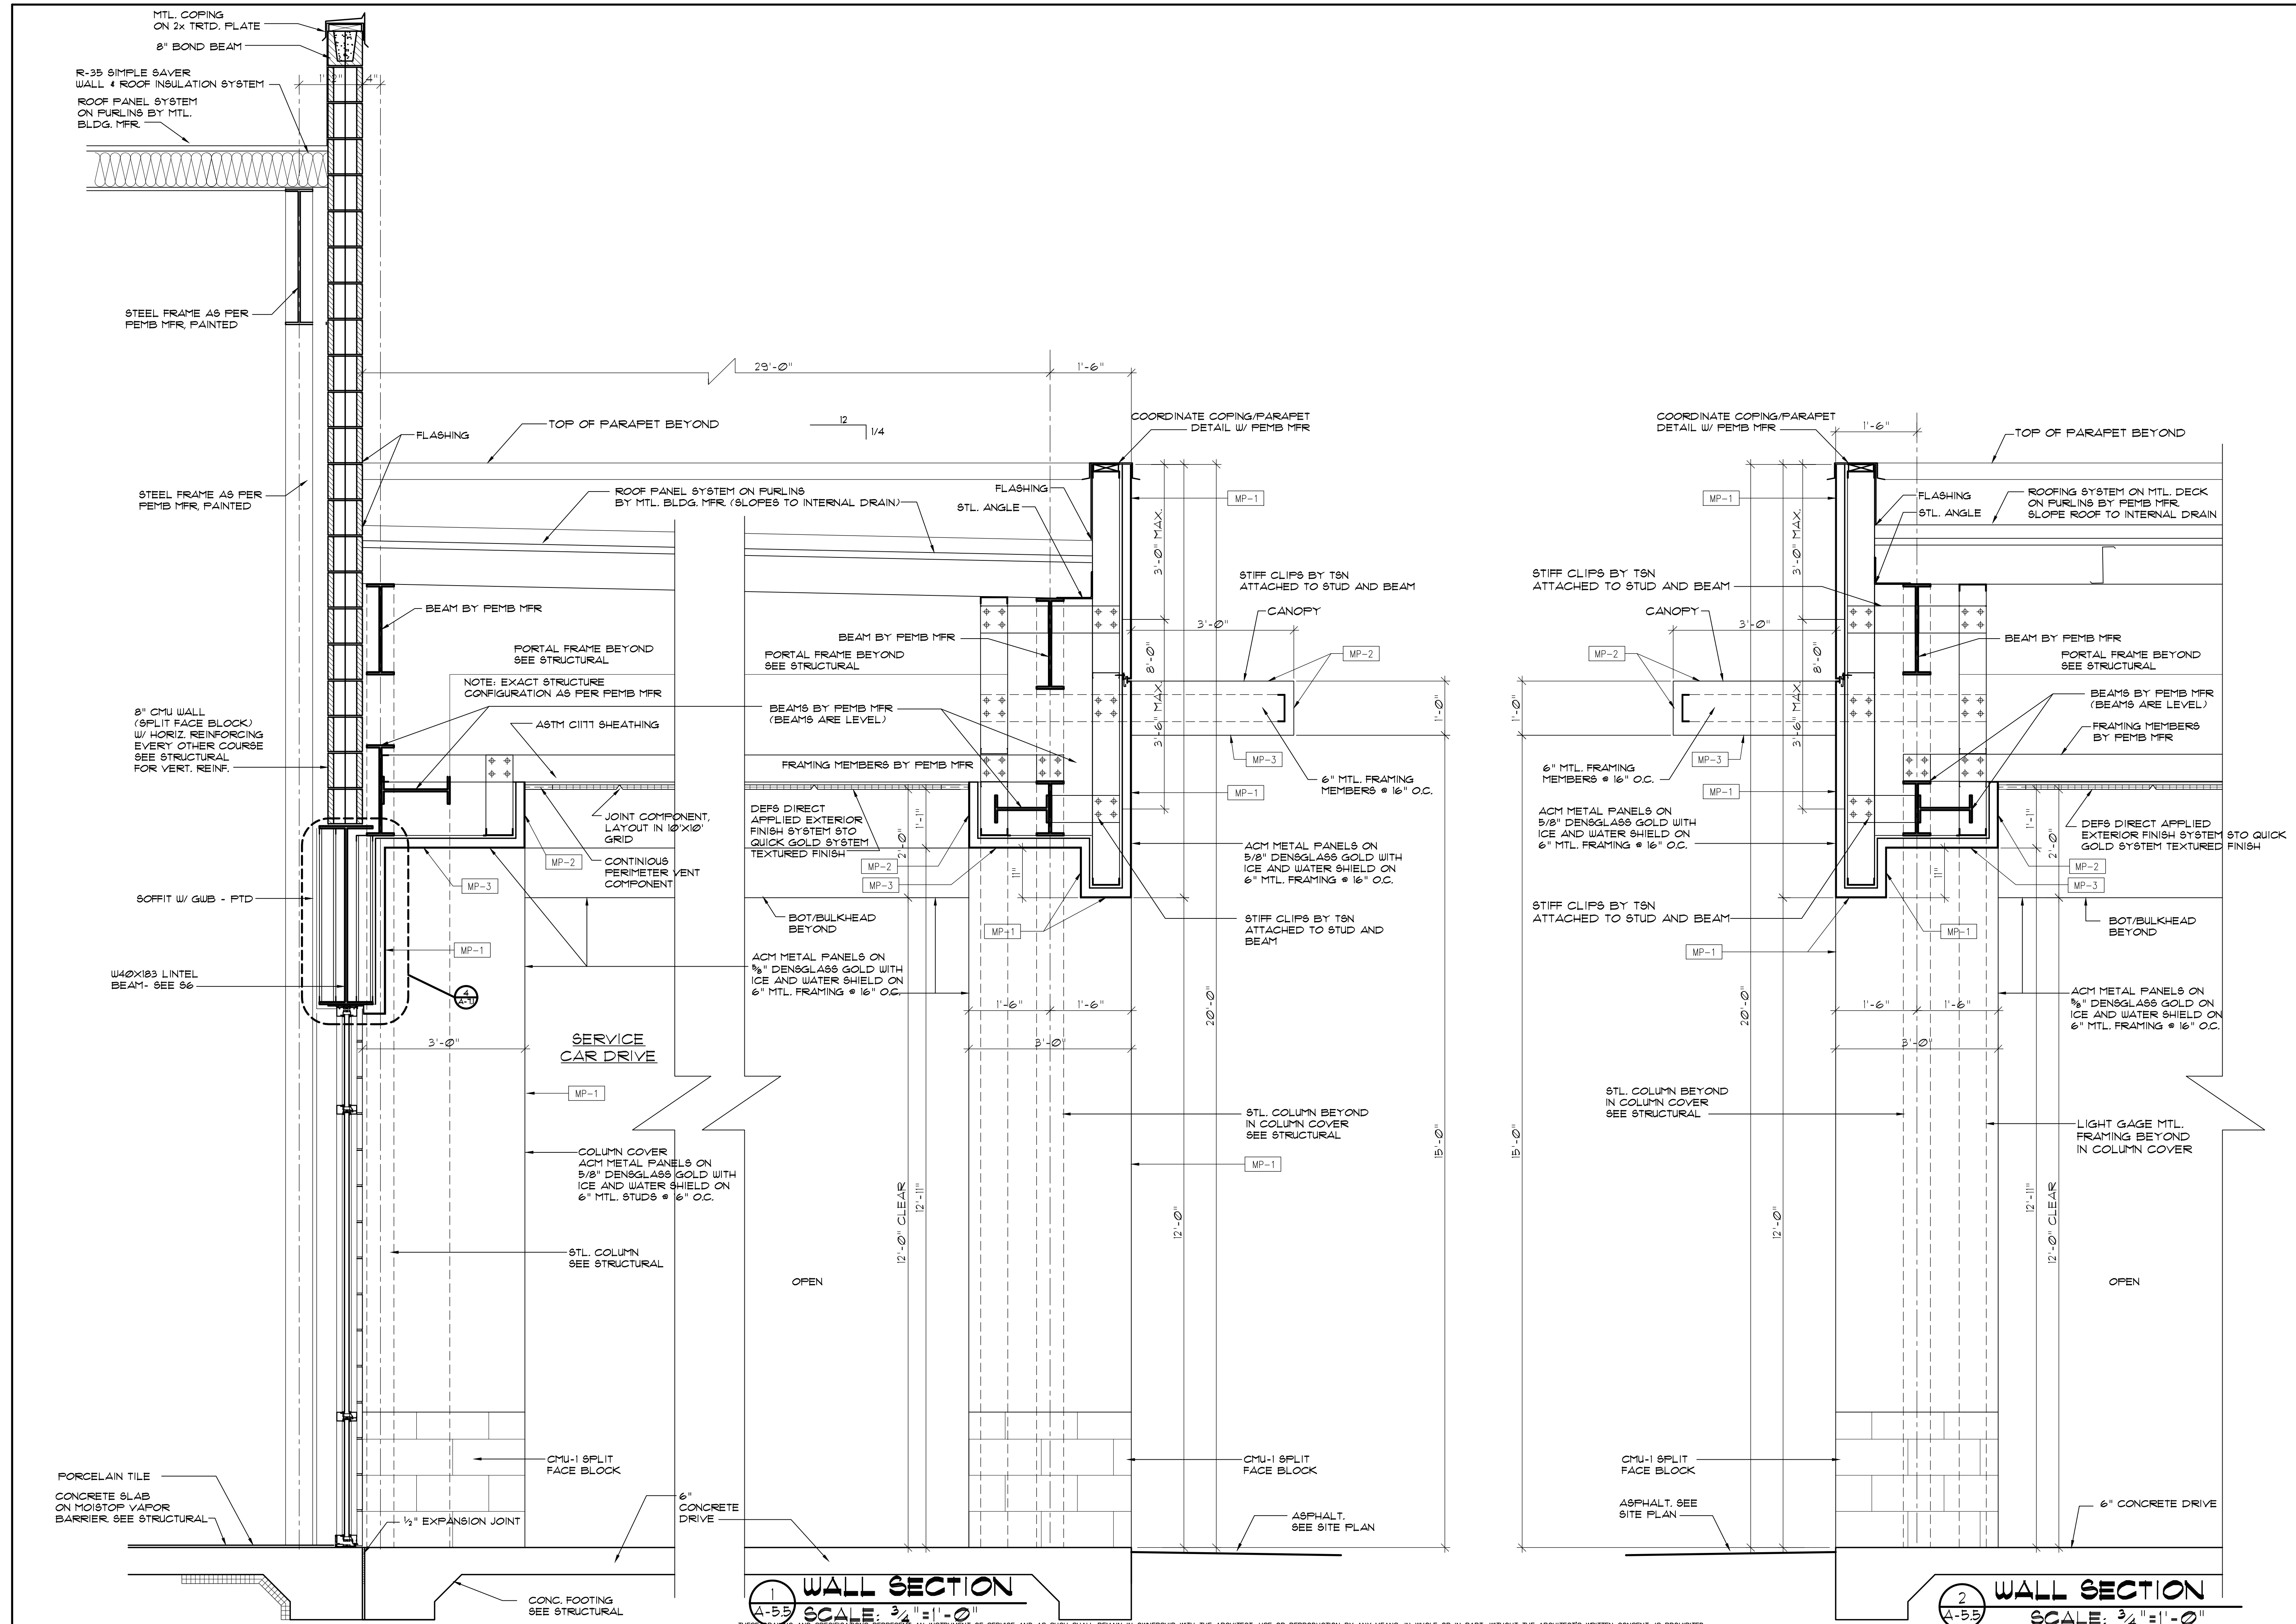


LEGEND

X-?

FINISH DESIGNATOR - REFER TO EXTERIOR FINISH SCHEDULE
ON SHEET A-3.13

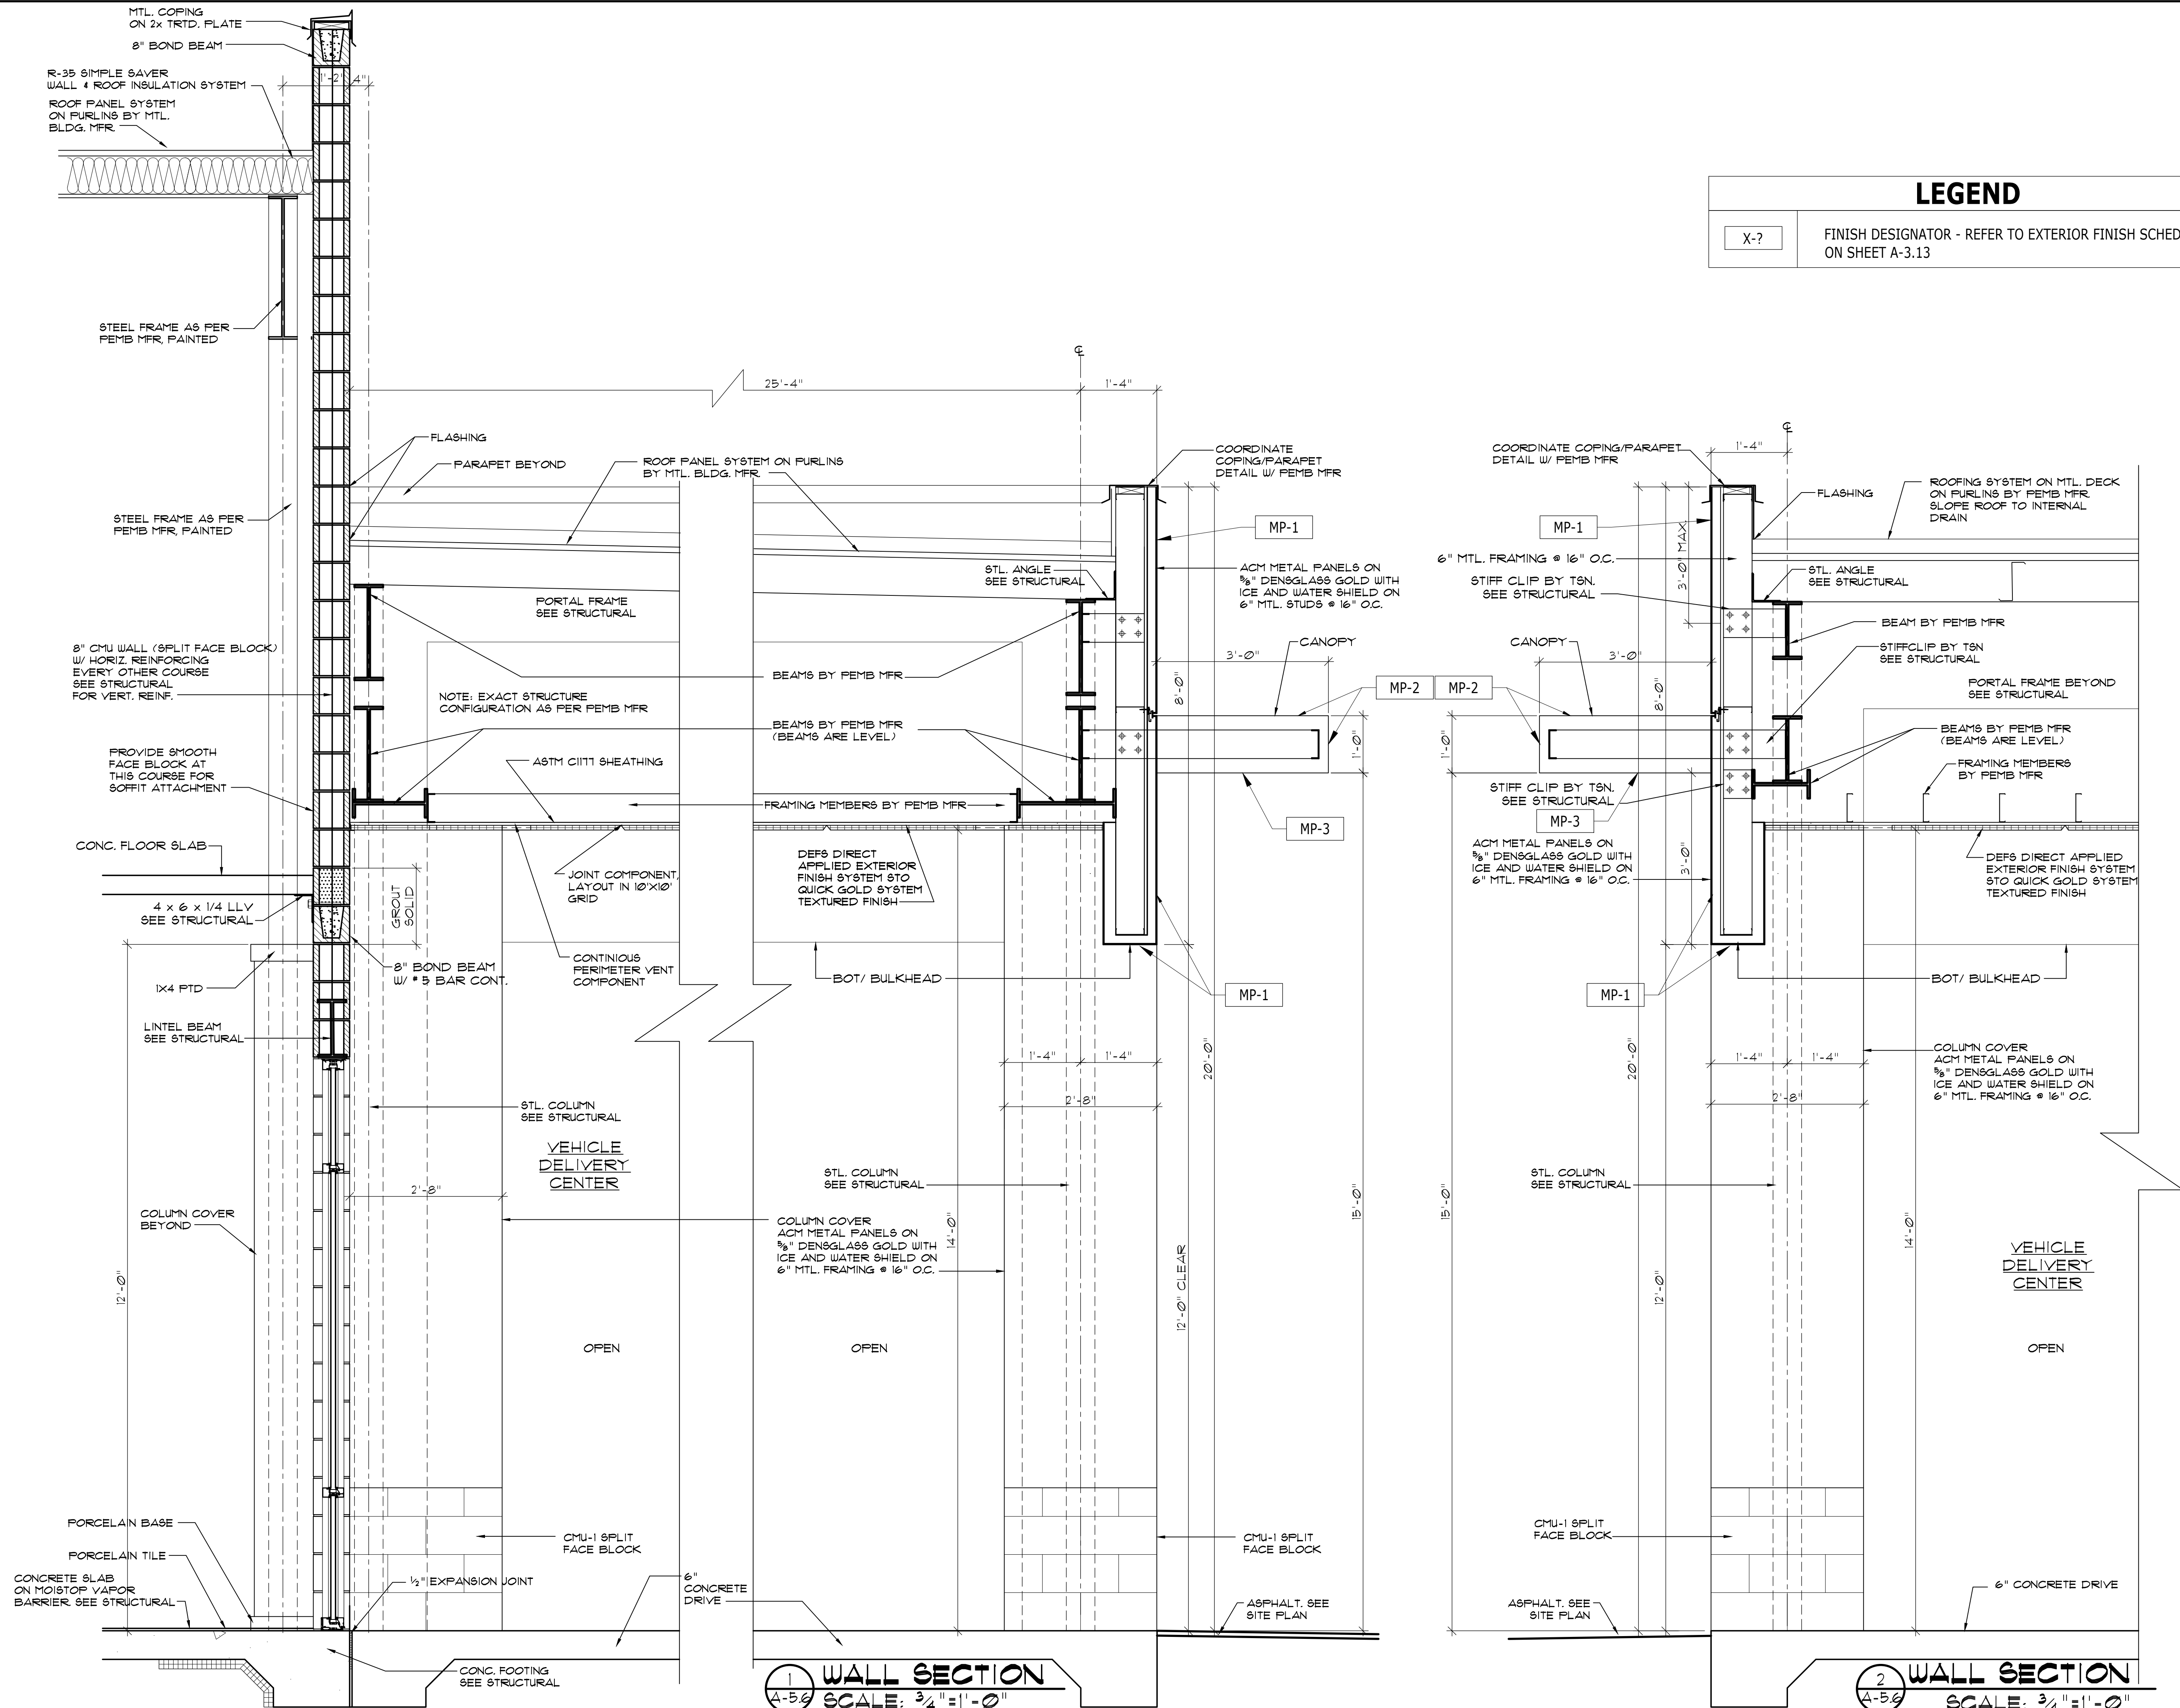

NC074 KIA OF NEW BERN
NEW BERN, NORTH CAROLINA

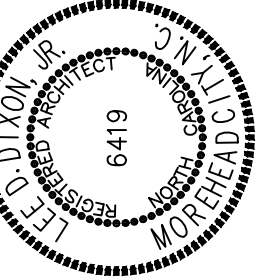


ALL SECTIONS

16034

SUED:	20 NOV 18
WG BY:	BLS, LSA
D BY:	LDD
VISIONS	

SHEET NO.
A-5.7
OF

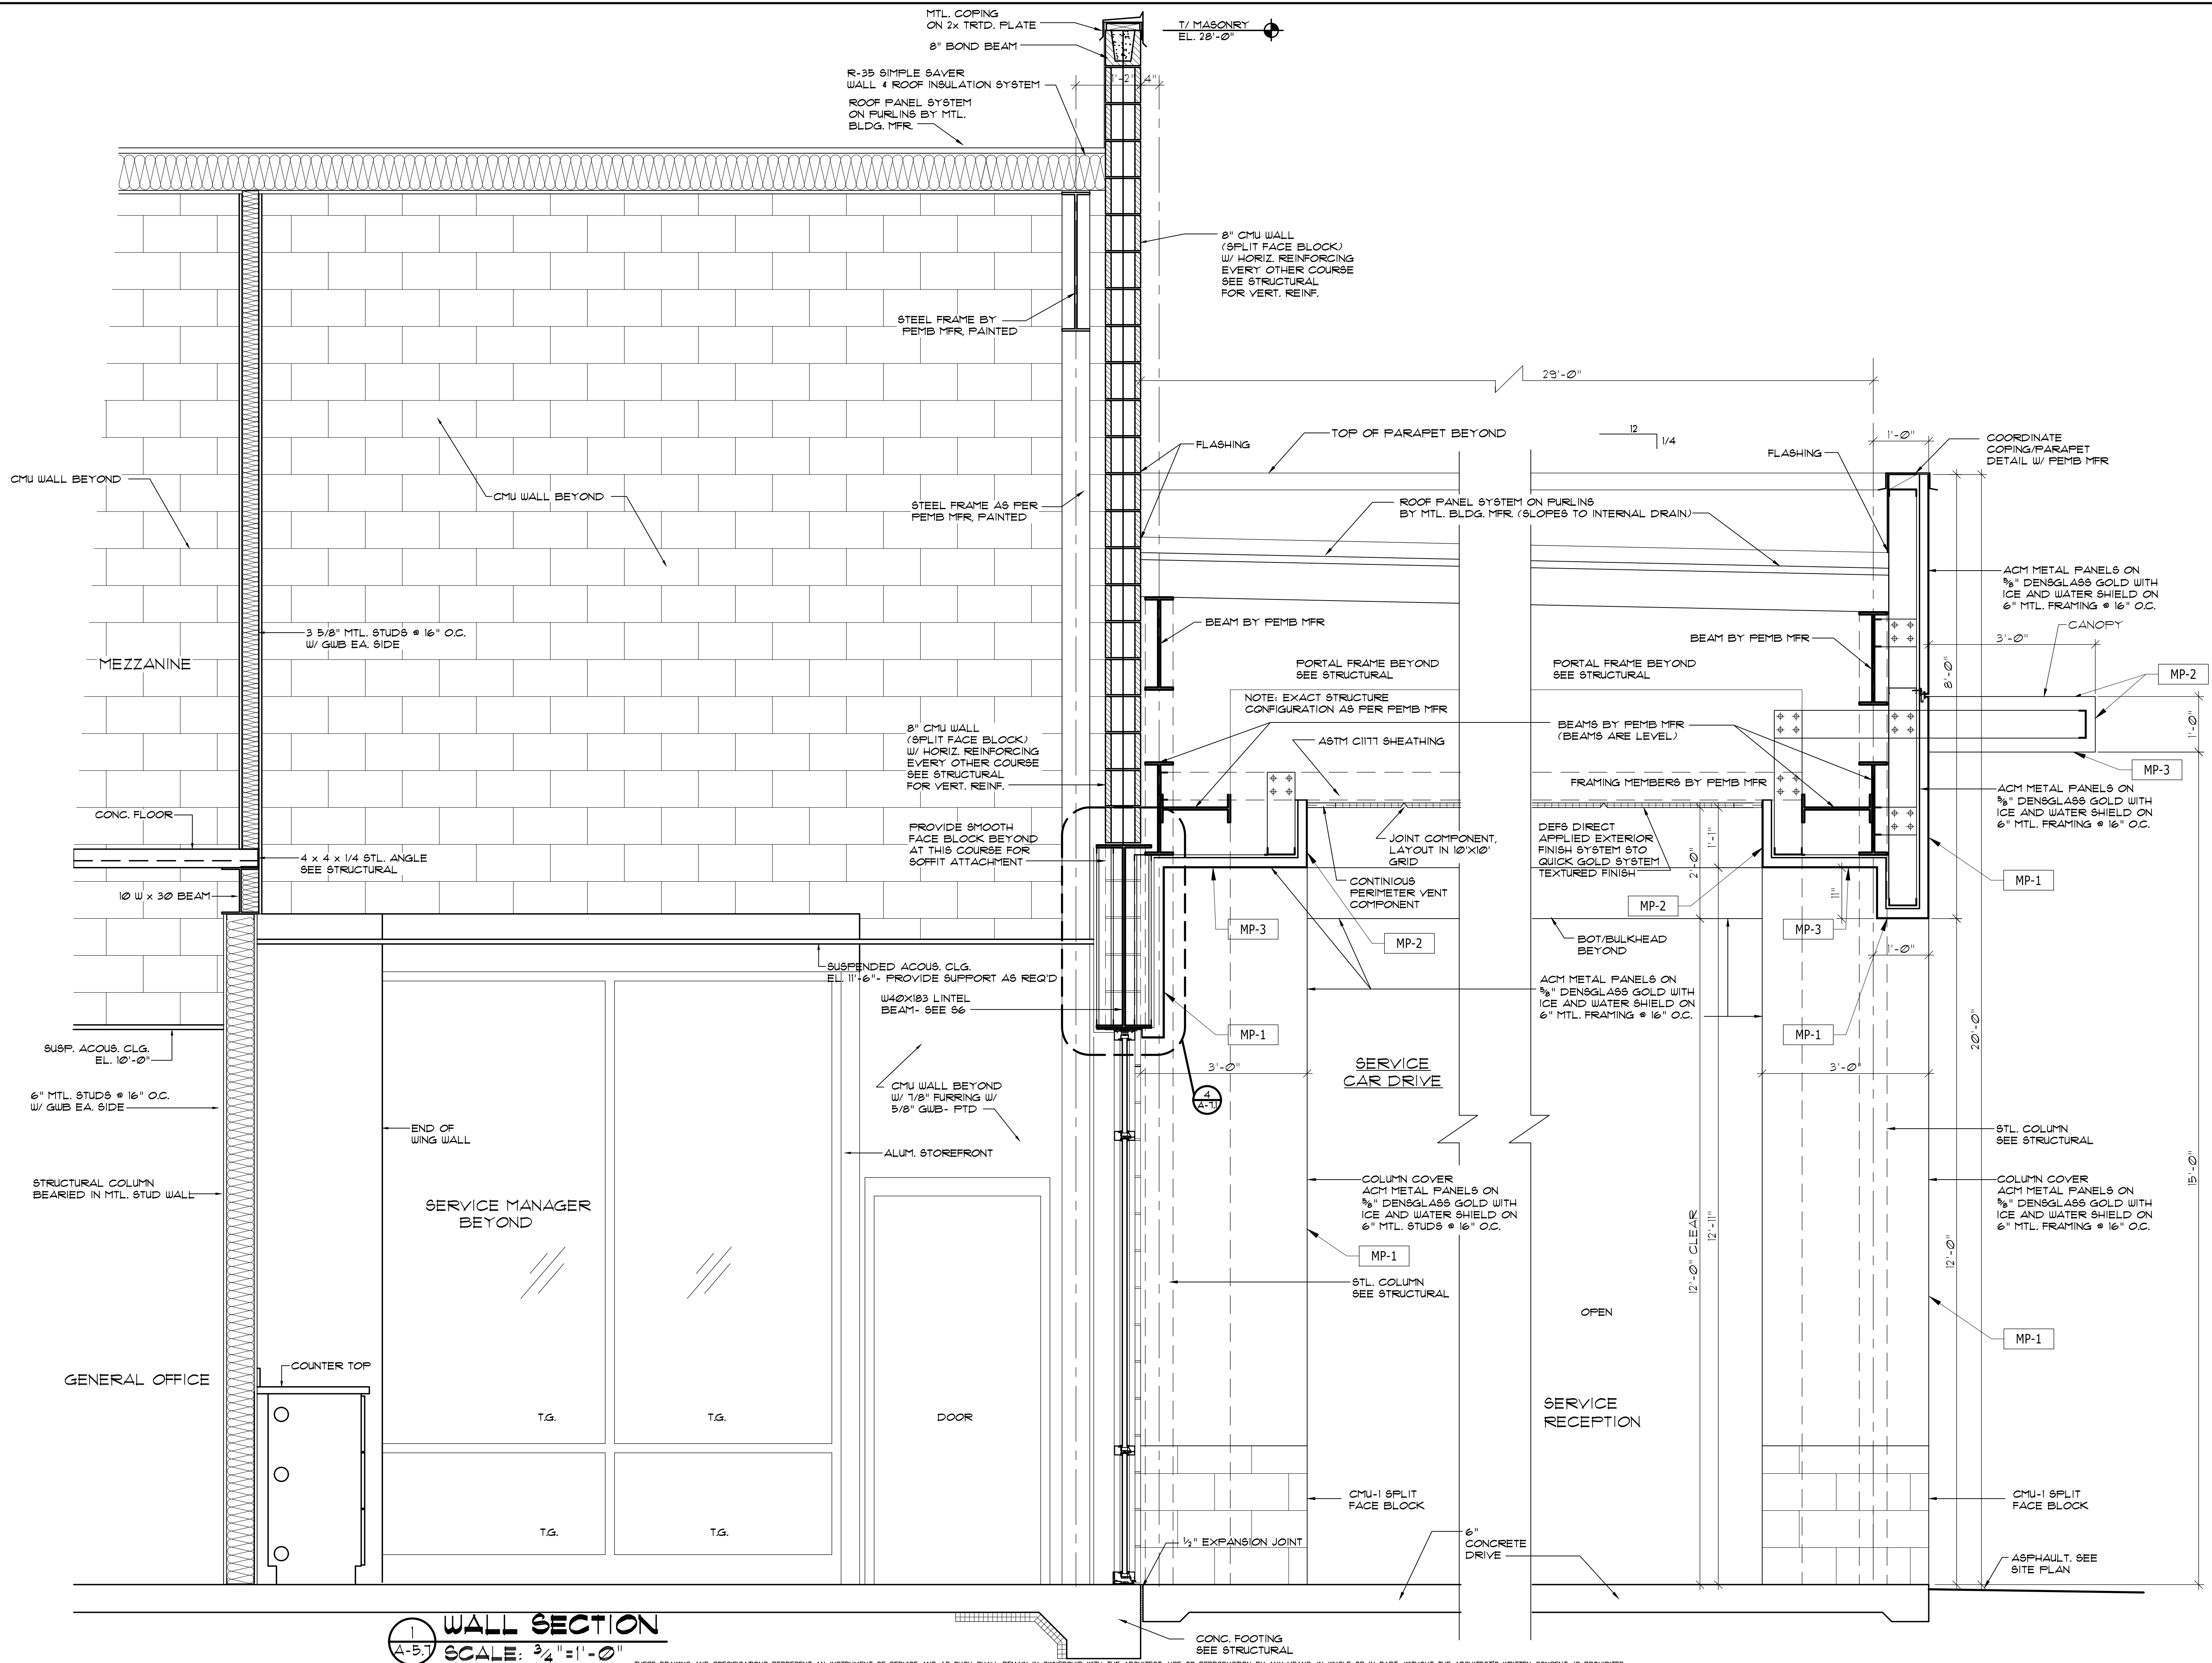

1 WALL SECTION
A-5.7 SCALE: 3/4" = 1'-0"





THESE DRAWING AND SPECIFICATIONS REPRESENT AN INSTRUMENT OF SERVICE AND AS SUCH SHALL REMAIN IN OWNERSHIP WITH THE ARCHITECT. USE OR REPRODUCTION BY ANY MEANS, IN WHOLE OR IN PART, WITHOUT THE ARCHITECT'S WRITTEN CONSENT, IS PROHIBITED.

LEGEND

X-?

FINISH DESIGNATOR - REFER TO EXTERIOR FINISH SCHEDULE
ON SHEET A-3.13

FIXTURES AND INTERIOR GRAPHICS
PROVIDED EXCLUSIVELY BY EWI WORLDWIDE.
CONTACT EILEEN DYER (414-277-6327) TO DETERMINE EWI
SCOPE AND REQUIREMENTS.

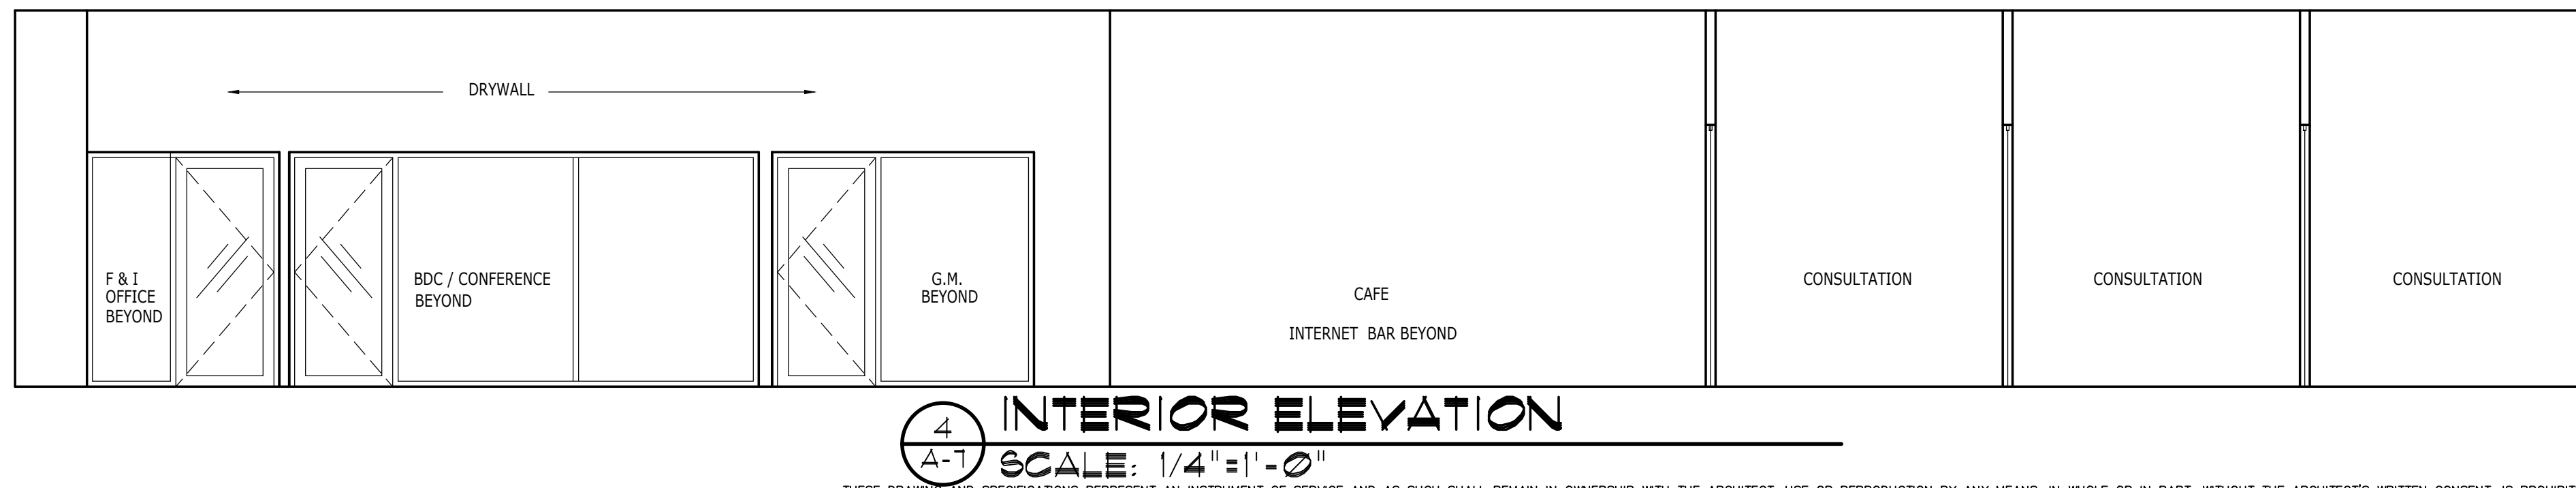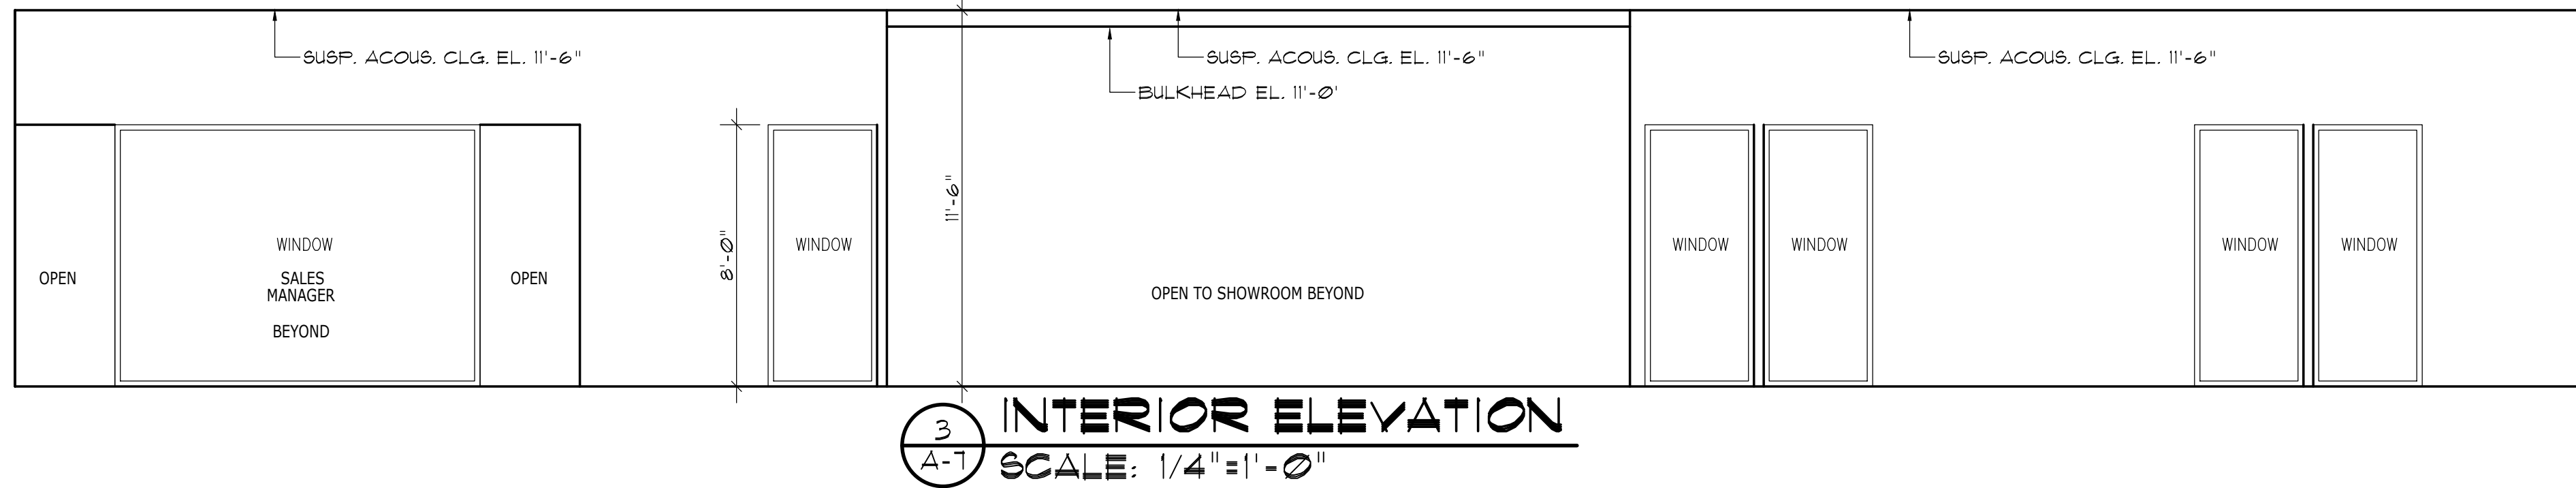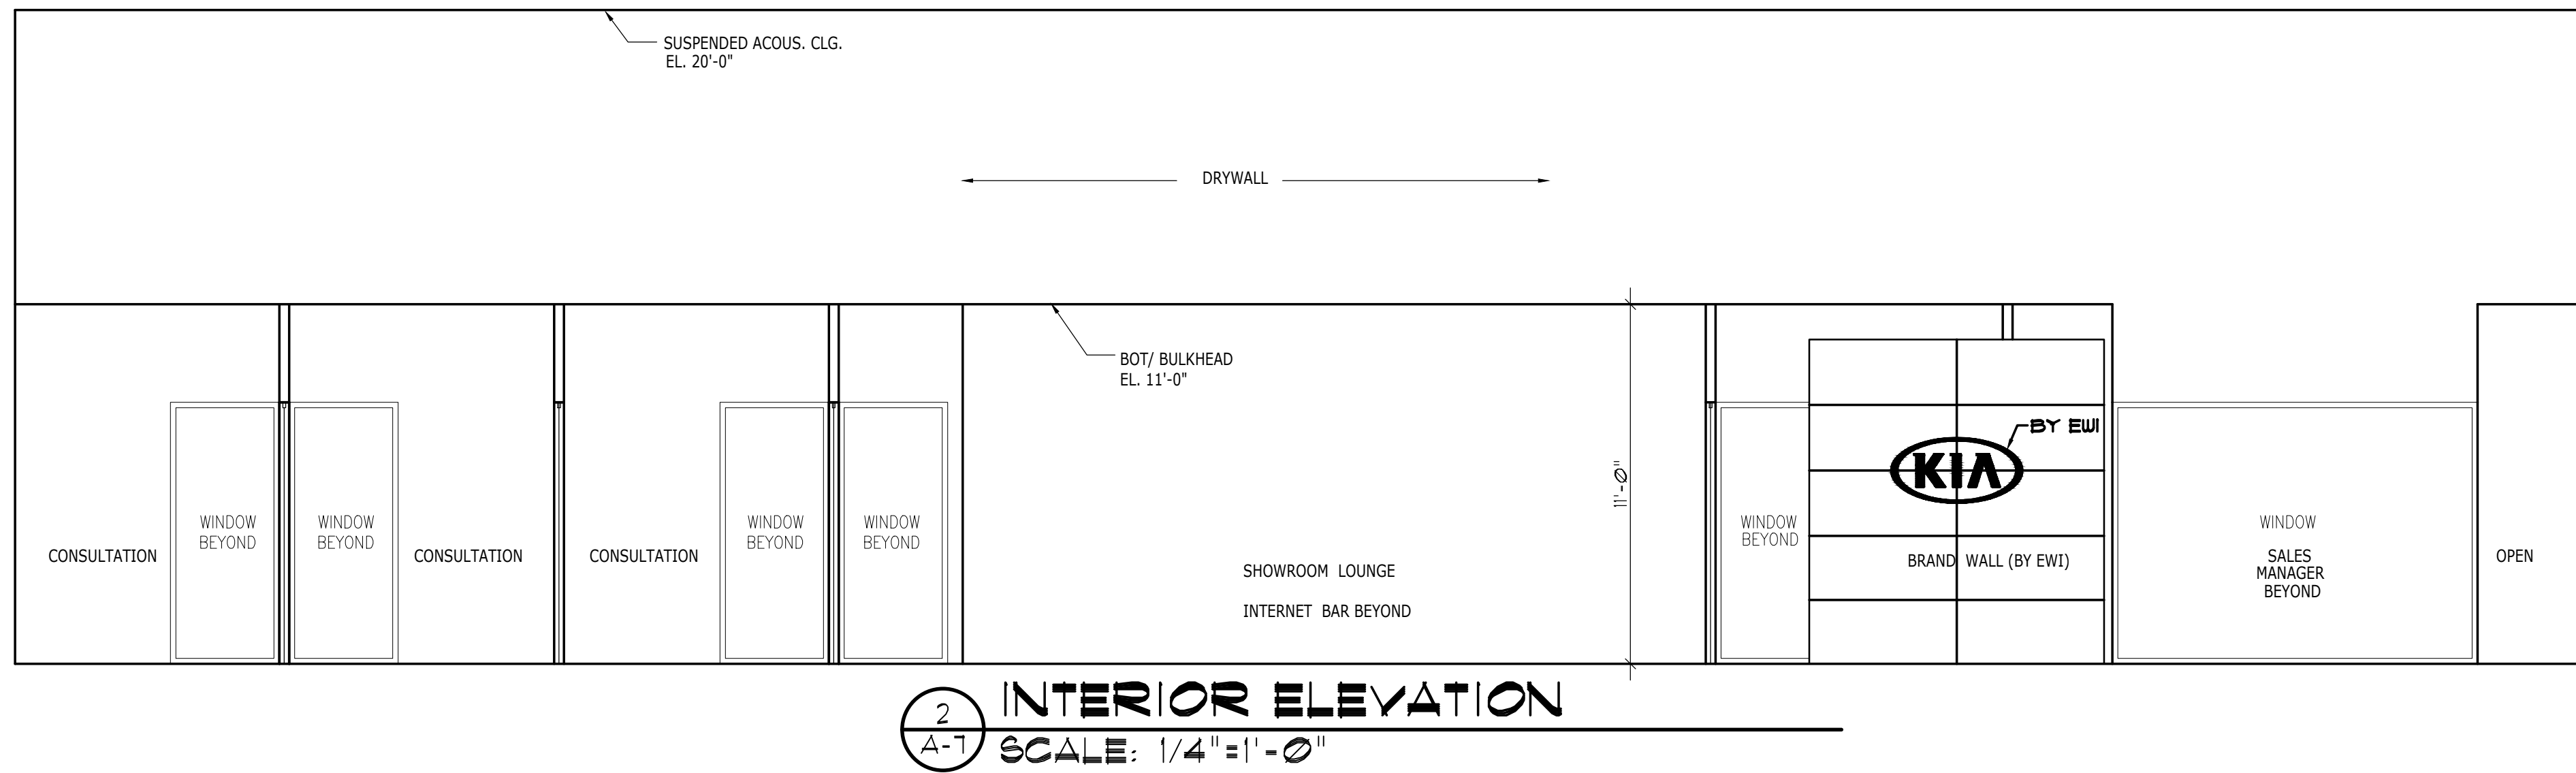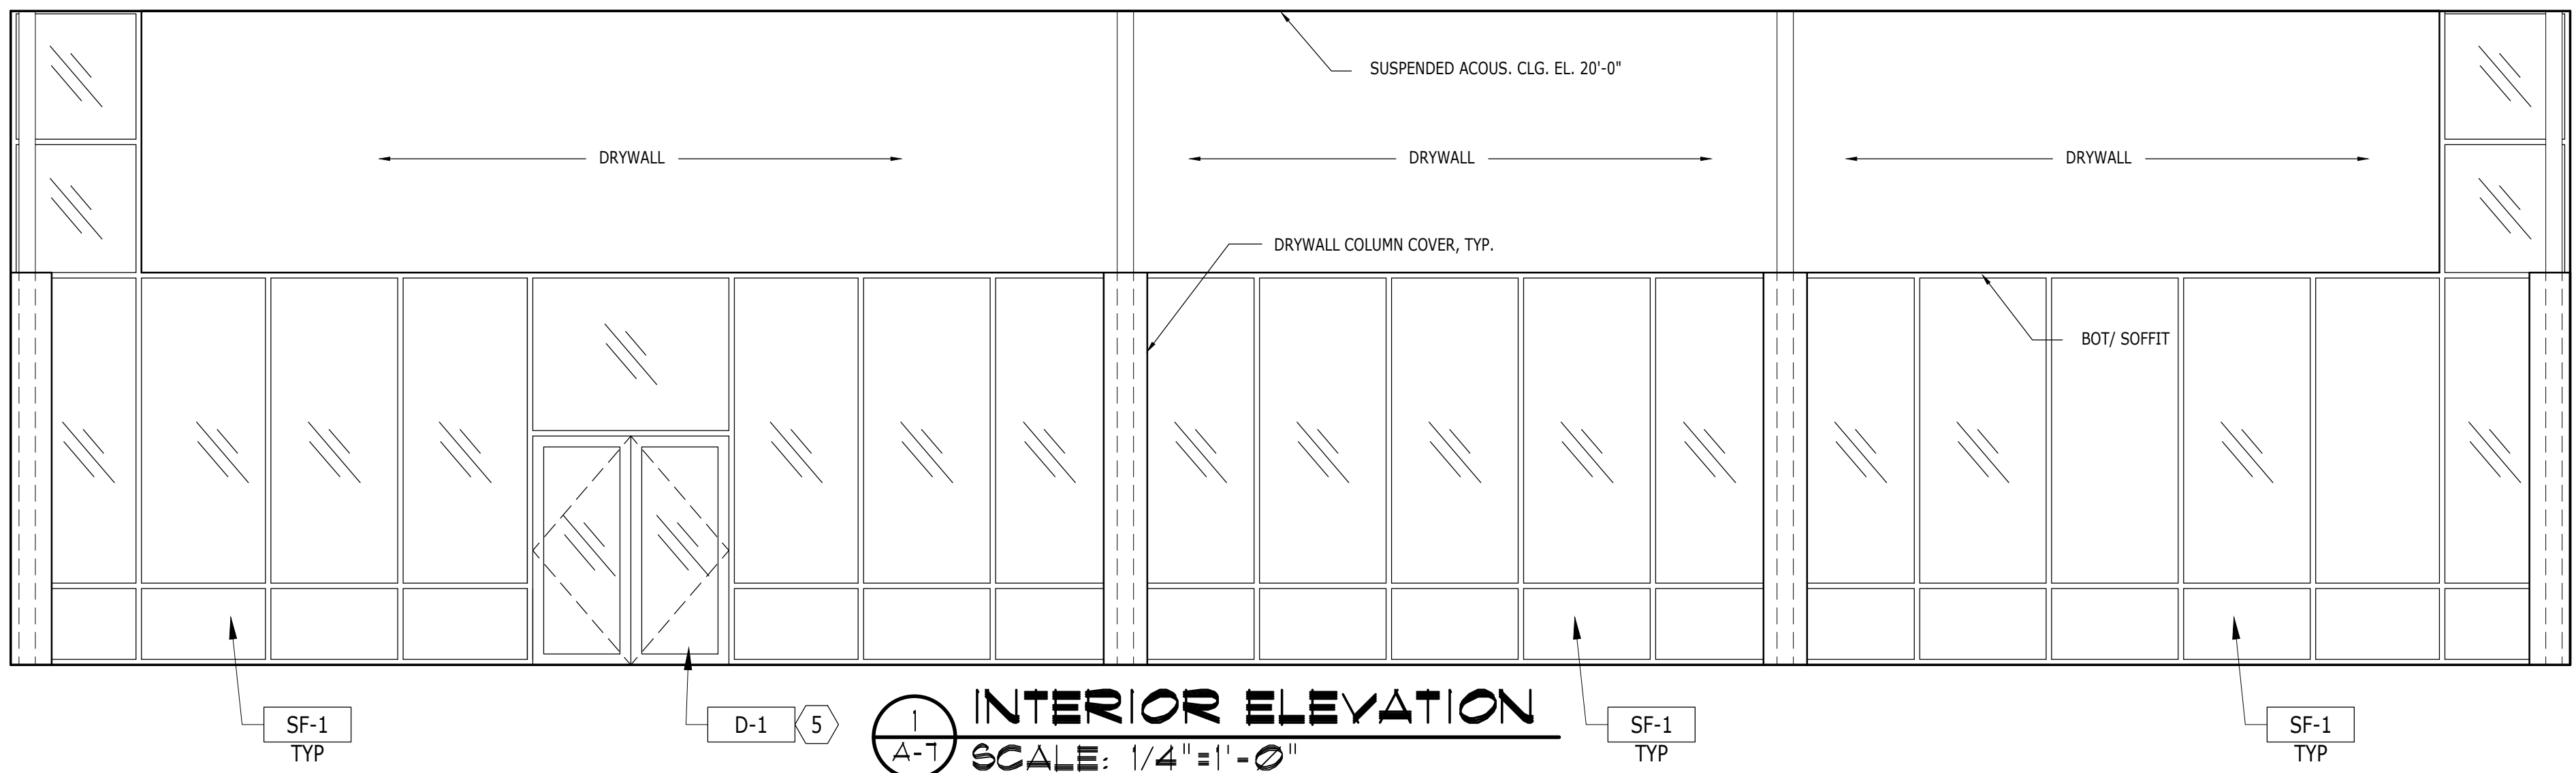

LEGEND	
X-?	FINISH DESIGNATOR - REFER TO EXTERIOR FINISH SCHEDULE ON SHEET A-3.13

FIXTURES AND INTERIOR GRAPHICS
PROVIDED EXCLUSIVELY BY EWI WORLDWIDE.
CONTACT EILEEN DYER (414-277-6327) TO DETERMINE EWI
SCOPE AND REQUIREMENTS.



- Architectural Design
- Planning
- Interiors





Member of the American
Institute of Architects

Lee D. Dixon, Jr., AIA
252-247-2121
lee@coastalarchitecture.net

4206 Bridges St. Ext.,
Suite C
Morehead City, NC
28557

www.CoastalArchitecture.net

NC074 KIA OF NEW BERN
NEW BERN, NORTH CAROLINA

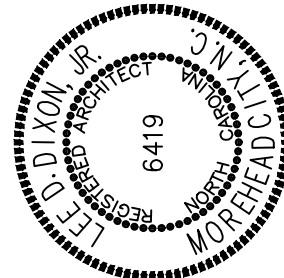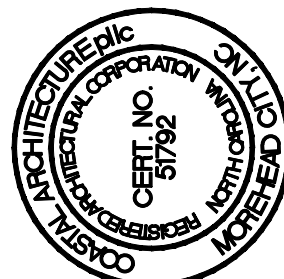

INTERIOR ELEVATIONS
DETAILS

16034

ISSUED: 20 NOV 18


DWG BY: BLS, LSA

CKD BY: LDD


REVISIONS

SHEET NO.


A-7.1
OF

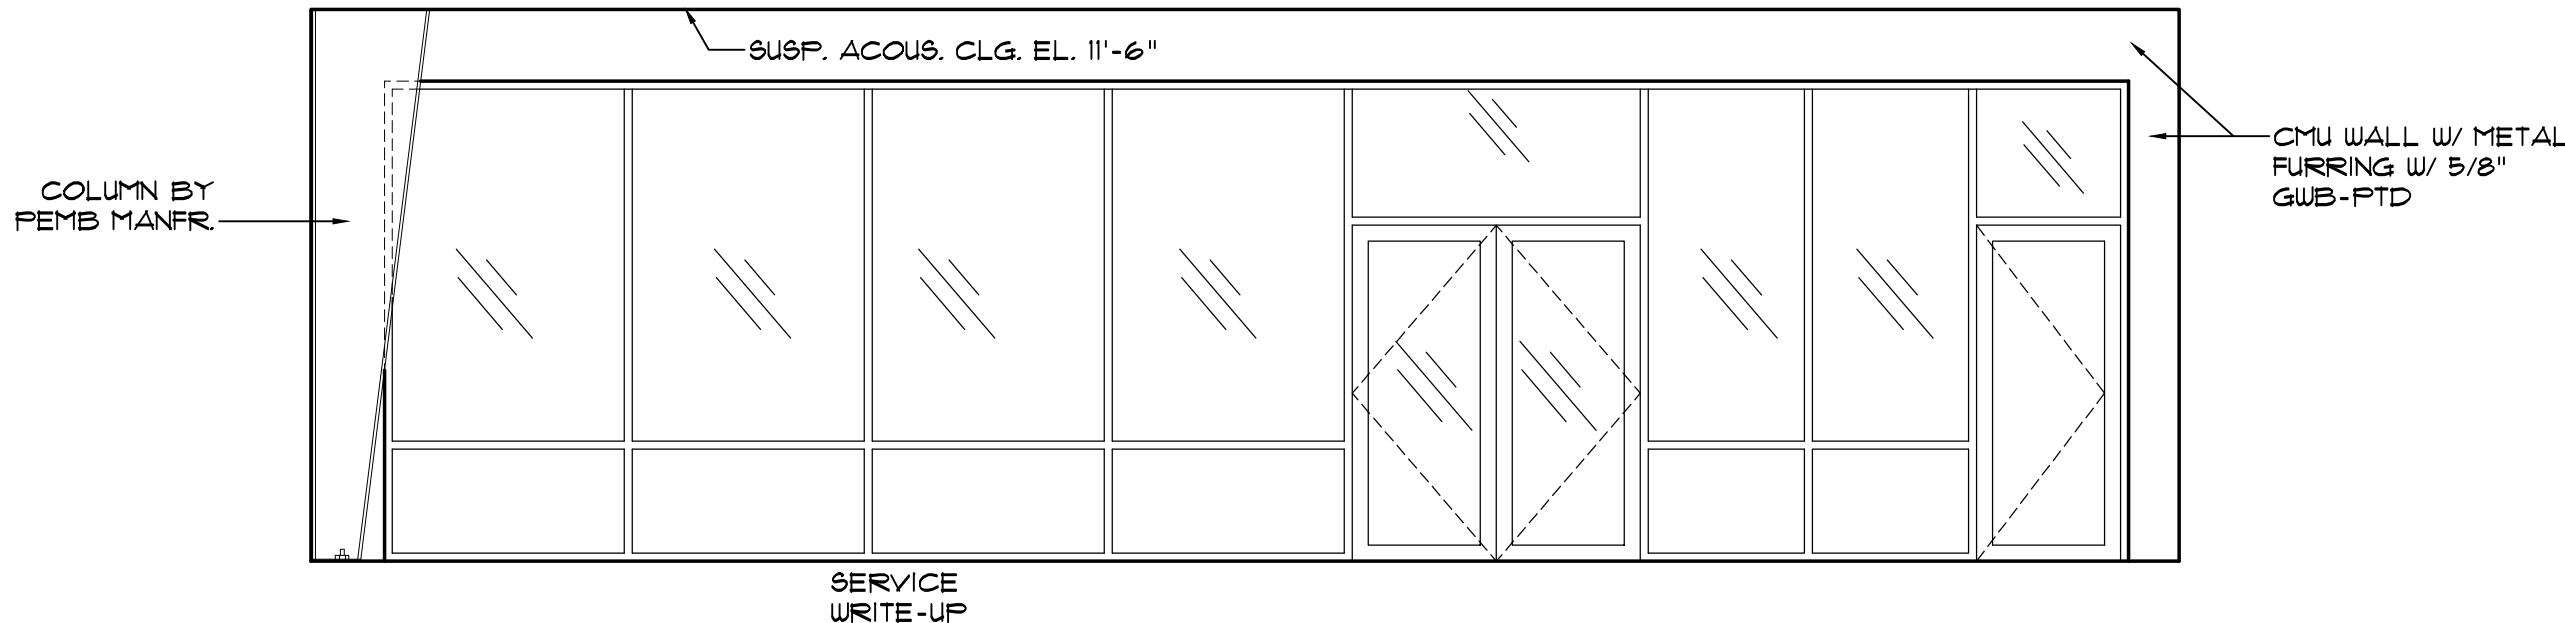


3
A-7.1
INTERIOR ELEVATION
SCALE: 1/4"=1'-0"

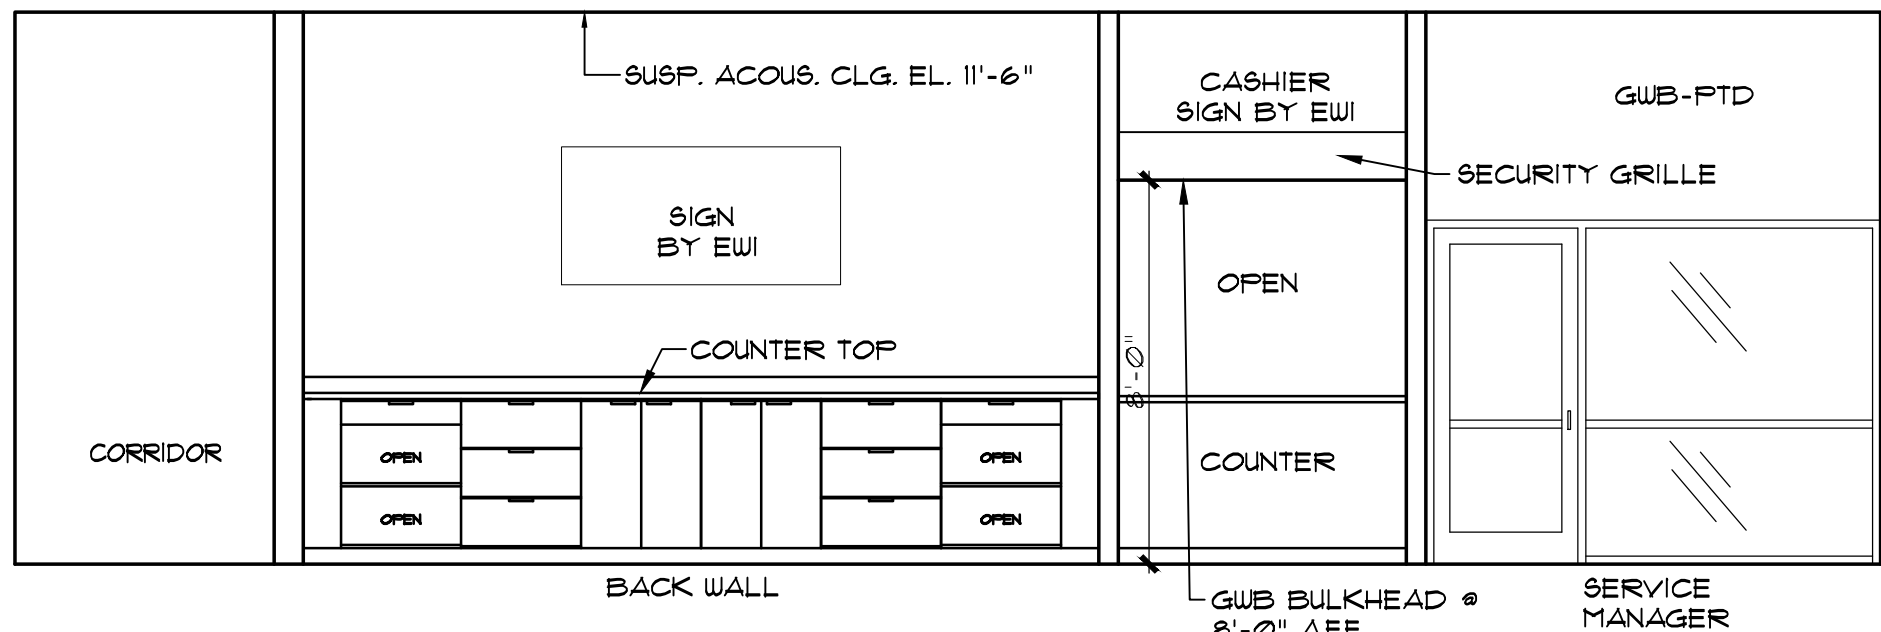


2
A-7.1
INTERIOR ELEVATION
SCALE: 1/4"=1'-0"

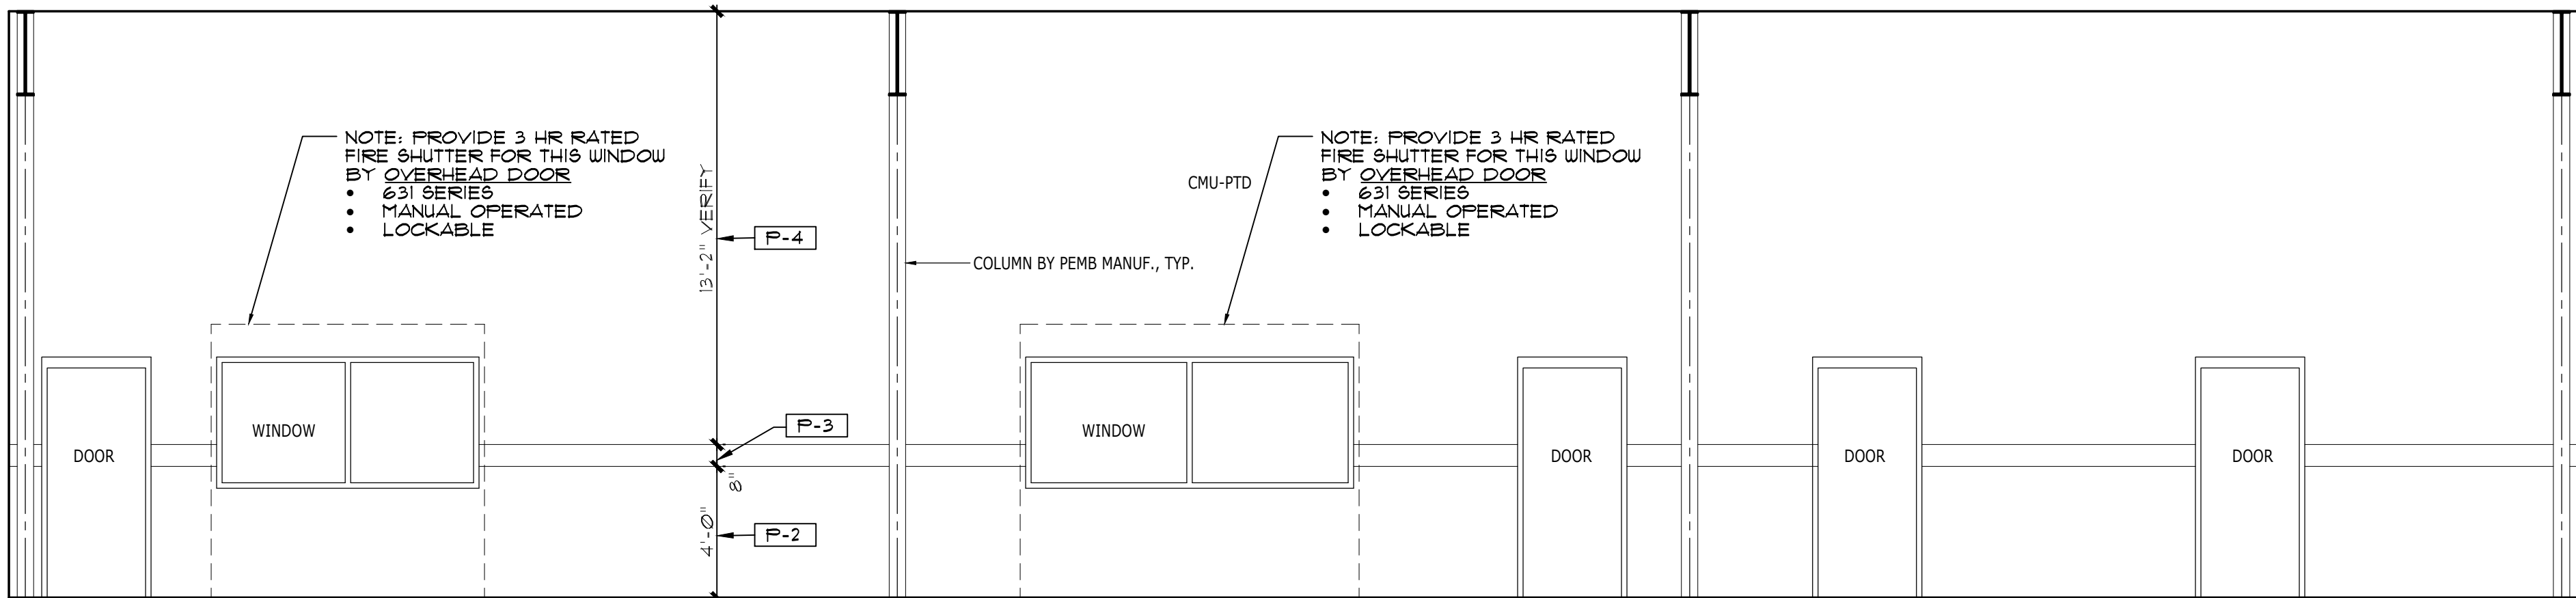

1
A-7.1
INTERIOR ELEVATION
SCALE: 1/4"=1'-0"

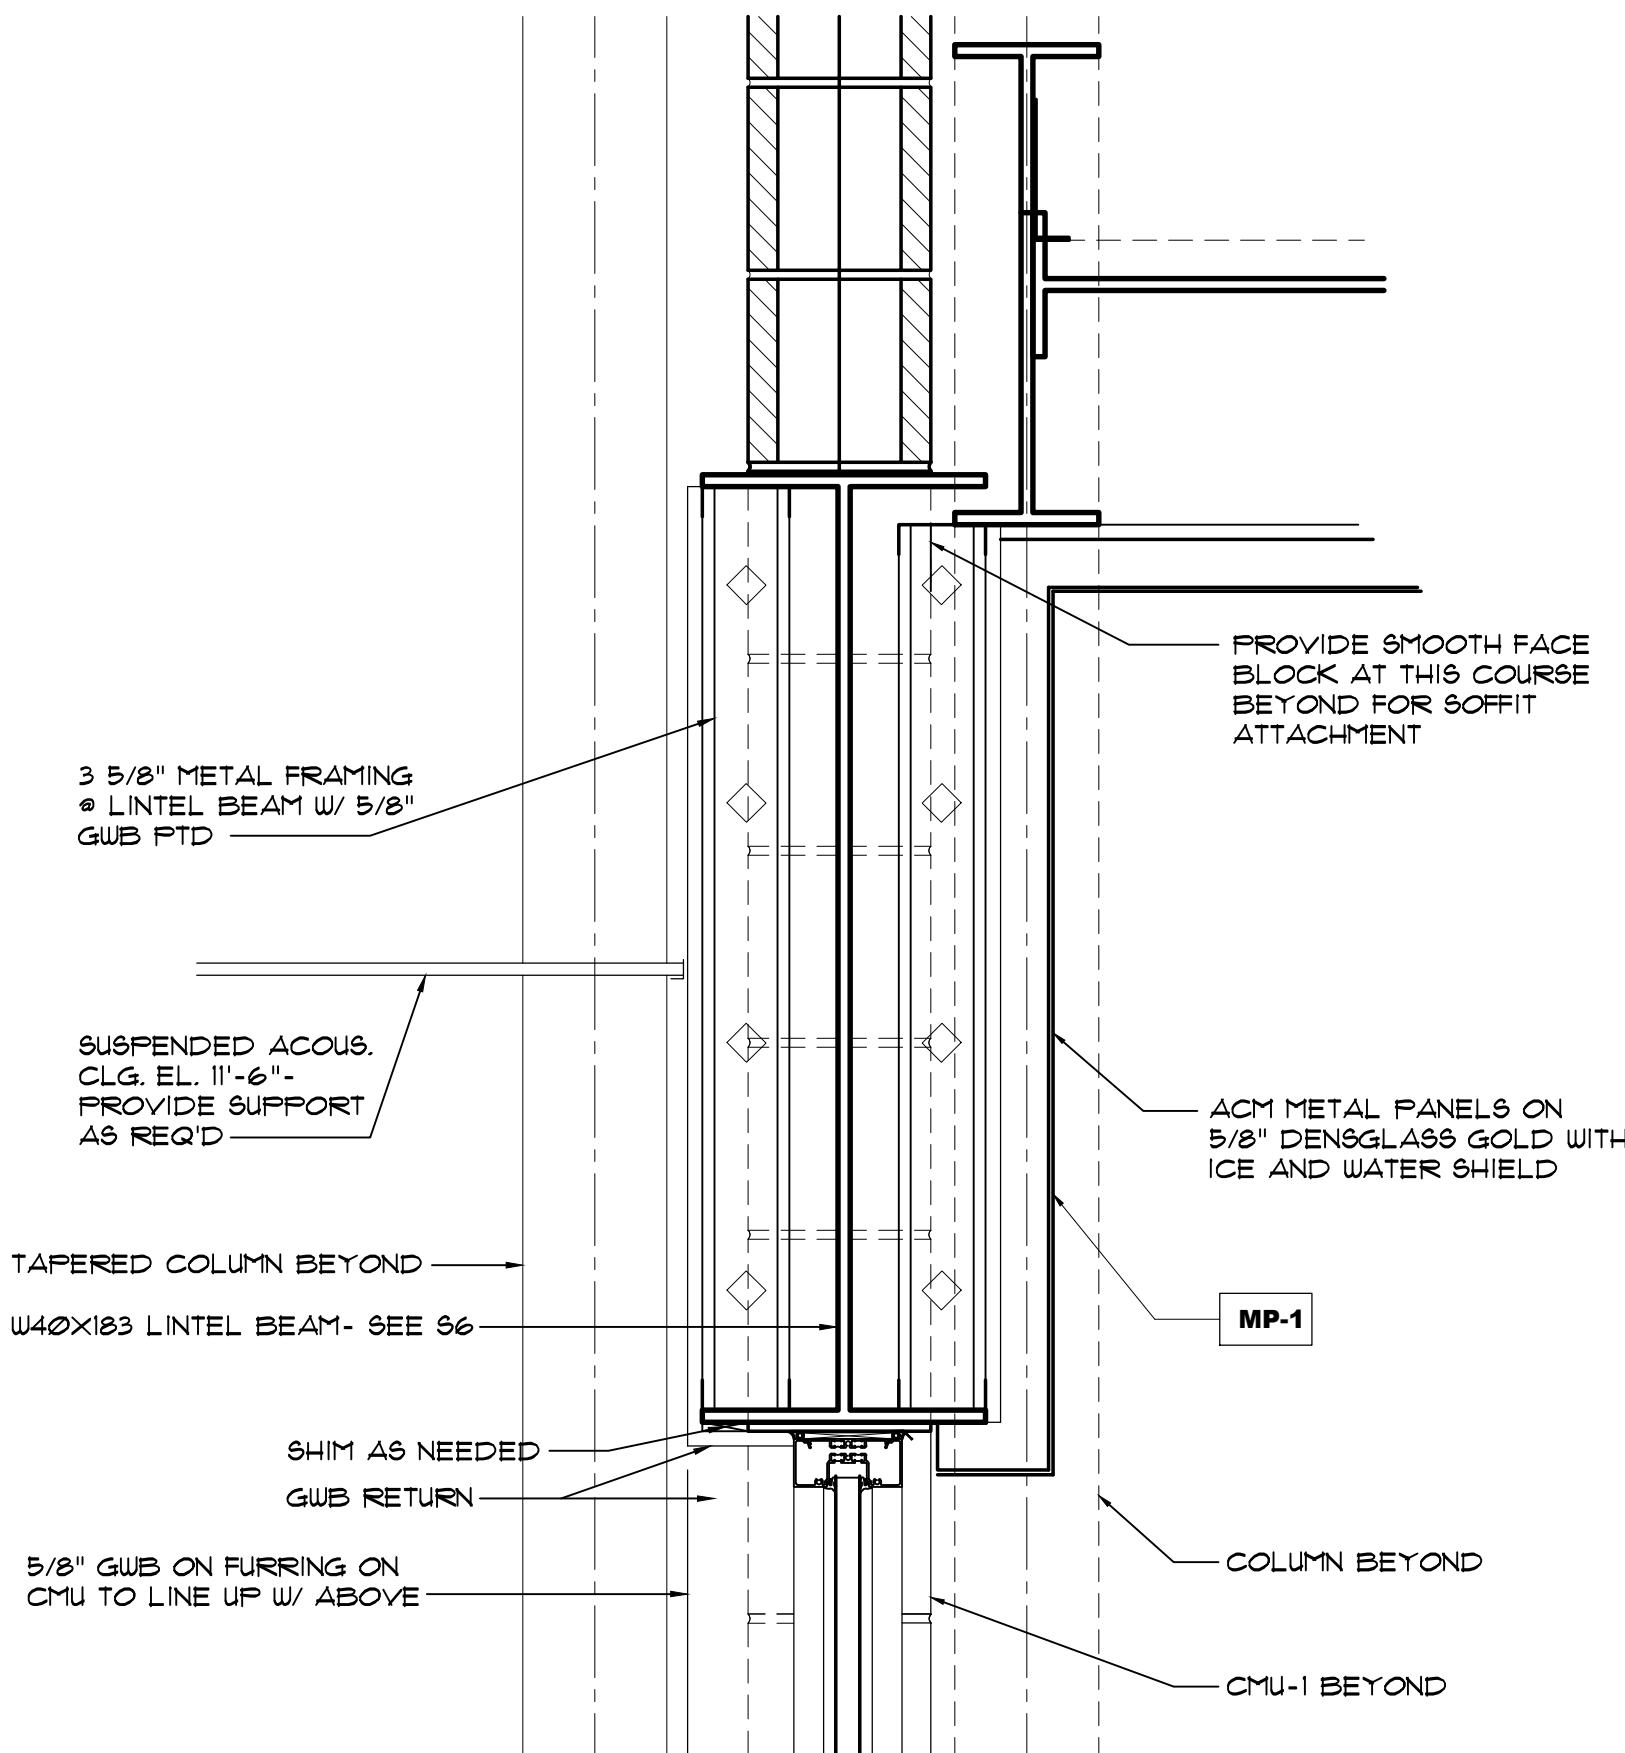

4
A-7.1
DETAIL @ W-BEAM LINTEL
SCALE: 1/2"=1'-0"

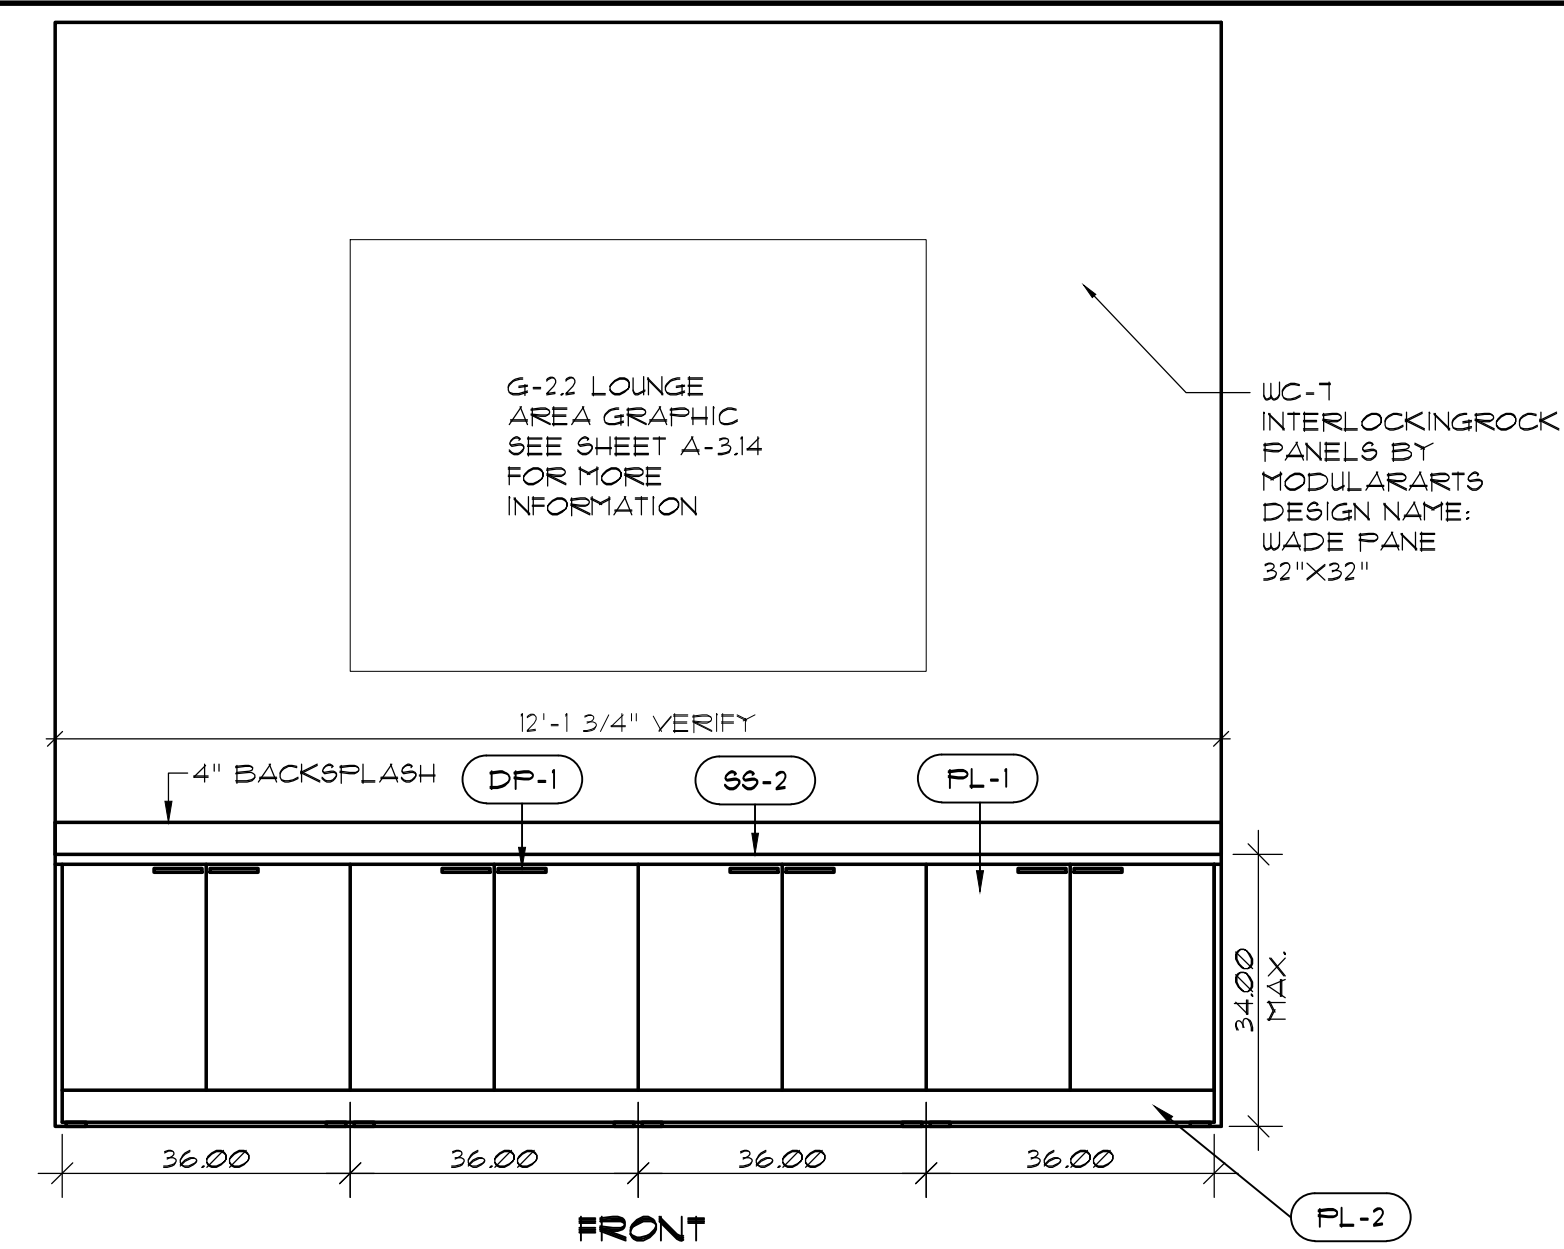

NOTE:
GENERAL CONTRACTOR TO PROVIDE ROUND, FLUSH, NON-METALLIC CONCRETE FLOOR BOXES-
LOCATED IN ACCORDANCE WITH FIXTURE VENDOR'S RECOMMENDATION - TO PROVIDE POWER, VOICE
DATA SERVICES TO FIXTURE. BOXES SHOULD HAVE A FLUSH POWDER-COATED ALUMINUM TILE FLANGE
COVER AND VESSEL/DORS, AND BE EQUIPPED WITH THE PROPER QUANTITY OF 20A, 120V RECEPTACLES
AND VOICE/DATA JACKS TO ADEQUATELY SERVE FIXTURE REQUIREMENTS.

